



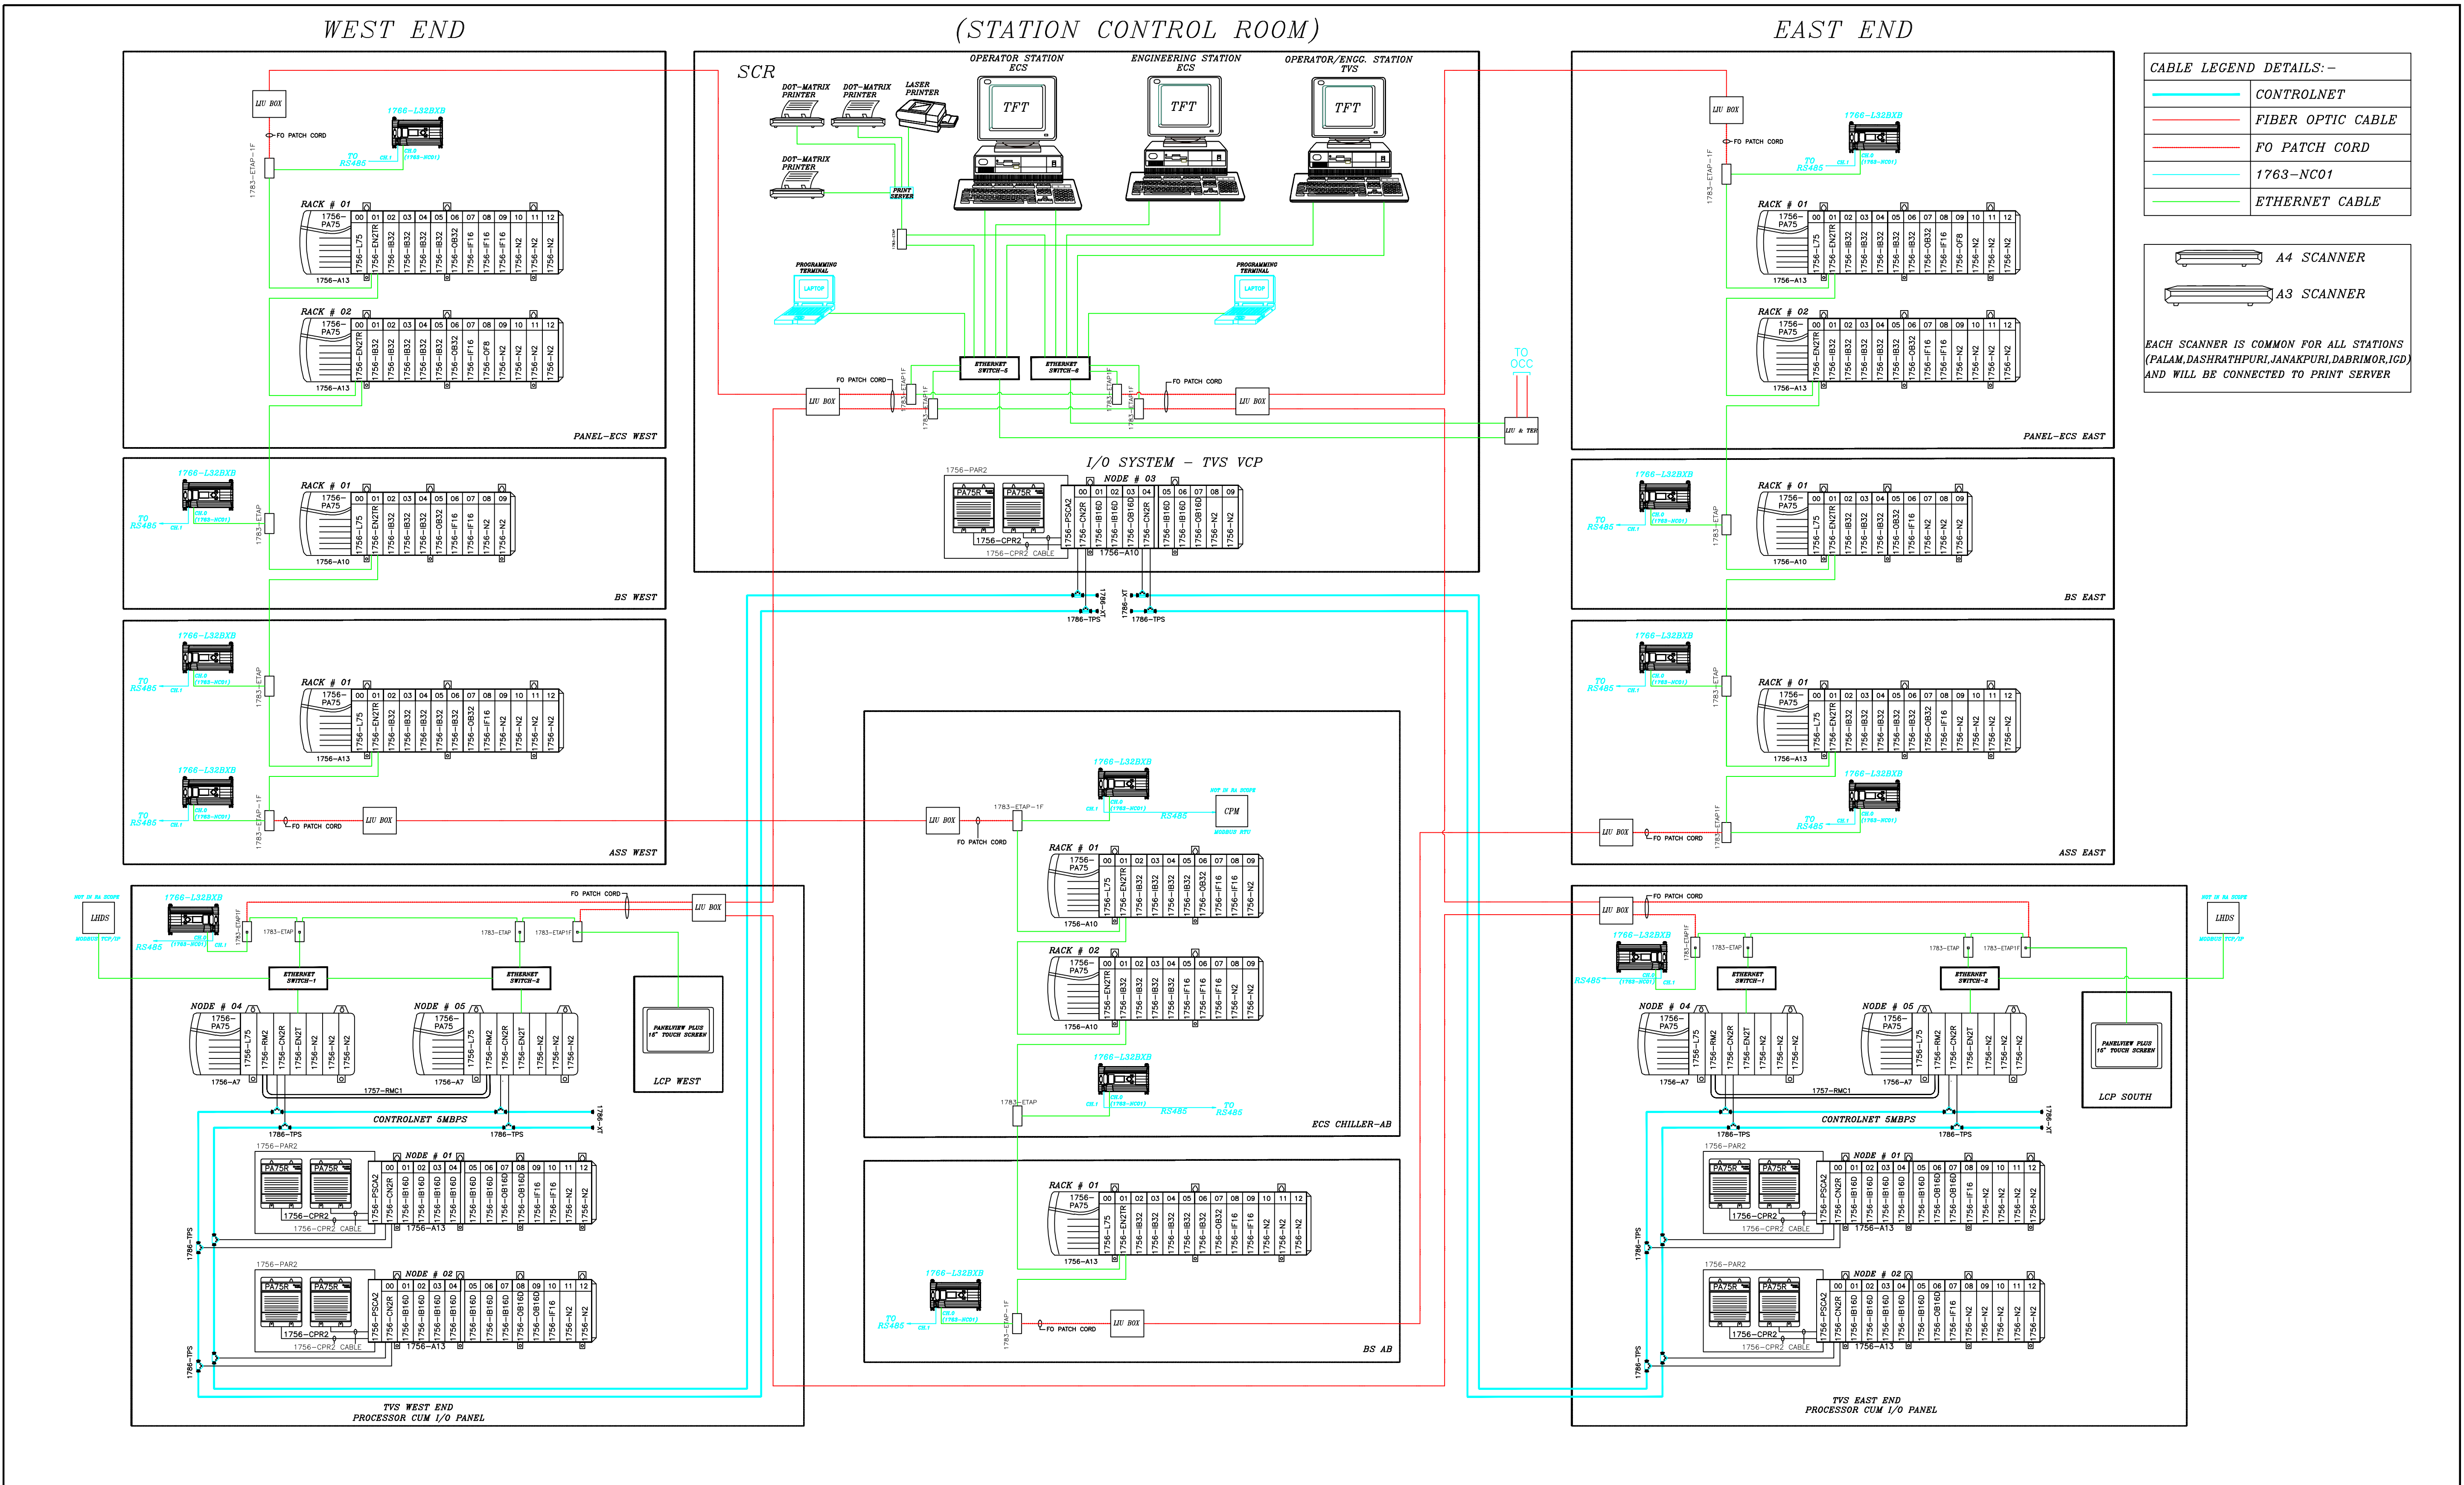

THIS DRAWING IS THE PROPERTY OF DELHI METRO RAIL CORPORATION LTD.	GENERAL NOTES: 1. ALL DIMENSIONS ARE IN MILLIMETERS. 2. ALL DIMENSIONS ARE TO BE READ AND NOT MEASURED. 3. ANY DISCREPANCIES MUST BE BROUGHT TO THE NOTICE OF THE DMRC BEFORE EXECUTION OF THE WORK AT SITE. 4. THIS DRAWING MUST BE READ IN CONJUNCTION WITH ALL RELEVANT ARCHITECTURAL, STRUCTURAL, PLUMBING & FIRE FIGHTING, ELECTRICAL, AND TRAFFIC MANAGEMENT DRAWINGS. 5. ALL DOOR/WINDOW CILL & LINTEL LEVELS ARE MEASURED FROM MAIN FLOOR FINISHED LEVELS.										REVISIONS						APPROVAL BY DMRC				Certified that this document has been designed and checked in accordance with DDC Quality Assurance Plan.			Authorised Signatory for DDC. JP/EW/1B/DDC01 Project Manager			 DELHI METRO RAIL CORPORATION LTD. Metro Bhawan , Fire Brigade Lane, Barakhamba Road, New Delhi-110001																																										
	REFERENCE DRAWINGS Dwg. No. Description																Architecture Design In-charge/ Coordinator		Structure Design In-charge/ Coordinator		E&M Design In-charge/ Coordinator		PHASE 1B JAIPUR METRO PROJECT																																														
																	DMRC APPROVAL				MGR/ARCH					DY CA (UG)-III		CA/ARCH																																									
																	DY CSTE/TELECOM				CSTE-I					DY CE/DESIGN		CE/TECH																																									
																	DY CSTE/AFC									ED/S&T		CSO																																									
																	DY CSTE/SIGNALLING				CSTE-III					GM/O		GM/M																																									
	REV										PARTICULARS						DRN.						CHD.						VER.						DATE						ISSUE DATE						REV. FOR CONSTRUCTION						DETAIL DESIGN CONSULTANT (DDC) FOR CIVIL, ARCHITECTURAL & BUILDING WORKS OF TWO UNDERGROUND STATION (CHOTI CHOUPAR & BADI CHOUPAR), SHAFT AND TUNNELS OF PHASE 1B OF JAIPUR METRO				 Engineering. Information. Imagination.		56, Indo-Asia House, Institutional Area, sector-44 Gurgaon - 122002 (Haryana)		DRAWN BY: ADIL			CHECKED BY: VIKAS		VERIFIED BY: L.R.S		JP/1B/DDC01	ECS/TVS
																																																					DATE: 04-01-2016		REV: RO		GRAPHICAL SCALE: NTS		STATUS: CRD										
																																																					DRAWING NUMBER: JP-CRD-ECS-TVS-SC-1801				SHEET NO. 1 OF 1		SHEET SIZE UNE A1					ORDER N° P36-0017					
	This drawing must not be either loaned, copied or otherwise reproduced in whole or in part or used for any purpose without the prior written permission of DMRC.																																																																				

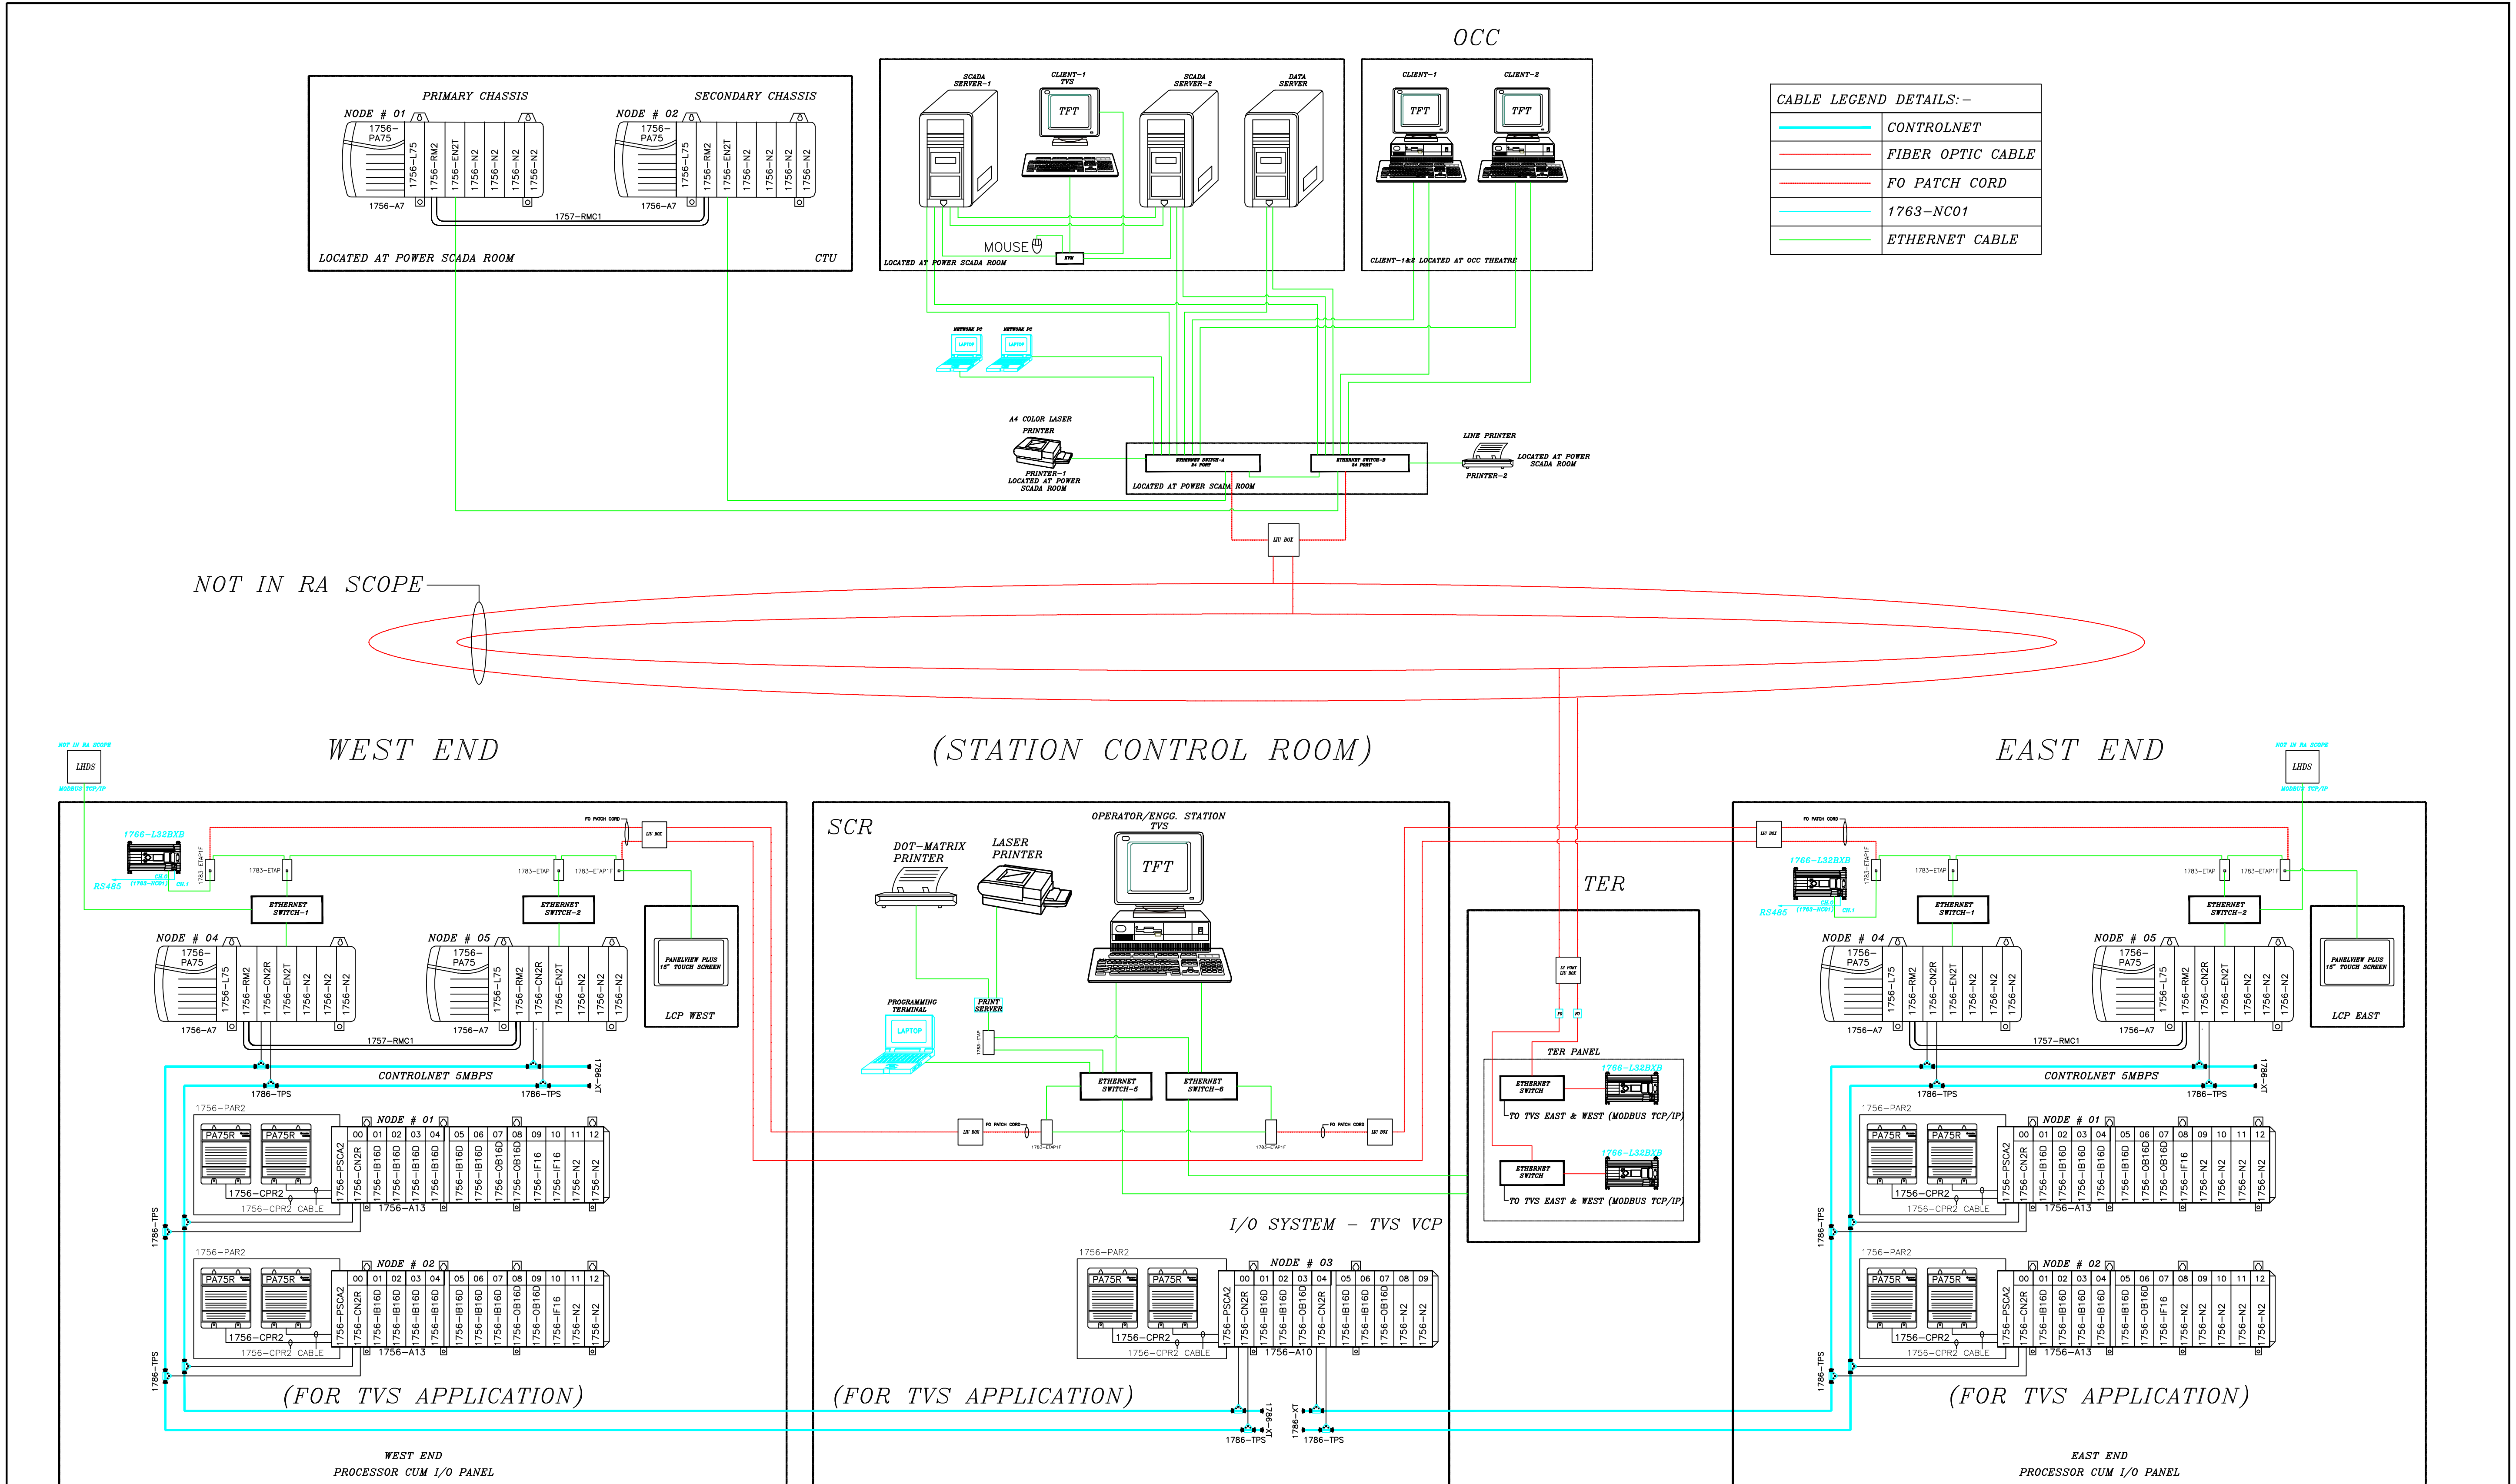

THIS DRAWING IS THE PROPERTY OF DELHI METRO RAIL CORPORATION LTD.	GENERAL NOTES: 1. ALL DIMENSIONS ARE IN MILLIMETERS. 2. ALL DIMENSIONS ARE TO BE READ AND NOT MEASURED. 3. ANY DISCREPANCIES MUST BE BROUGHT TO THE NOTICE OF THE DMRC BEFORE EXECUTION OF THE WORK AT SITE. 4. THIS DRAWING MUST BE READ IN CONJUNCTION WITH ALL RELEVANT ARCHITECTURAL, STRUCTURAL, PLUMBING & FIRE FIGHTING, ELECTRICAL AND TRAFFIC MANAGEMENT DRAWINGS. 5. ALL DOOR/WINDOW SILL & LINTEL LEVELS ARE MEASURED FROM MAIN FLOOR FINISHED LEVELS.							REVISIONS				APPROVAL BY DMRC				Certified that this document has been designed and checked in accordance with DDC Quality Assurance Plan.			Authorised Signatory for DDC. JP/EW/1B/DDC01 Project Manager			 DELHI METRO RAIL CORPORATION LTD. Metro Bhawan , Fire Brigade Lane, Barakhamba Road, New Delhi-110001 PHASE 1B JAIPUR METRO PROJECT STATION: BADI & CHOTI CHOUPAR DRAWING TITLE: SYSTEM CONFIGURATION-TVS <table><tr><td colspan="2">DRAWN BY: ADIL</td><td colspan="2">CHECKED BY: VIKAS</td><td colspan="2">VERIFIED BY: L.R.S</td></tr><tr><td>DATE: 04-01-2016</td><td>REV: R0</td><td colspan="2">GRAPHICAL SCALE: NTS</td><td colspan="2">STATUS: CRD</td></tr><tr><td colspan="2">DRAWING NUMBER: JP-CRD-ECS-TVS-SC-1902</td><td colspan="2">SHEET NO. 1 OF 1</td><td colspan="2">SHEET SIZE: UNE A1</td></tr><tr><td colspan="2"></td><td colspan="2"></td><td colspan="2">ORDER N° P38-0017</td></tr></table> This drawing must not be either loaned, copied or otherwise reproduced in whole or in part or used for any purpose without the prior written permission of DMRC.		DRAWN BY: ADIL		CHECKED BY: VIKAS		VERIFIED BY: L.R.S		DATE: 04-01-2016	REV: R0	GRAPHICAL SCALE: NTS		STATUS: CRD		DRAWING NUMBER: JP-CRD-ECS-TVS-SC-1902		SHEET NO. 1 OF 1		SHEET SIZE: UNE A1						ORDER N° P38-0017	
	DRAWN BY: ADIL		CHECKED BY: VIKAS		VERIFIED BY: L.R.S																																										
	DATE: 04-01-2016	REV: R0	GRAPHICAL SCALE: NTS		STATUS: CRD																																										
	DRAWING NUMBER: JP-CRD-ECS-TVS-SC-1902		SHEET NO. 1 OF 1		SHEET SIZE: UNE A1																																										
					ORDER N° P38-0017																																										
	REFERENCE DRAWINGS															Architecture Design In-charge/ Coordinator			Structure Design In-charge/ Coordinator					E&M Design In-charge/ Coordinator																							
	Drg. No.							Description											DETAIL DESIGN CONSULTANT (DDC) FOR CIVIL, ARCHITECTURAL & BUILDING WORKS OF TWO UNDERGROUND STATION (CHOTI CHOUPAR & BADI CHOUPAR), SHAFT AND TUNNELS OF PHASE 1B OF JAIPUR METRO  Engineering. Information. Imagination. 56, Indo-Asia House, Institutional Area, sector-44 Gurgaon - 122002 (Haryana)																												
REV							PARTICULARS							DMRC APPROVAL				MGR/ARCH			DY CA (UG)-III			CA/ARCH																							
														DY CSTE/TELECOM				CSTE-I			DY CE/DESIGN			CE/TECH																							
														DY CSTE/AFC							ED/S&T			CSO																							
														DY CSTE/SIGNALLING				CSTE-III			GM/O			GM/M																							
														DY CE/PLANNING				DY CEE/E&M			DY CEE/ECS			ED/ELEC-II																							
														DY CEE/E/UG-TR				CGM(E) UG-TR			PM			CPM																							

LIST OF BMS SCHEMATIC DRAWINGS

S.NO.	DRAWING TITLE	SHEET	DRAWING NO.	REVISION
01	LIST OF BMS SCHEMATIC DRAWINGS	SHEET 1 OF 1	JP-TD-ECS-TVS-1001	R0
02	SYSTEM CONFIGURATION-ECS	SHEET 1 OF 1	JP-TD-ECS-TVS-SC-1901	R0
03	SYSTEM CONFIGURATION-TVS	SHEET 1 OF 1	JP-TD-ECS-TVS-SC-1902	R0

[illegible]