
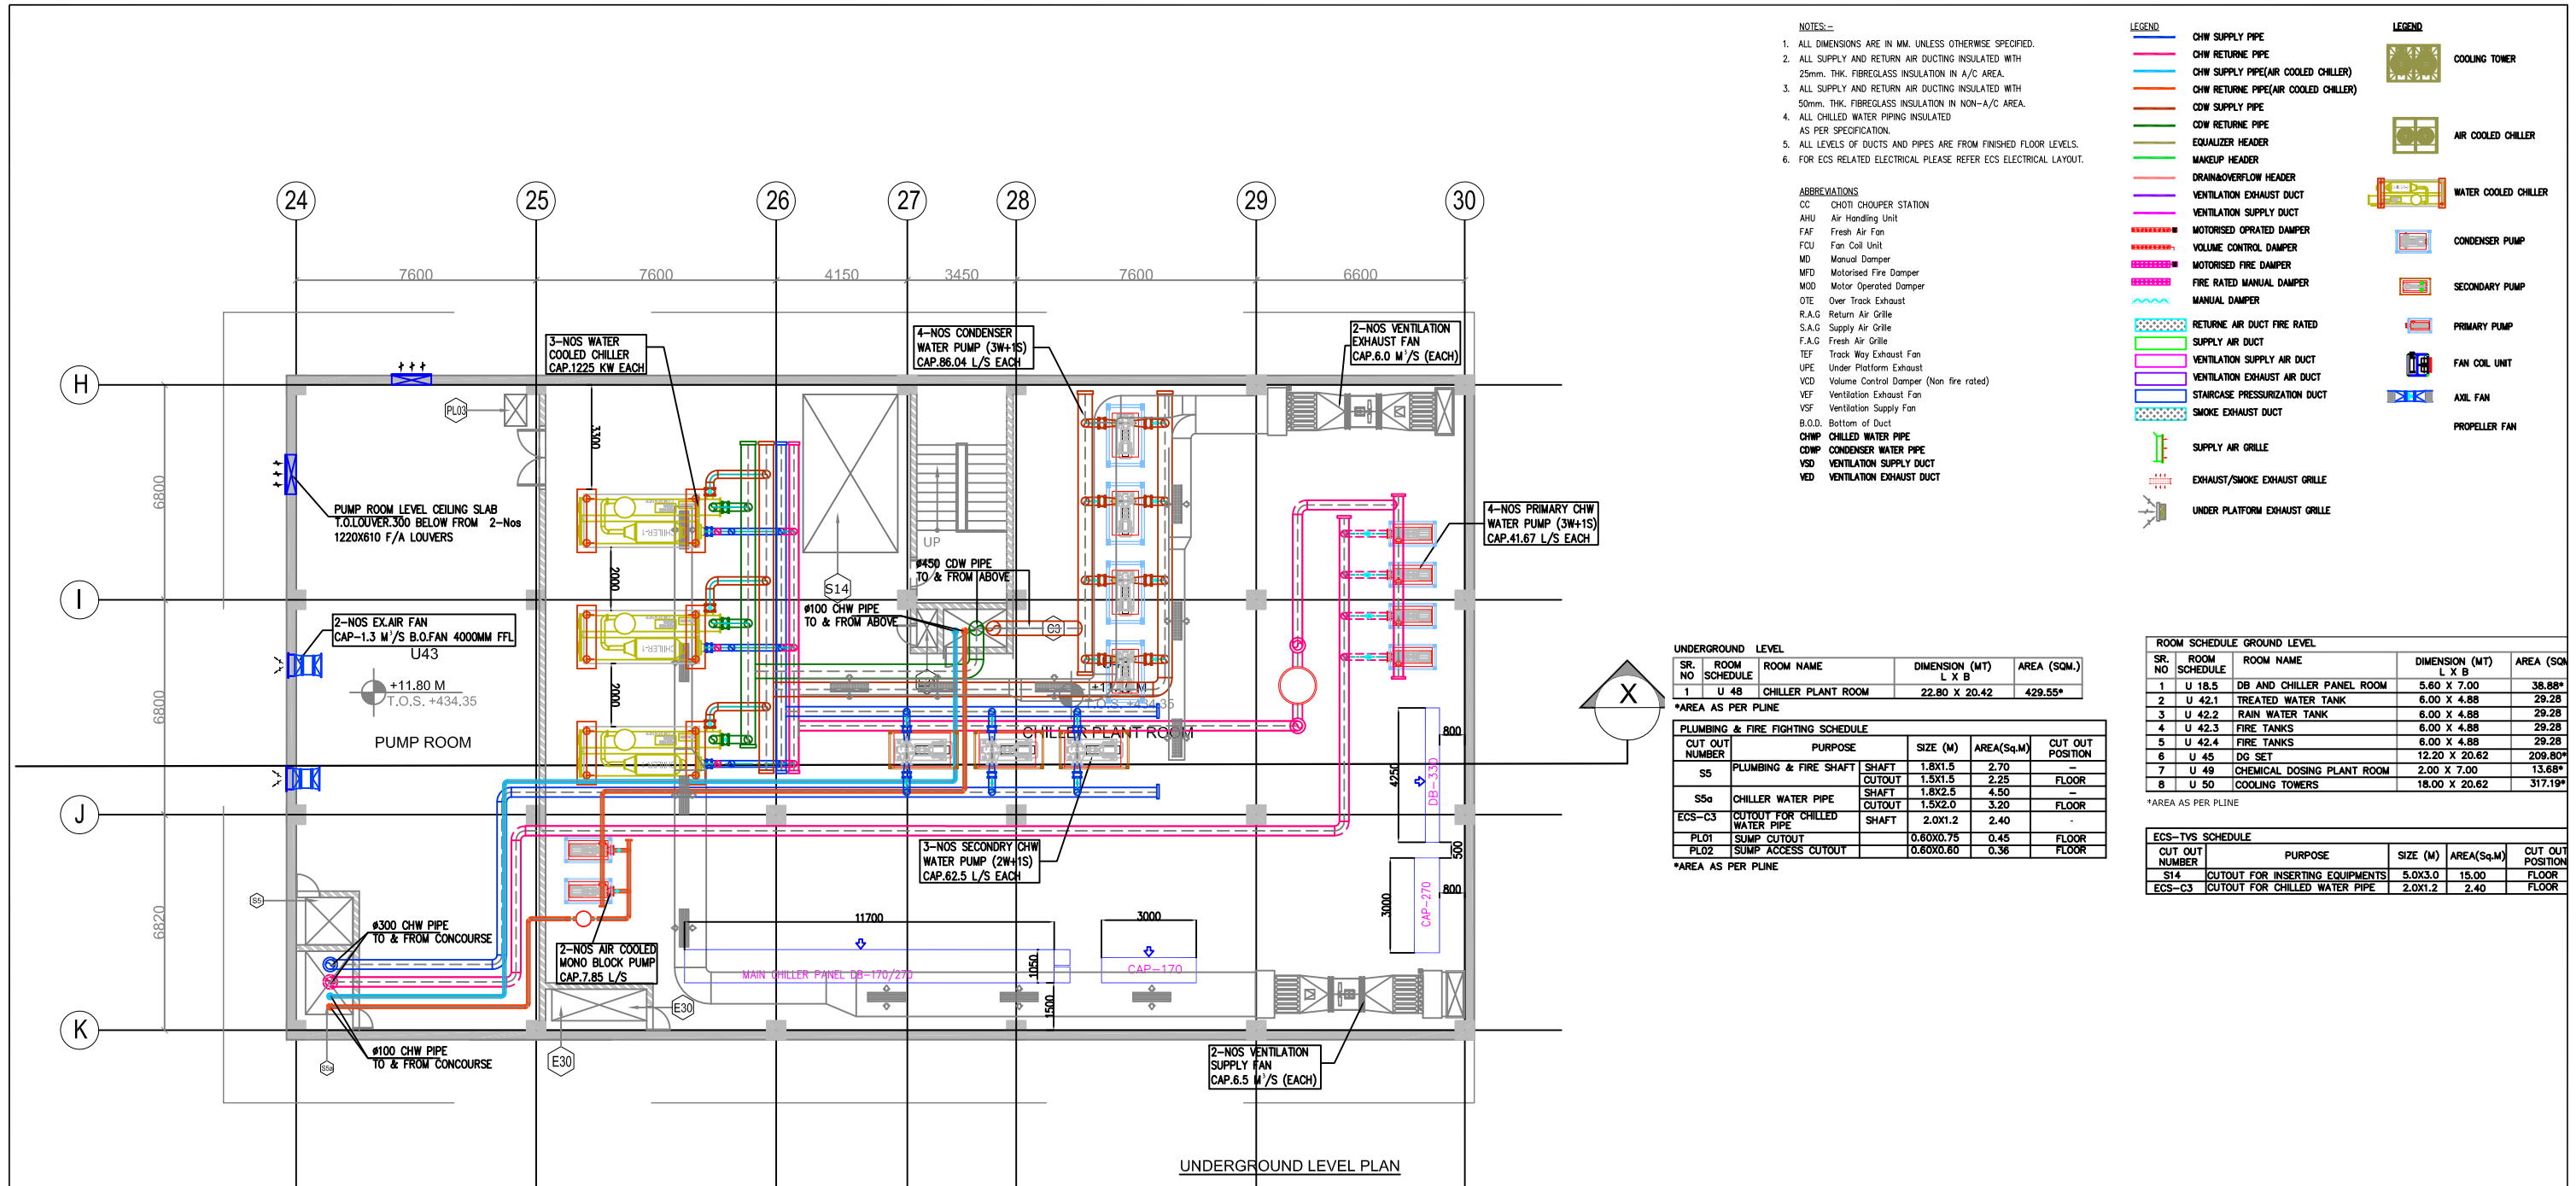


THIS DRAWING IS THE PROPERTY OF DELHI METRO RAIL CORPORATION LTD.	GENERAL NOTES: 1. ALL DIMENSIONS ARE IN MILLIMETERS. 2. ALL DIMENSIONS ARE TO BE READ AND NOT MEASURED. 3. ANY DISCREPANCIES MUST BE BROUGHT TO THE NOTICE OF THE DMRC BEFORE EXECUTION OF THE WORK AT SITE. 4. THIS DRAWING MUST BE READ IN CONJUNCTION WITH ALL RELEVANT ARCHITECTURAL, STRUCTURAL, PLUMBING & FIRE FIGHTING, ELECTRICAL AND TRAFFIC MANAGEMENT DRAWINGS. 5. ALL DOOR/WINDOW CILL & LINTEL LEVELS ARE MEASURED FROM MAIN FLOOR FINISHED LEVELS.							REVISIONS							APPROVAL BY DMRC				Certified that this document has been designed and checked in accordance with DDC Quality Assurance Plan.				Authorised Signatory for DDC. JP/EW/1B/DDC01 Project Manager				 DELHI METRO RAIL CORPORATION LTD. Metro Bhawan , Fire Brigade Lane, Barakhamba Road, New Delhi-110001	
	REFERENCE DRAWINGS							REV	PARTICULARS	DRN.	CHD.	VER.	DATE	ISSUE DATE	REV. FOR CONSTRUCTION	DMRC APPROVAL	MGR/ARCH	DY CA (UG)-III	CA/ARCH	Architecture Design In-charge/ Coordinator	Structure Design In-charge/ Coordinator	E&M Design In-charge/ Coordinator						
	Drg. No.															DY CSTE/TELECOM	CSTE-I	DY CE/DESIGN	CE/TECH	DETAIL DESIGN CONSULTANT (DDC) FOR CIVIL, ARCHITECTURAL & BUILDING WORKS OF TWO UNDERGROUND STATION (CHOTI CHOUPAR & BADI CHOUPAR), SHAFT AND TUNNELS OF PHASE 1B OF JAIPUR METRO								
	Description															DY CSTE/AFC		ED/S&T	CSO									
																DY CSTE/SIGNALLING	CSTE-III	GM/O	GMM				 Engineering, Information, Imagination.					
																DY CE/PLANNING	DY CEE/E&M	DY CEE/ECS	ED/ELEC-II							56, Indo-Asia House, Institutional Area, sector-44 Gurgaon - 122002 (Haryana)		
																DY CEE/(E)UG-TR	CGM(E) UG-TR	PM	CPM	PHASE 1B JAIPUR METRO PROJECT								
																							STATION: CHOTI CHOUPAR					
																										DRAWING TITLE: ECS LAYOUT ANCILLARY BUILDING LOWER GROUND LEVEL		
																							DRAWN BY: ADIL CHECKED BY: NITIN VERIFIED BY: L.R.S					
														DATE: 31.03-2015 REV: R0 GRAPHICAL SCALE: 1:100 STATUS: FOR TENDER														
																	DRAWING NUMBER: JP-TD-ECS-10CC-1201 SHEET NO. 1 OF 2 SHEET SIZE UNE A1 ORDER N° P36-0017											
														JP/EW/1B/DDC01 ECS														
																	This drawing must not be either loaned, copied or otherwise reproduced in whole or in part or used for any purpose without the prior written permission of DMRC.											

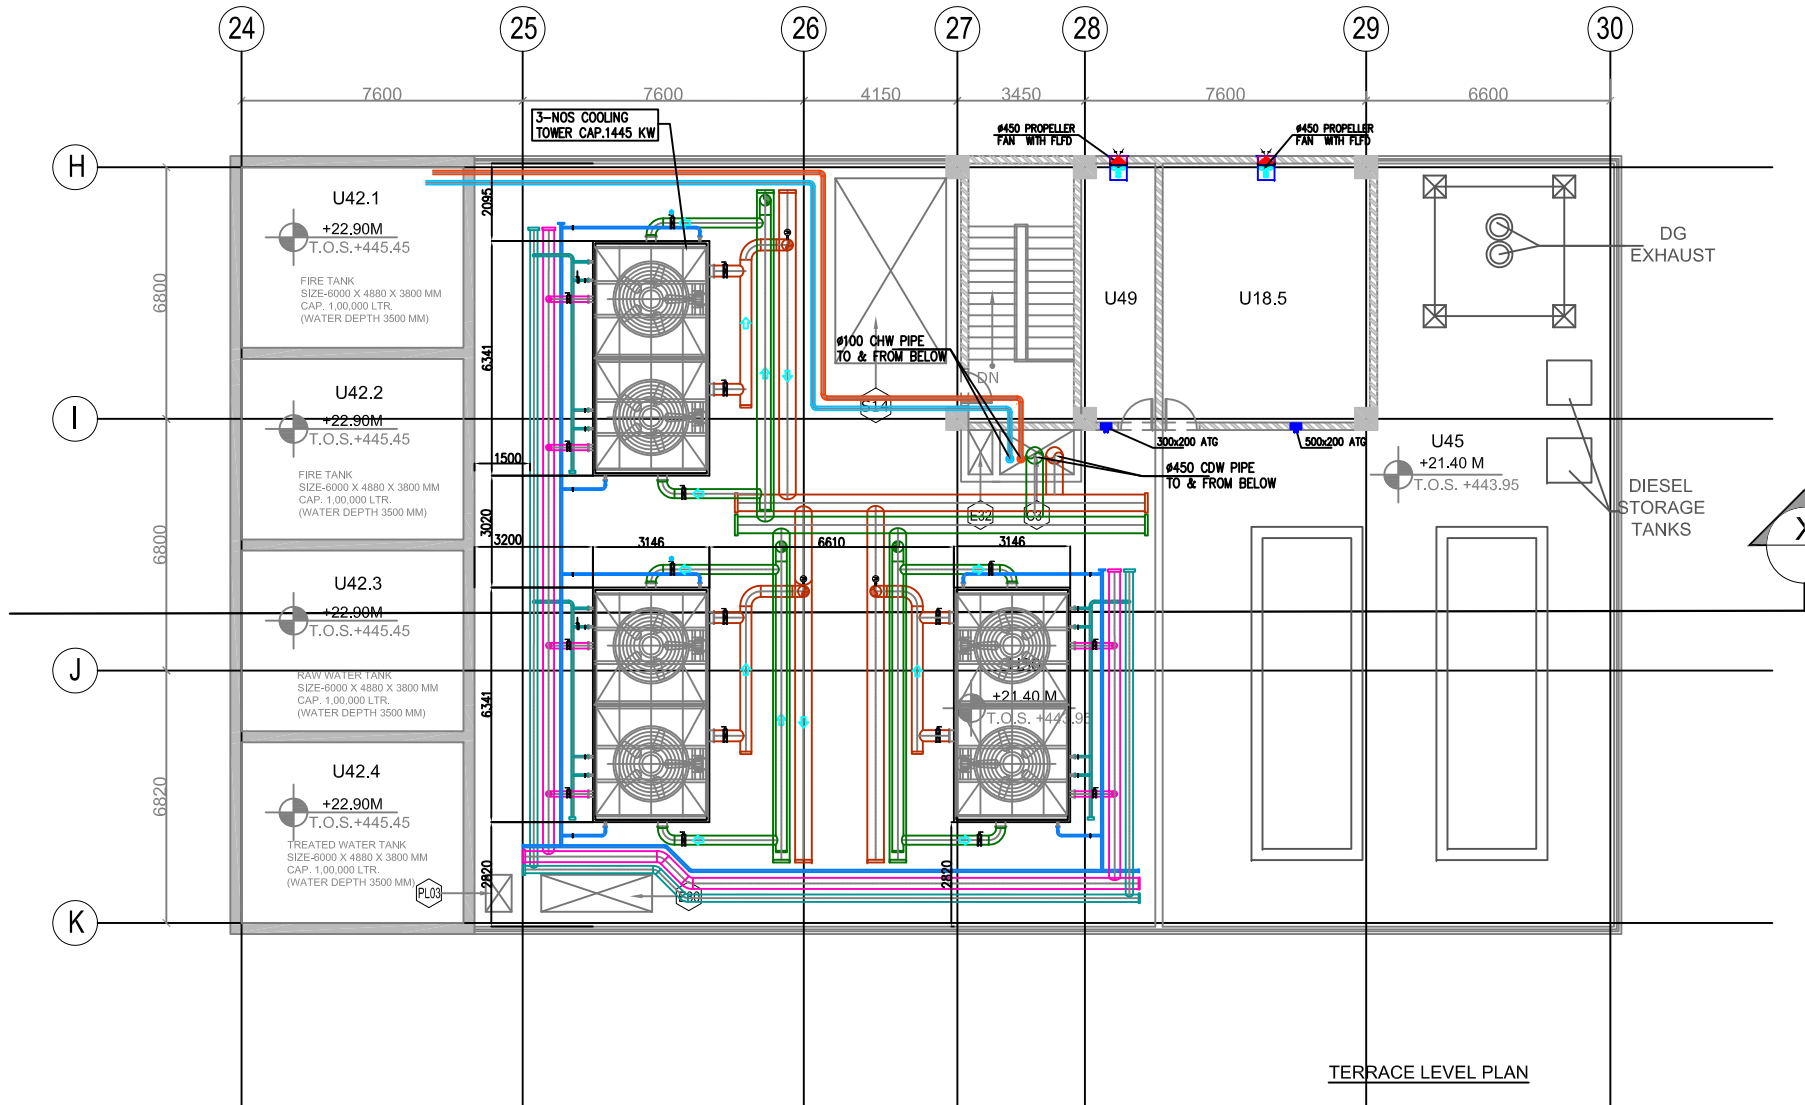

- NOTES:-
1. ALL DIMENSIONS ARE IN MM. UNLESS OTHERWISE SPECIFIED.
 2. ALL SUPPLY AND RETURN AIR DUCTING INSULATED WITH 25mm. THK. FIBREGLASS INSULATION IN A/C AREA.
 3. ALL SUPPLY AND RETURN AIR DUCTING INSULATED WITH 50mm. THK. FIBREGLASS INSULATION IN NON-A/C AREA.
 4. ALL CHILLED WATER PIPING INSULATED AS PER SPECIFICATION.
 5. ALL LEVELS OF DUCTS AND PIPES ARE FROM FINISHED FLOOR LEVELS.
 6. FOR ECS RELATED ELECTRICAL PLEASE REFER ECS ELECTRICAL LAYOUT.


- ABBREVIATIONS
- CC CHOTI CHOUPAR STATION
AHU Air Handling Unit
FAF Fresh Air Fan
FCU Fan Coil Unit
MD Manual Damper
MFD Motorised Fire Damper
MOD Motor Operated Damper
OTE Over Track Exhaust
R.A.G Return Air Grille
S.A.G Supply Air Grille
F.A.G Fresh Air Grille
TEF Track Way Exhaust Fan
UPE Under Platform Exhaust
VCD Volume Control Damper (Non fire rated)
VEF Ventilation Exhaust Fan
VSF Ventilation Supply Fan
B.O.D. Bottom of Duct
CHWP CHILLED WATER PIPE
CWMP CONDENSER WATER PIPE
VSD VENTILATION SUPPLY DUCT
VED VENTILATION EXHAUST DUCT

- LEGEND
- CHW SUPPLY PIPE
CHW RETURN PIPE
CHW SUPPLY PIPE(AIR COOLED CHILLER)
CHW RETURN PIPE(AIR COOLED CHILLER)
CDW SUPPLY PIPE
CDW RETURN PIPE
EQUALIZER HEADER
MAKEUP HEADER
DRAIN/OVERFLOW HEADER
VENTILATION EXHAUST DUCT
VENTILATION SUPPLY DUCT
MOTORISED OPERATED DAMPER
VOLUME CONTROL DAMPER
MOTORISED FIRE DAMPER
FIRE RATED MANUAL DAMPER
MANUAL DAMPER
RETURN AIR DUCT FIRE RATED
SUPPLY AIR DUCT
VENTILATION SUPPLY AIR DUCT
VENTILATION EXHAUST AIR DUCT
STAIRCASE PRESSURIZATION DUCT
SMOKE EXHAUST DUCT
SUPPLY AIR GRILLE
EXHAUST/SMOKE EXHAUST GRILLE
UNDER PLATFORM EXHAUST GRILLE
- LEGEND
- COOLING TOWER
AIR COOLED CHILLER
WATER COOLED CHILLER
CONDENSER PUMP
SECONDARY PUMP
PRIMARY PUMP
FAN COIL UNIT
AXIAL FAN
PROPELLER FAN

UNDERGROUND LEVEL				
SR. NO	ROOM SCHEDULE	ROOM NAME	DIMENSION (MT) L X B	AREA (SQM.)
1	U 48	CHILLER PLANT ROOM	22.80 X 20.42	429.55*
*AREA AS PER PLINE				
PLUMBING & FIRE FIGHTING SCHEDULE				
CUT OUT NUMBER	PURPOSE	SIZE (M)	AREA(Sq.M)	CUT OUT POSITION
S5	PLUMBING & FIRE SHAFT	SHAFT 1.8X1.5	2.70	-
		CUTOUT 1.5X1.5	2.25	FLOOR
S5a	CHILLER WATER PIPE	SHAFT 1.8X2.5	4.50	-
		CUTOUT 1.5X2.0	3.20	FLOOR
ECS-C3	CUTOUT FOR CHILLED WATER PIPE	SHAFT 2.0X1.2	2.40	-
PL01	SUMP CUTOUT	0.60X0.75	0.45	FLOOR
PL02	SUMP ACCESS CUTOUT	0.60X0.60	0.36	FLOOR
*AREA AS PER PLINE				


ROOM SCHEDULE GROUND LEVEL				
SR. NO	ROOM SCHEDULE	ROOM NAME	DIMENSION (MT) L X B	AREA (SQM.)
1	U 18.5	DB AND CHILLER PANEL ROOM	5.60 X 7.00	38.88*
2	U 42.1	TREATED WATER TANK	6.00 X 4.88	29.28
3	U 42.2	RAIN WATER TANK	6.00 X 4.88	29.28
4	U 42.3	FIRE TANKS	6.00 X 4.88	29.28
5	U 42.4	FIRE TANKS	6.00 X 4.88	29.28
6	U 45	DG SET	12.20 X 20.62	208.80*
7	U 49	CHEMICAL DOSING PLANT ROOM	2.00 X 7.00	13.68*
8	U 50	COOLING TOWERS	18.00 X 20.62	317.19*
*AREA AS PER PLINE				

ECS-TVS SCHEDULE				
CUT OUT NUMBER	PURPOSE	SIZE (M)	AREA(Sq.M)	CUT OUT POSITION
S14	CUTOUT FOR INSERTING EQUIPMENTS	5.0X3.0	15.00	FLOOR
ECS-C3	CUTOUT FOR CHILLED WATER PIPE	2.0X1.2	2.40	FLOOR

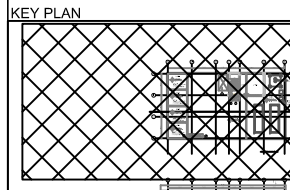

THIS DRAWING IS THE PROPERTY OF DELHI METRO RAIL CORPORATION LTD.	GENERAL NOTES: 1. ALL DIMENSIONS ARE IN MILLIMETERS. 2. ALL DIMENSIONS ARE TO BE READ AND NOT MEASURED. 3. ANY DISCREPANCIES MUST BE BROUGHT TO THE NOTICE OF THE DMRC BEFORE EXECUTION OF THE WORK AT SITE. 4. THIS DRAWING MUST BE READ IN CONJUNCTION WITH ALL RELEVANT ARCHITECTURAL, STRUCTURAL, PLUMBING & FIRE FIGHTING, ELECTRICAL AND TRAFFIC MANAGEMENT DRAWINGS. 5. ALL DOOR/WINDOW CILL & LINTEL LEVELS ARE MEASURED FROM MAIN FLOOR FINISHED LEVELS.		REVISIONS						APPROVAL BY DMRC				Certified that this document has been designed and checked in accordance with DDC Quality Assurance Plan.			Authorised Signatory for DDC. JP/EW/1B/DDC01 Project Manager			 DELHI METRO RAIL CORPORATION LTD. Metro Bhawan , Fire Brigade Lane, Barakhamba Road, New Delhi-110001		
	REFERENCE DRAWINGS												Architecture Design In-charge/ Coordinator			Structure Design In-charge/ Coordinator					E&M Design In-charge/ Coordinator
	Dwg. No.												DETAIL DESIGN CONSULTANT (DDC) FOR CIVIL, ARCHITECTURAL & BUILDING WORKS OF TWO UNDERGROUND STATION (CHOTI CHOUPAR & BADI CHOUPAR), SHAFT AND TUNNELS OF PHASE 1B OF JAIPUR METRO  Engineering, Information, Imagination. 56, Indo-Asia House, Institutional Area, sector-44 Gurgaon - 122002 (Haryana)			JP/EW/1B/DDC01 ECS					
	Description																				
	REV	PARTICULARS	DRN.	CHD.	VER.	DATE	ISSUE DATE	REV. FOR CONSTRUCTION	DMRC APPROVAL	MGR/ARCH	DY CA (UG)-III	CA/ARCH	DY CSTE/TELECOM	CSTE-I	DY CE/DESIGN	CE/TECH					
									DY CSTE/AFC	CSTE-II	ED/S&T	CSO									
									DY CSTE/SIGNALLING		GM/O	GMM									
									DY CE/PLANNING	DY CEE/E&M	DY CEE/ECS	ED/ELEC-II									
								DY CEE/(E)UG-TR	CGM(E) UG-TR	PM	CPM										

ayesa Engineering, Information, Imagination.
56, Indo-Asia House, Institutional Area, sector-44
Gurgaon - 122002 (Haryana)

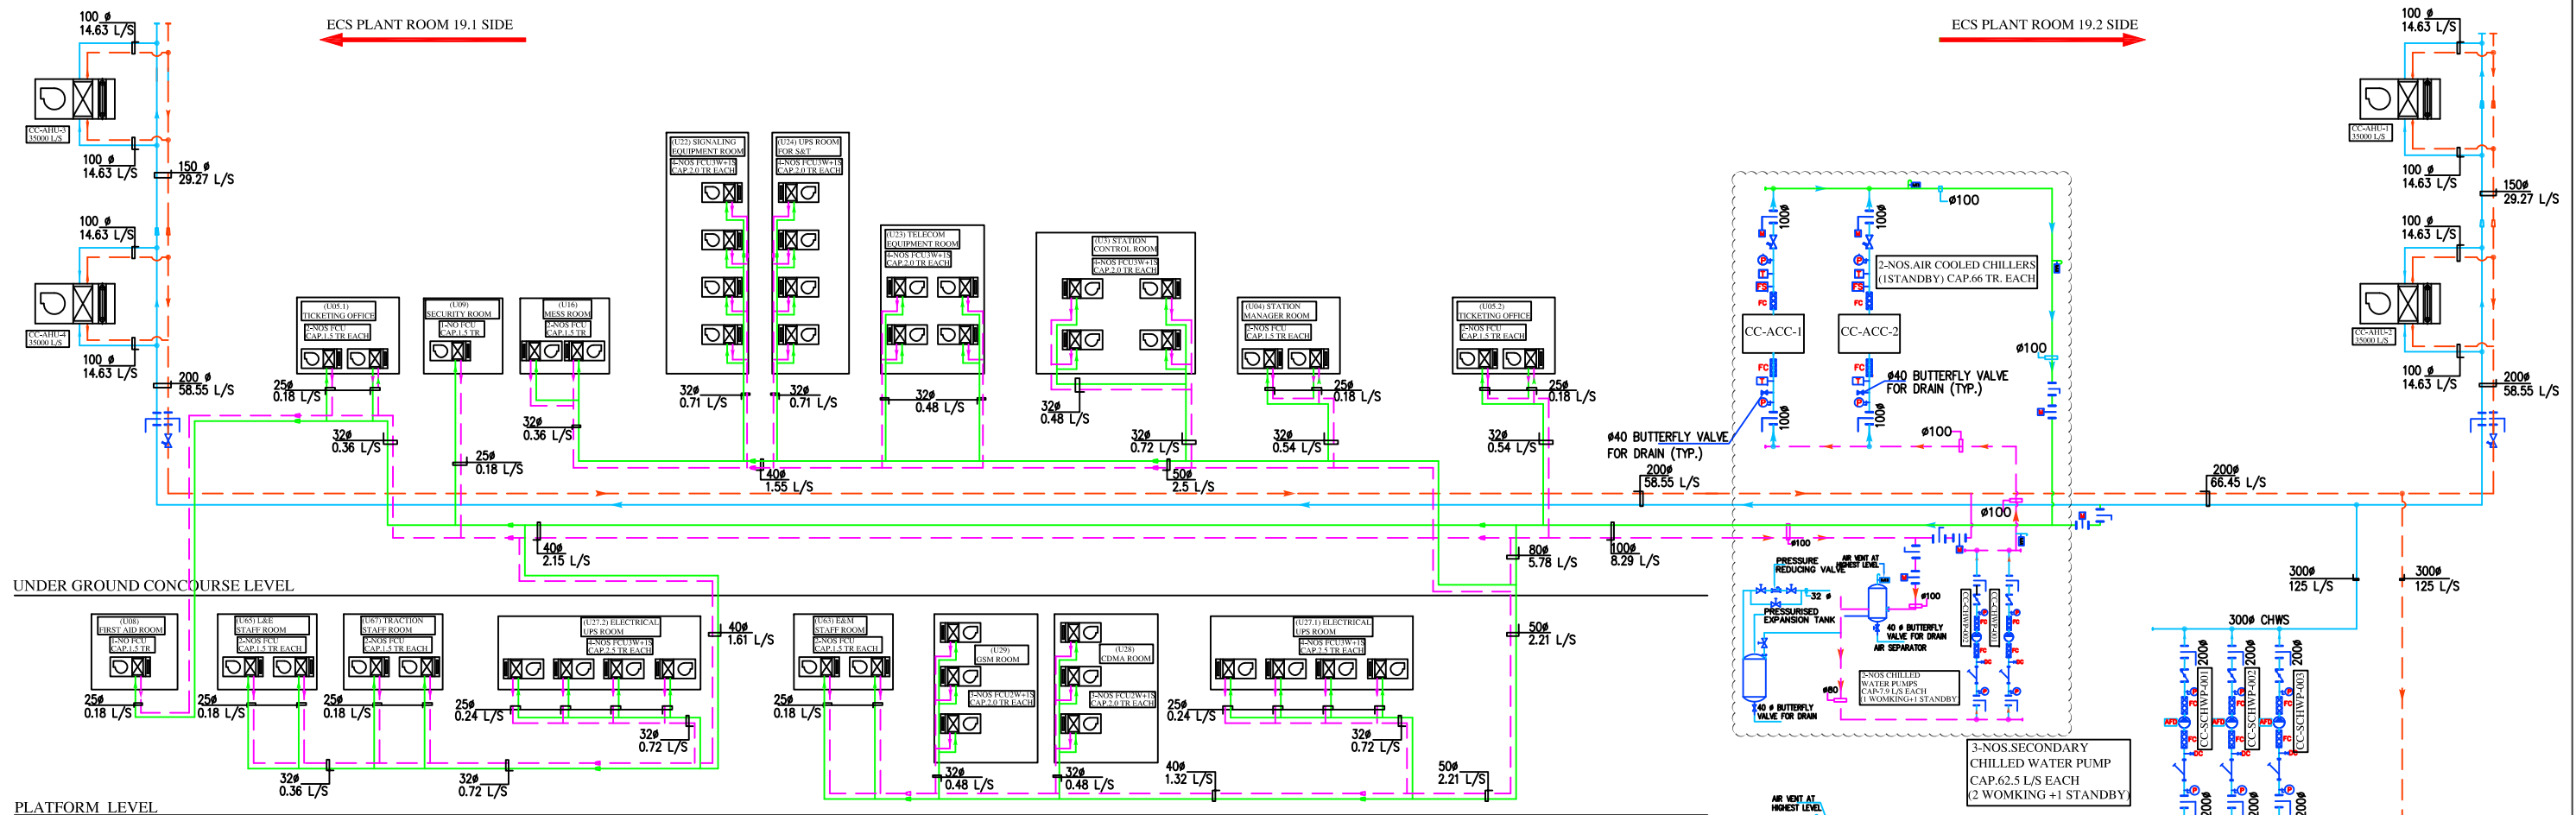


ABBREVIATIONS:-

CC CHOTI CHOUPER
AHU AIR HANDLING UNIT
SCHWP SECONDRY CHILLED WATER PUMP
PCHWP PRIMARY CHILLED WATER PUMP
CHWS CHILLED WATER SUPPLY
CHWR CHILLED WATER RETURN
NB NOMINAL BORE
FCU FAN COIL UNIT
CH CHILLER
DPS DIFFERENTIAL PRESSURE SWITCH


LEGEND

SYMBOL	DESCRIPTION	SYMBOL	DESCRIPTION
	Y-TYPE STRAINER		AUTOMATIC AIR VENT
	2-WAY MOTORISED VALVE		
	BALANCING VALVE		
	NON RETURN VALVE		
	BUTTERFLY VALVE		
	DRAIN COCK		
	FLEXIBLE CONNECTION		
	FLOOR DRAIN		
	PRESSURE GAUGE		
	THERMOMETER		
	FLOW SWITCH		
	GATE VALVE		
	REDUCER		
	BALL VALVE WITH STRAINER		
	BALL VALVE		
	FLOW SWITCH (FS)		
	ADJUSTABLE FREQUENCY DRIVE		
	DIFFERENTIAL PRESSURE SWITCH		
	AIR SEPARATOR		
	MOTORIZED BUTTERFLY VALVE		
	PRESSURE REDUCING VALVE		

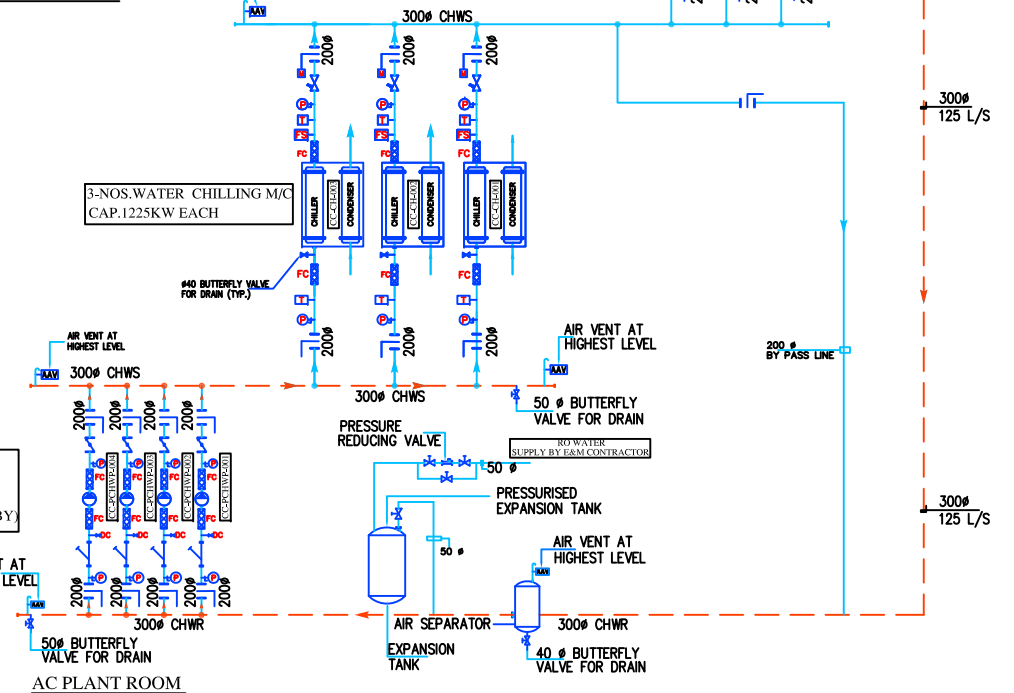

THIS DRAWING IS THE PROPERTY OF DELHI METRO RAIL CORPORATION LTD.	GENERAL NOTES 1. ALL DIMENSIONS ARE IN MILLIMETERS. 2. ALL DIMENSIONS ARE TO BE READ AND NOT MEASURED. 3. ANY DISCREPANCIES MUST BE BROUGHT TO THE NOTICE OF THE DMRC BEFORE EXECUTION OF THE WORK AT SITE. 4. THIS DRAWING MUST BE READ IN CONJUNCTION WITH ALL RELEVANT ARCHITECTURAL, STRUCTURAL, PLUMBING & FIRE FIGHTING, ELECTRICAL AND TRAFFIC MANAGEMENT DRAWINGS. 5. ALL DOOR/WINDOW CILL & LINTEL LEVELS ARE MEASURED FROM MAIN FLOOR FINISHED LEVELS.										REVISIONS <table><tr><td></td><td></td><td></td><td></td><td></td><td></td><td></td><td></td><td></td><td></td><td></td></tr><tr><td>REV</td><td>PARTICULARS</td><td>DRN.</td><td>CHD.</td><td>VER.</td><td>DATE</td><td>ISSUE DATE</td><td>REV. FOR CONSTRUCTION</td><td></td><td></td><td></td></tr></table>																					REV	PARTICULARS	DRN.	CHD.	VER.	DATE	ISSUE DATE	REV. FOR CONSTRUCTION				APPROVAL BY DMRC <table><tr><td>DMRC APPROVAL</td><td>MGR/ARCH</td><td>DY CA (UG)III</td><td>CA/ARCH</td></tr><tr><td>DY CSTE/TELECOM</td><td rowspan="2">CSTE-I</td><td>DY CE/DESIGN</td><td>CE/TECH</td></tr><tr><td>DY CSTE/AFC</td><td>ED/S&T</td><td>CSO</td></tr><tr><td>DY CSTE/SIGNALLING</td><td>CSTE-III</td><td>GM/O</td><td>GMM</td></tr><tr><td>DY CE/PLANNING</td><td>DY CEE/E&M</td><td>DY CEE/ECS</td><td>ED/ELEC-II</td></tr><tr><td>DY CEE/(E)UG-TR</td><td>CGM(E) UG-TR</td><td>PM</td><td>CPM</td></tr></table>				DMRC APPROVAL	MGR/ARCH	DY CA (UG)III	CA/ARCH	DY CSTE/TELECOM	CSTE-I	DY CE/DESIGN	CE/TECH	DY CSTE/AFC	ED/S&T	CSO	DY CSTE/SIGNALLING	CSTE-III	GM/O	GMM	DY CE/PLANNING	DY CEE/E&M	DY CEE/ECS	ED/ELEC-II	DY CEE/(E)UG-TR	CGM(E) UG-TR	PM	CPM	Certified that this document has been designed and checked in accordance with DDC Quality Assurance Plan. Authorised Signatory for DDC. JP/EW/1B/DDC01 Project Manager <table><tr><td>Architecture Design In-charge/ Coordinator</td><td>Structure Design In-charge/ Coordinator</td><td>E&M Design In-charge/ Coordinator</td></tr></table>			Architecture Design In-charge/ Coordinator	Structure Design In-charge/ Coordinator	E&M Design In-charge/ Coordinator	DETAIL DESIGN CONSULTANT (DDC) FOR CIVIL, ARCHITECTURAL & BUILDING WORKS OF TWO UNDERGROUND STATION (CHOTI CHOUPAR & BADI CHOUPAR), SHAFT AND TUNNELS OF PHASE 1B OF JAIPUR METRO ayesa Engineering, Information, Imagination. 56, Indo-Asia House, Institutional Area, sector-44 Gurgaon - 122002 (Haryana)			DELHI METRO RAIL CORPORATION LTD. Metro Bhawan , Fire Brigade Lane, Barakhamba Road, New Delhi-110001 PHASE 1B JAIPUR METRO PROJECT STATION: CHOTI CHOUPAR DRAWING TITLE: CHW WATER PIPING SCHEMATIC DRAWN BY: ADIL CHECKED BY: NITIN VERIFIED BY: L.R.S DATE: 31-03-2015 REV: R0 GRAPHICAL SCALE: N.T.S STATUS: FOR TENDER DRAWING NUMBER: JP-TD-ECS-10CC-1601 SHEET NO. 1 OF 1 SHEET SIZE UNE A1 ORDER N° P36-0017 This drawing must not be either loaned, copied or otherwise reproduced in whole or in part or used for any purpose without the prior written permission of DMRC. JP/EW/1B/DDC01 ECS		
	REV	PARTICULARS	DRN.	CHD.	VER.	DATE	ISSUE DATE	REV. FOR CONSTRUCTION																																																																									
	DMRC APPROVAL	MGR/ARCH	DY CA (UG)III	CA/ARCH																																																																													
	DY CSTE/TELECOM	CSTE-I	DY CE/DESIGN	CE/TECH																																																																													
	DY CSTE/AFC		ED/S&T	CSO																																																																													
	DY CSTE/SIGNALLING	CSTE-III	GM/O	GMM																																																																													
	DY CE/PLANNING	DY CEE/E&M	DY CEE/ECS	ED/ELEC-II																																																																													
	DY CEE/(E)UG-TR	CGM(E) UG-TR	PM	CPM																																																																													
	Architecture Design In-charge/ Coordinator	Structure Design In-charge/ Coordinator	E&M Design In-charge/ Coordinator																																																																														

Legend

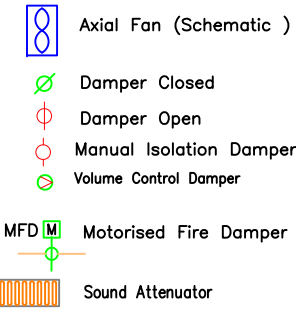


Abbreviations


AHU	Air Handling Unit	MOD	Motor Operated Damper
DC	Damper close	OTE	Over Track Exhaust
DO	Damper Open	R.A	Return Air
DB	Distribution Board	S.A	SUPPLY Air
FAF	Fresh Air Fan	T/A	To Above
F/A	From Above	T/B	To Below
F/B	From Below	TEA	Track Way Exhaust Attenuator
FCU	Fan Coil Unit	TEF	Track Way Exhaust Fan
FD	Fire Damper	UPE	Under Platform Exhaust
FMD	Manual Damper (Fire rated)	VCD	Volume Control Damper (Non fire rated)
MD	Manual Damper	VCF	Volume Control Damper (Fire rated)
MFD	Motorised Fire Damper	VEF	Ventilation Exhaust Fan
SEF	Smoke Extraction Fan	VSF	Ventilation SUPPLY Fan
SAP	SUPPLY Air Plenum	OBD	OCCosed Blade Dampere
RAP	Return Air Plenum		
BPD	Back Plate Damper		

EQUIPMENT SCHEDULE

S.NO	EQUIPMENT	CAPACITY	QTY	REMACCS
1	AHU (PLATFORM+CONCOURSE)	35.0-m ³ /s (EACH)	2-NOS.	
2	TRACK WAY EXHAUST FAN	31.5 m ³ /s (EACH)	2-NOS	
3	FRESH AIR FAN	7.0 m ³ /s	1-NO.	
4	SMOKE EXHAUST FAN	11.76 m ³ /s	2-NOS.	(1W+1S BY)

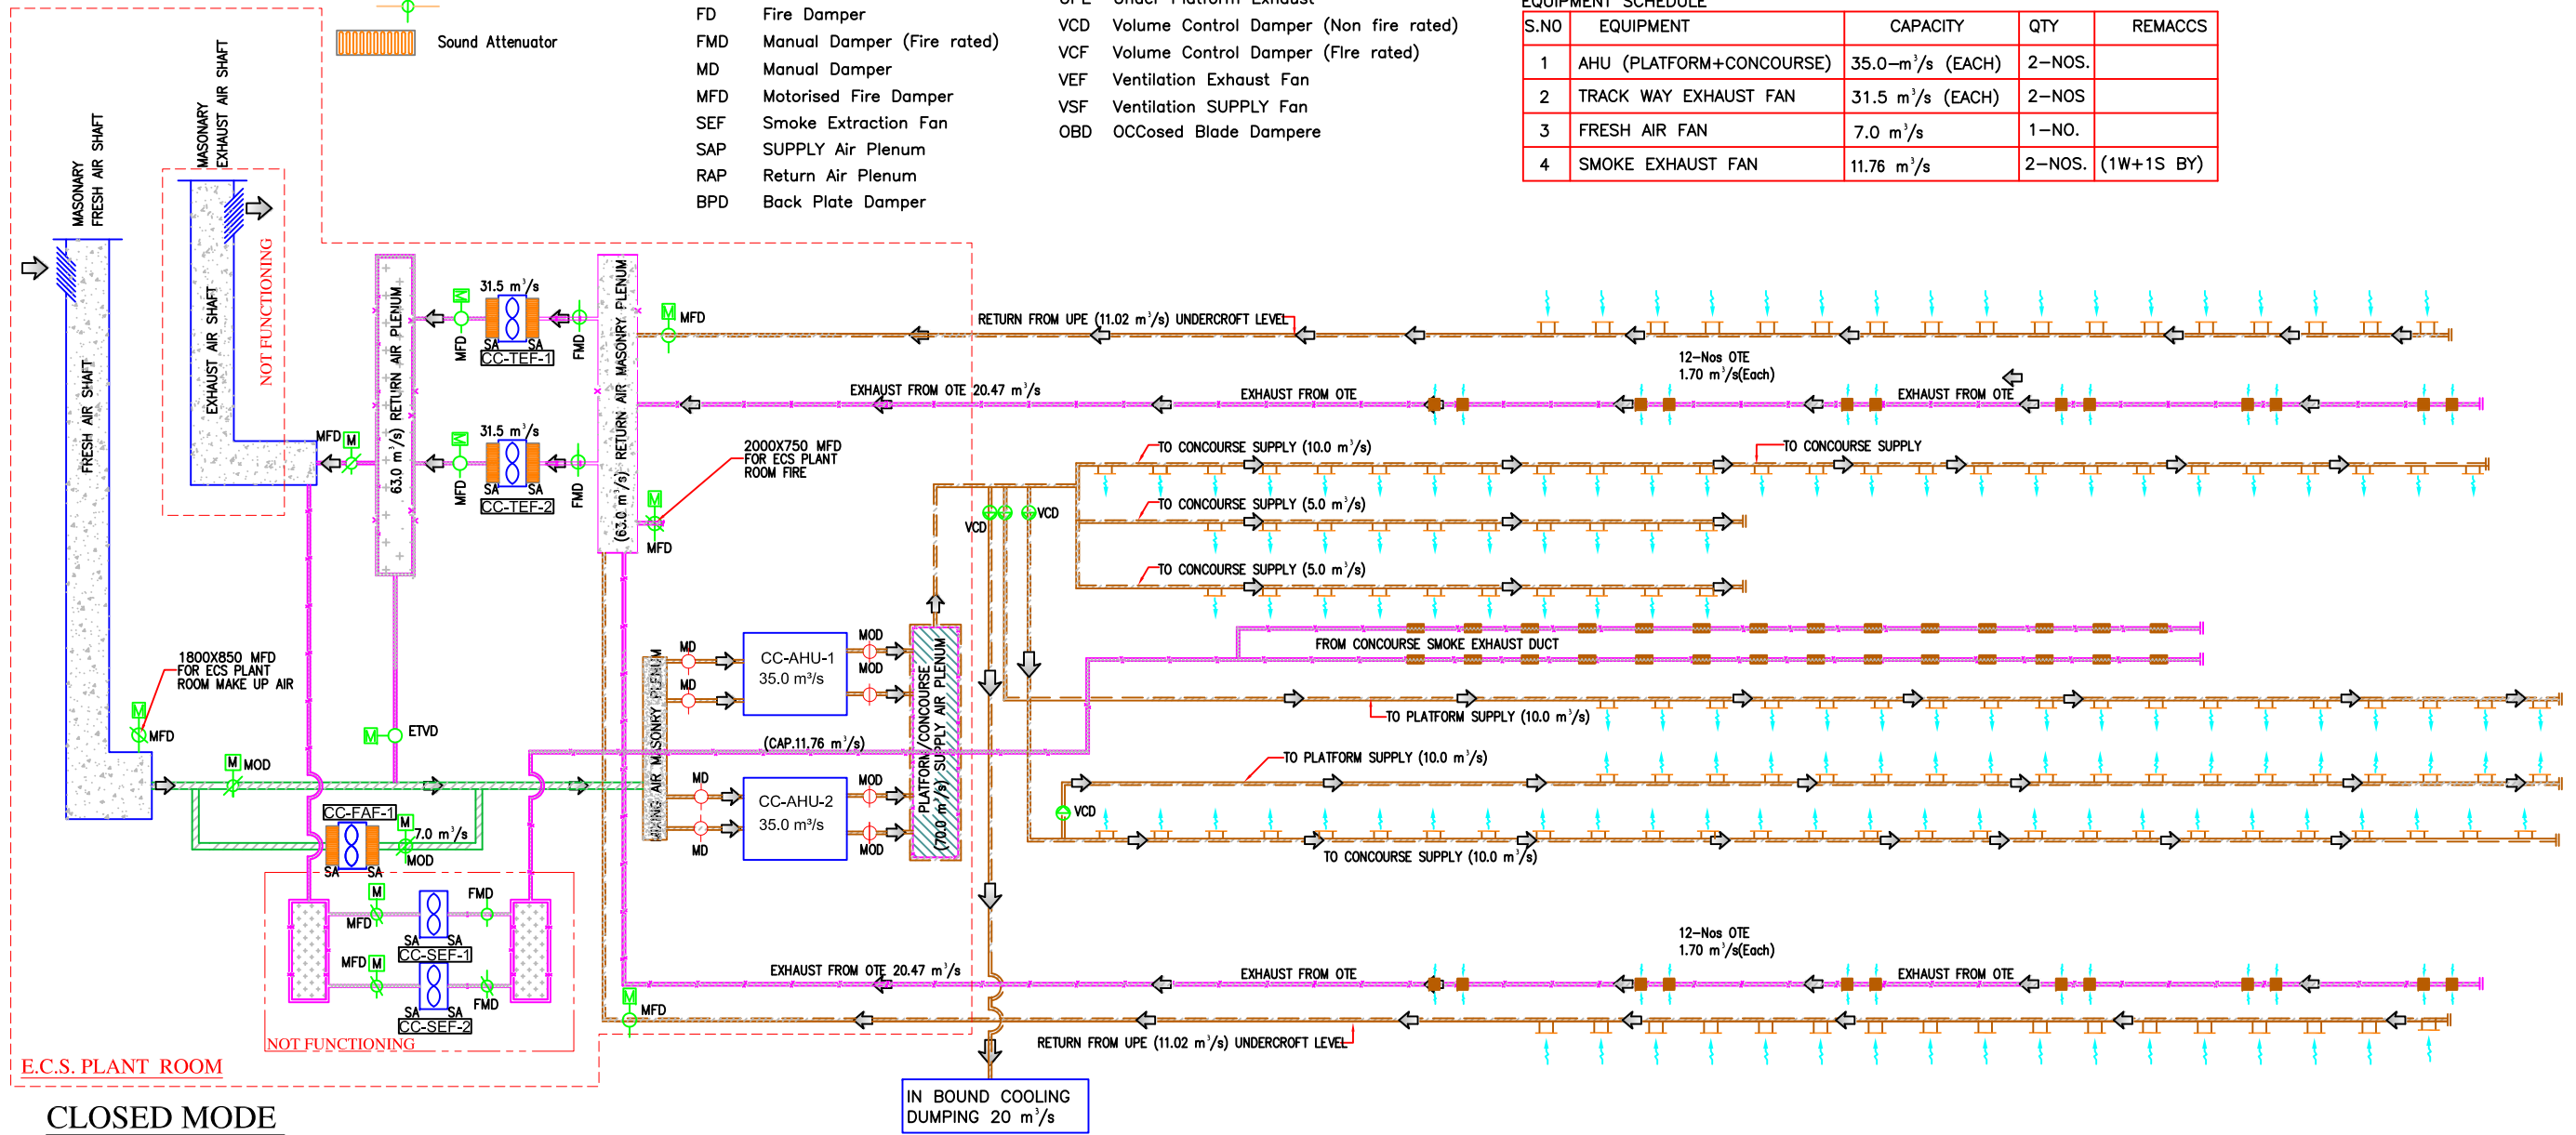

THIS DRAWING IS THE PROPERTY OF DELHI METRO RAIL CORPORATION LTD.	GENERAL NOTES: 1. ALL DIMENSIONS ARE IN MILLIMETERS. 2. ALL DIMENSIONS ARE TO BE READ AND NOT MEASURED. 3. ANY DISCREPANCIES MUST BE BROUGHT TO THE NOTICE OF THE DMRC BEFORE EXECUTION OF THE WORK AT SITE. 4. THIS DRAWING MUST BE READ IN CONJUNCTION WITH ALL RELEVANT ARCHITECTURAL, STRUCTURAL, PLUMBING & FIRE FIGHTING, ELECTRICAL AND TRAFFIC MANAGEMENT DRAWINGS. 5. ALL DOOR/WINDOW CILL & LINTEL LEVELS ARE MEASURED FROM MAIN FLOOR FINISHED LEVELS.										REVISIONS							APPROVAL BY DMRC				Certified that this document has been designed and checked in accordance with DDC Quality Assurance Plan.			Authorised Signatory for DDC. JP/EW/1B/DDC01 Project Manager			DELHI METRO RAIL CORPORATION LTD. Metro Bhawan , Fire Brlgade Lane, Barakhamba Road, New Delhi-110001	
											DMRC APPROVAL	MGR/ARCH	DY CA (UG)III	CA/ARCH	Architecture Design In-charge/ Coordinator	Structure Design In-charge/ Coordinator	E&M Design In-charge/ Coordinator	PHASE 1B JAIPUR METRO PROJECT											
											DY CSTE/TELECOM	CSTE-I	DY CE/DESIGN	CE/TECH	DETAIL DESIGN CONSULTANT (DDC) FOR CIVIL, ARCHITECTURAL & BUILDING WORKS OF TWO UNDERGROUND STATION (CHOTI CHOUPAR & BADI CHOUPAR), SHAFT AND TUNNELS OF PHASE 1B OF JAIPUR METRO ayesa Engineering, Information, Imagination. 56, Indo-Asia House, Institutional Area, sector-44 Gurgaon - 122002 (Haryana)				STATION: CHOTI CHOUPAR										
										DY CSTE/AFC	ED/S&T		CSO	DRAWING TITLE: AIR FLOW SCHEMATIC-ECS PLANT ROOM 19.1															
										DY CSTE/SIGNALLING	CSTE-II	GM/O	GMM	DRAWN BY: ADIL					CHECKED BY: NITIN	VERIFIED BY: L.R.S	JP/EW/1B/DDC01 ECS								
										DY CE/PLANNING	DY CEE/E&M	DY CEE/ECS	ED/ELEC-II	DATE: 31-03-2015					REV: R0	GRAPHICAL SCALE: N.T.S		STATUS: FOR TENDER							
										DY CEE/(E)UG-TR	CGM(E) UG-TR	PM	CPM	DRAWING NUMBER: JP-TD-ECS-10CC-1603					SHEET NO. 1 OF 1	SHEET SIZE UNE A1		ORDER N° P36-0017							
	REV	PARTICULARS	DRN.	CHD.	VER.	DATE	ISSUE DATE	REV. FOR CONSTRUCTION																					

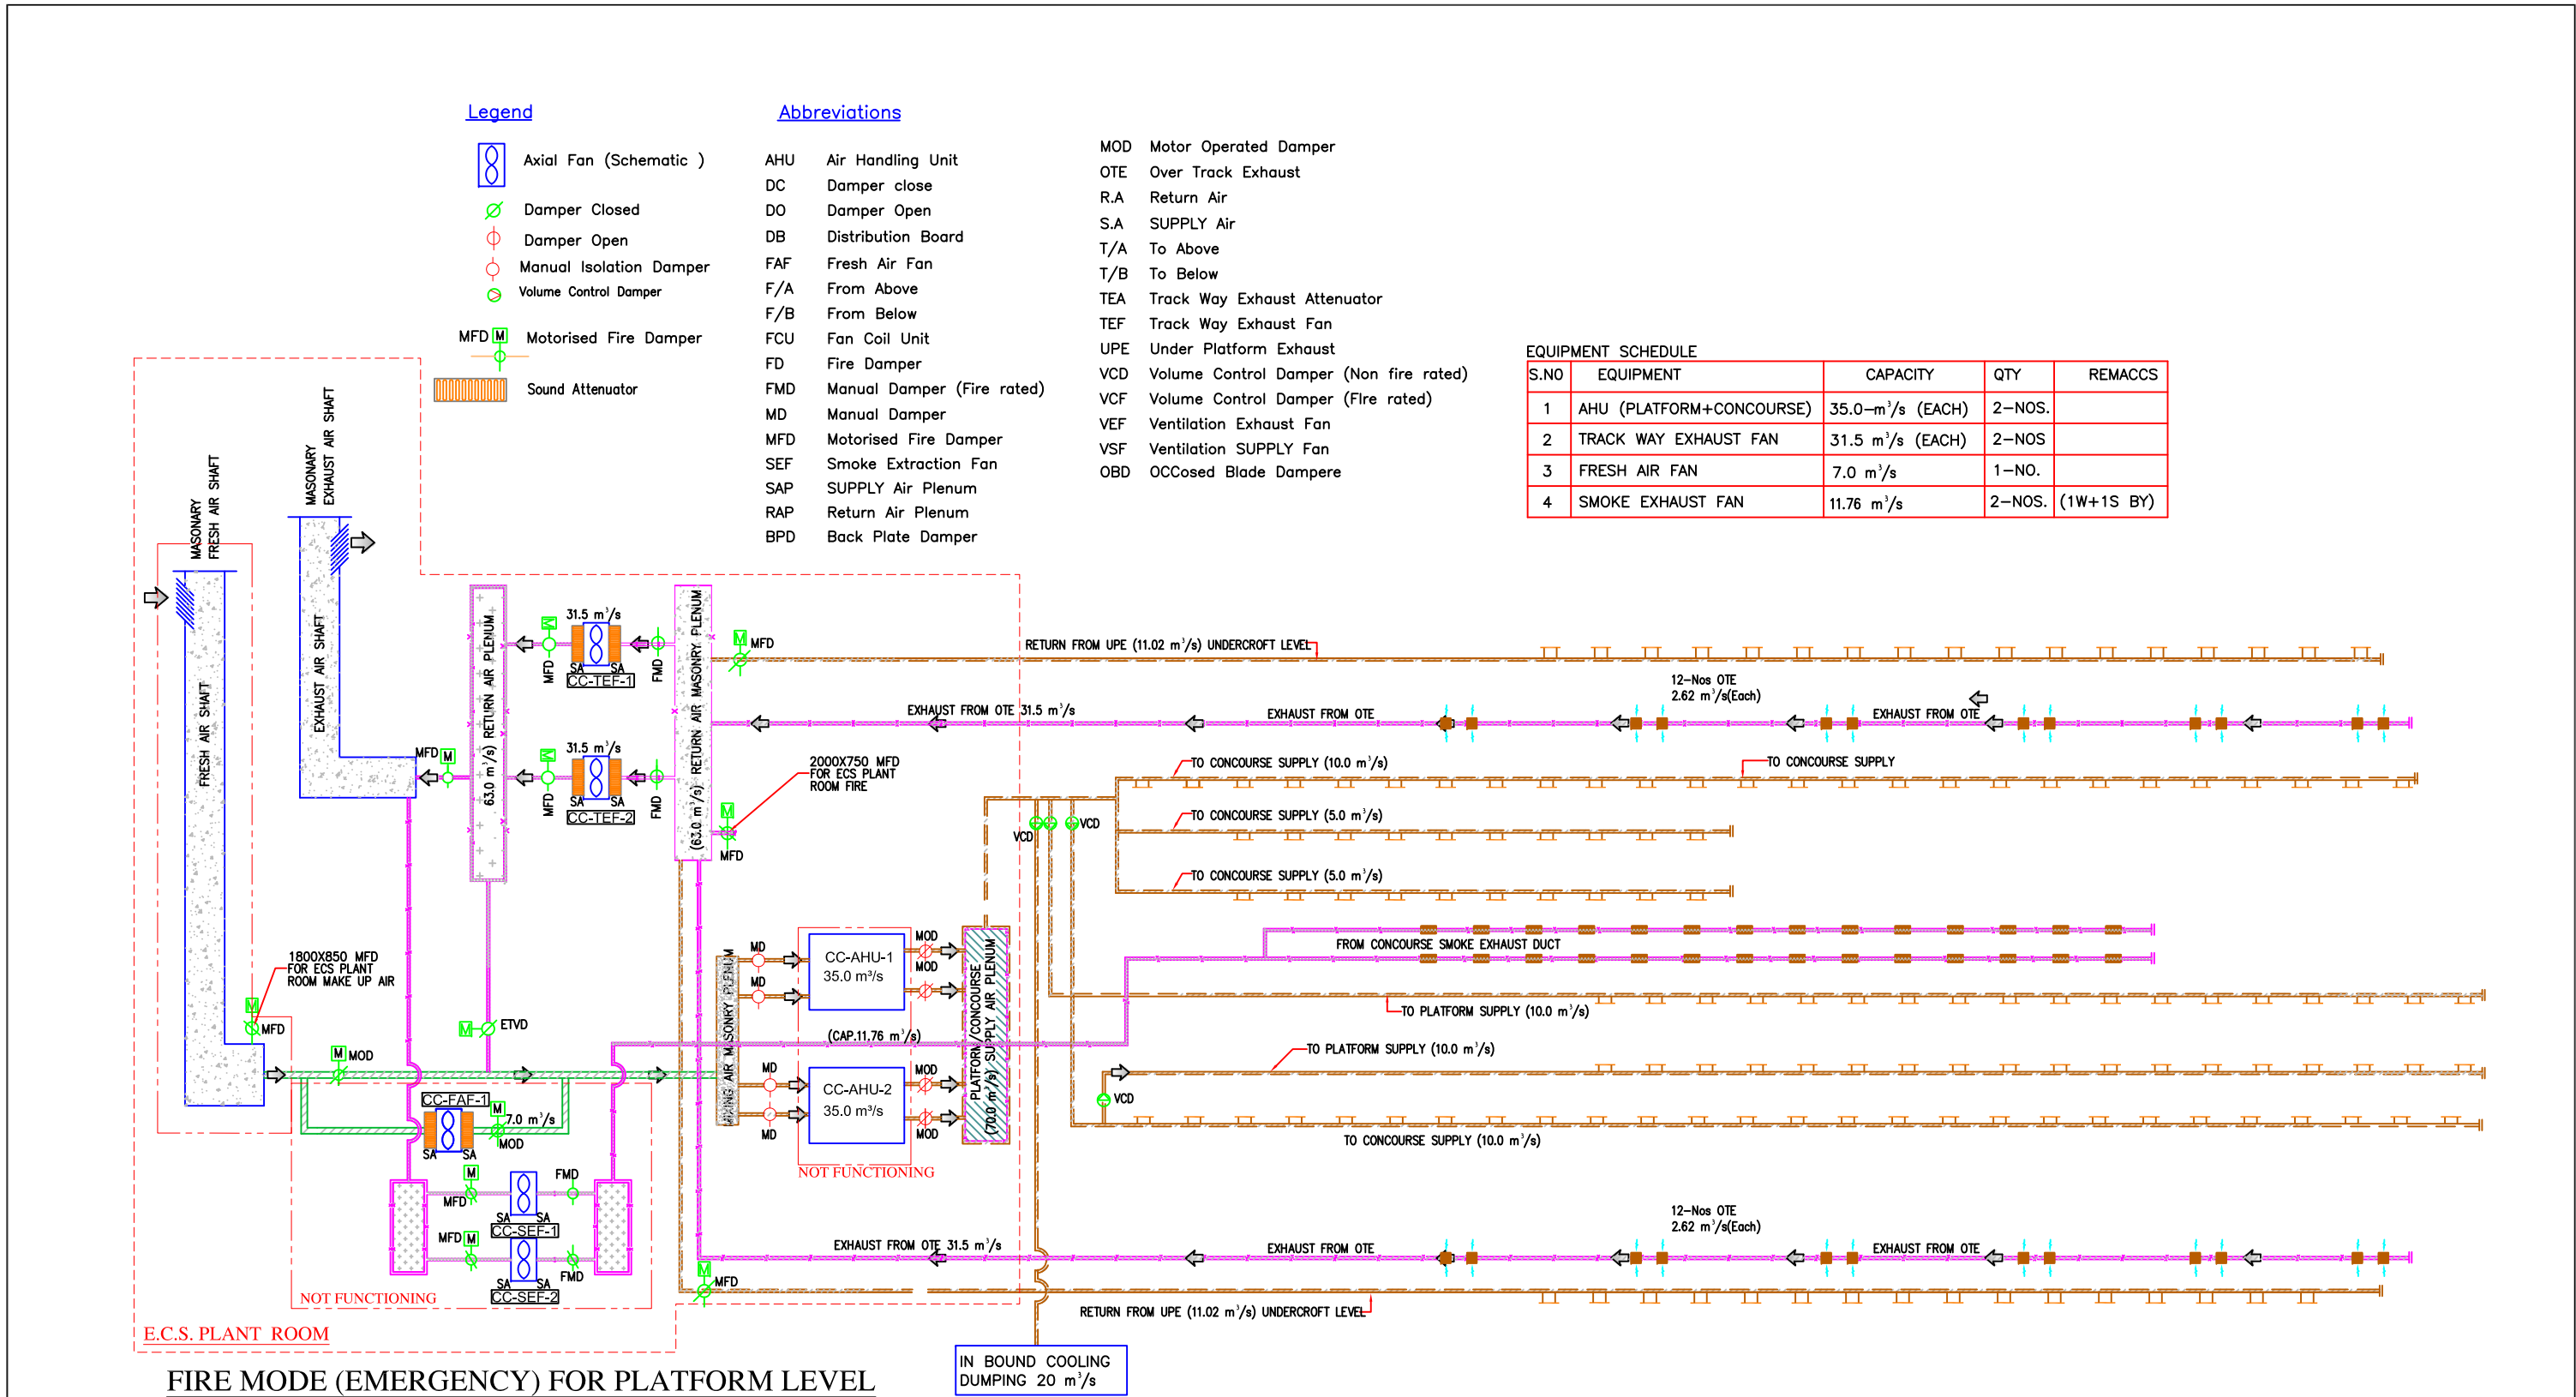

THIS DRAWING IS THE PROPERTY OF DELHI METRO RAIL CORPORATION LTD.	<u>GENERAL NOTES:</u> 1. ALL DIMENSIONS ARE IN MILLIMETERS. 2. ALL DIMENSIONS ARE TO BE READ AND NOT MEASURED. 3. ANY DISCREPANCIES MUST BE BROUGHT TO THE NOTICE OF THE DMRC BEFORE EXECUTION OF THE WORK AT SITE. 4. THIS DRAWING MUST BE READ IN CONJUNCTION WITH ALL RELEVANT ARCHITECTURAL, STRUCTURAL, PLUMBING & FIRE FIGHTING, ELECTRICAL AND TRAFFIC MANAGEMENT DRAWINGS. 5. ALL DOOR/WINDOW CILL & LINTEL LEVELS ARE MEASURED FROM MAIN FLOOR FINISHED LEVELS.		REVISIONS							APPROVAL BY DMRC				Certified that this document has been designed and checked in accordance with DDC Quality Assurance Plan.			Authorised Signatory for DDC. JP/EW/1B/DDC01 Project Manager			 DELHI METRO RAIL CORPORATION LTD. Metro Bhawan , Fire Brigade Lane, Barakhamba Road, New Delhi-110001	
	REFERENCE DRAWINGS										DMRC APPROVAL	MSR/ARCH	DY CA (UG)III	CA/ARCH	Architecture Design In-charge/ Coordinator	Structure Design In-charge/ Coordinator	E&M Design In-charge/ Coordinator	DETAIL DESIGN CONSULTANT (DDC) FOR CIVIL, ARCHITECTURAL & BUILDING WORKS OF TWO UNDERGROUND STATION (CHOTI CHOUPAR & BADI CHOUPAR), SHAFT AND TUNNELS OF PHASE 1B OF JAIPUR METRO  Engineering, Information, Imagination. 56, Indo-Asia House, Institutional Area, sector-44 Gurgaon - 122002 (Haryana)			
	Drg. No.										Description		DY CSTE/TELECOM	CSTE-I	DY CE/DESIGN	CE/TECH					
											DY CSTE/AFC	ED/IS&T	CSO								
											DY CSTE/SIGNALLING	CSTE-III	GM/O	GM/M							
											DY CE/PLANNING	DY CEE/E&M	DY CEE/ECS	ED/ELEC-II							
											DY CEE/(E)UG-TR	CGM(E) UG-TR	PM	CPM							
											REV	PARTICULARS	DRN.	CHD.	VER.	DATE	ISSUE DATE			REV. FOR CONSTRUCTION	

| DRAWING TITLE: AIR FLOW SCHEMATIC-ECS PLANT ROOM 19.1 | | DRAWN BY: ADIL | | CHECKED BY: NITIN | | VERIFIED BY: L.R.S | | DATE: 31-03-2015 | | REV: R0 | | GRAPHICAL SCALE: N.T.S | | STATUS: FOR TENDER | | DRAWING NUMBER: JP-TD-ECS-10CC-1604 | | SHEET NO. 1 OF 1 | | SHEET SIZE UNE A1 | | ORDER N° P36-0017 | | JP/EW/1B/DDC01 | | ECS | |
| This drawing must not be either loaned, copied or otherwise reproduced in whole or in part or used for any purpose without the prior written permission of DMRC. |

Abbreviations


AHU	Air Handling Unit	MOD	Motor Operated Damper
DC	Damper close	OTE	Over Track Exhaust
DO	Damper Open	R.A	Return Air
DB	Distribution Board	S.A	SUPPLY Air
FAF	Fresh Air Fan	T/A	To Above
F/A	From Above	T/B	To Below
F/B	From Below	TEA	Track Way Exhaust Attenuator
FCU	Fan Coil Unit	TEF	Track Way Exhaust Fan
FD	Fire Damper	UPE	Under Platform Exhaust
FMD	Manual Damper (Fire rated)	VCD	Volume Control Damper (Non fire rated)
MD	Manual Damper	VCF	Volume Control Damper (Fire rated)
MFD	Motorised Fire Damper	VEF	Ventilation Exhaust Fan
SEF	Smoke Extraction Fan	VSF	Ventilation SUPPLY Fan
SAP	SUPPLY Air Plenum	OBD	OCClosed Blade Dampere
RAP	Return Air Plenum		
BPD	Back Plate Damper		

Legend

	Axial Fan (Schematic)
	Damper Closed
	Damper Open
	Manual Isolation Damper
	Volume Control Damper
	Motorised Fire Damper
	Sound Attenuator

EQUIPMENT SCHEDULE

S.NO	EQUIPMENT	CAPACITY	QTY	REMACCS
1	AHU (PLATFORM+CONCOURSE)	35.0-m ³ /s (EACH)	2-NOS.	
2	TRACK WAY EXHAUST FAN	31.5 m ³ /s (EACH)	2-NOS.	
3	FRESH AIR FAN	7.0 m ³ /s	1-NO.	
4	SMOKE EXHAUST FAN	11.76 m ³ /s	2-NOS. (1W+1S BY)	

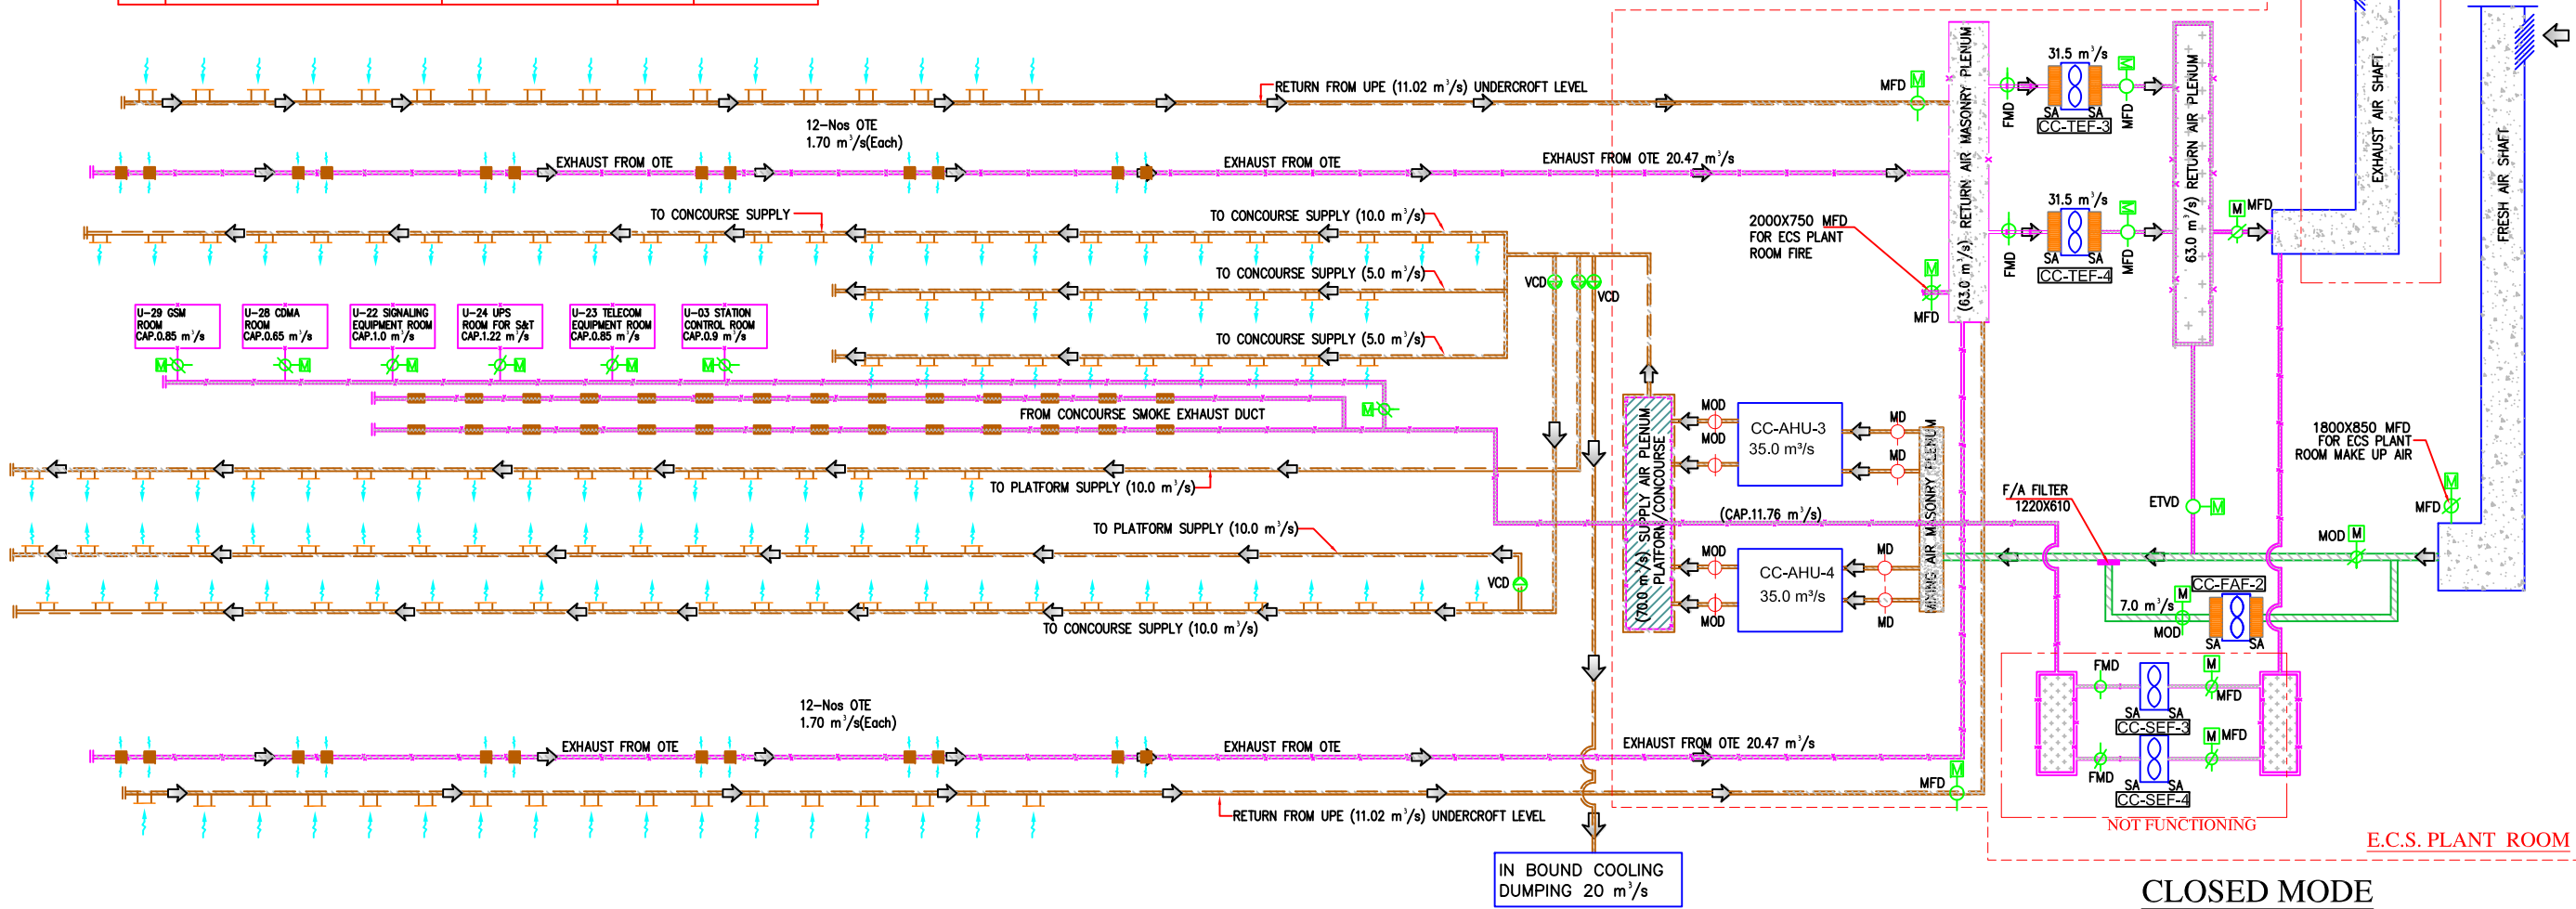

THIS DRAWING IS THE PROPERTY OF DELHI METRO RAIL CORPORATION LTD.	GENERAL NOTES: 1. ALL DIMENSIONS ARE IN MILLIMETERS. 2. ALL DIMENSIONS ARE TO BE READ AND NOT MEASURED. 3. ANY DISCREPANCIES MUST BE BROUGHT TO THE NOTICE OF THE DMRC BEFORE EXECUTION OF THE WORK AT SITE. 4. THIS DRAWING MUST BE READ IN CONJUNCTION WITH ALL RELEVANT ARCHITECTURAL, STRUCTURAL, PLUMBING & FIRE FIGHTING, ELECTRICAL AND TRAFFIC MANAGEMENT DRAWINGS. 5. ALL DOOR/WINDOW CILL & LINTEL LEVELS ARE MEASURED FROM MAIN FLOOR FINISHED LEVELS.										REVISIONS							APPROVAL BY DMRC				Certified that this document has been designed and checked in accordance with DDC Quality Assurance Plan.			Authorised Signatory for DDC. JP/EW/1B/DDC01 Project Manager			 DELHI METRO RAIL CORPORATION LTD. Metro Bhawan , Fire Brigade Lane, Barakhamba Road, New Delhi-110001	
																		PHASE 1B JAIPUR METRO PROJECT											
																		STATION: CHOTI CHOUPAR											
																		DRAWING TITLE: AIR FLOW SCHEMATIC-ECS PLANT ROOM 19.2											
	DRAWN BY:		ADIL			CHECKED BY:			NITIN			VERIFIED BY:			L.R.S			JP/EW/1B/DDC01 ECS											
	DATE:		31-03-2015			REV:		R0		GRAPHICAL SCALE:			N.T.S			STATUS:				FOR TENDER									
	DRAWING NUMBER:					JP-TD-ECS-10CC-1606					SHEET NO.		1 OF 1		SHEET SIZE		UNE A1			ORDER N°			P36-0017						
	REV		PARTICULARS			DRN.		CHD.		VER.		DATE		ISSUE DATE		REV. FOR CONSTRUCTION		DMRC APPROVAL		MGR/ARCH		DY CA (UG)-III		CA/ARCH		DETAIL DESIGN CONSULTANT (DDC) FOR CIVIL, ARCHITECTURAL & BUILDING WORKS OF TWO UNDERGROUND STATION (CHOTI CHOUPAR & BADI CHOUPAR), SHAFT AND TUNNELS OF PHASE 1B OF JAIPUR METRO  ayesa Engineering, Information, Imagination. 56, Indo-Asia House, Institutional Area, sector-44 Gurgaon - 122002 (Haryana)			
																		DY CSTE/TELECOM		CSTE-I		DY CE/DESIGN		CE/TECH					
																	DY CSTE/AFC		ED/S&T			CSO							
																	DY CSTE/SIGNALLING		CSTE-III		GM/O		GMM						
																	DY CE/PLANNING		DY CEE/E&M		DY CEE/ECS		ED/ELEC-II						
																	DY CEE/(E)UG-TR		CGM(E) UG-TR		PM		CPM						

Abbreviations


AHU	Air Handling Unit	MOD	Motor Operated Damper
DC	Damper close	OTE	Over Track Exhaust
DO	Damper Open	R.A	Return Air
DB	Distribution Board	S.A	SUPPLY Air
FAF	Fresh Air Fan	T/A	To Above
F/A	From Above	T/B	To Below
F/B	From Below	TEA	Track Way Exhaust Attenuator
FCU	Fan Coil Unit	TEF	Track Way Exhaust Fan
FD	Fire Damper	UPE	Under Platform Exhaust
FMD	Manual Damper (Fire rated)	VCD	Volume Control Damper (Non fire rated)
MD	Manual Damper	VCF	Volume Control Damper (Fire rated)
MFD	Motorised Fire Damper	VEF	Ventilation Exhaust Fan
SEF	Smoke Extraction Fan	VSF	Ventilation SUPPLY Fan
SAP	SUPPLY Air Plenum	OBD	OCClosed Blade Dampere
RAP	Return Air Plenum		
BPD	Back Plate Damper		

Legend

	Axial Fan (Schematic)
	Damper Closed
	Damper Open
	Manual Isolation Damper
	Volume Control Damper
	Motorised Fire Damper
	Sound Attenuator

EQUIPMENT SCHEDULE

S.NO	EQUIPMENT	CAPACITY	QTY	REMACCS
1	AHU (PLATFORM+CONCOURSE)	35.0-m ³ /s (EACH)	2-NOS.	
2	TRACK WAY EXHAUST FAN	31.5 m ³ /s (EACH)	2-NOS	
3	FRESH AIR FAN	7.0 m ³ /s	1-NO.	
4	SMOKE EXHAUST FAN	11.76 m ³ /s	2-NOS. (1W+1S BY)	

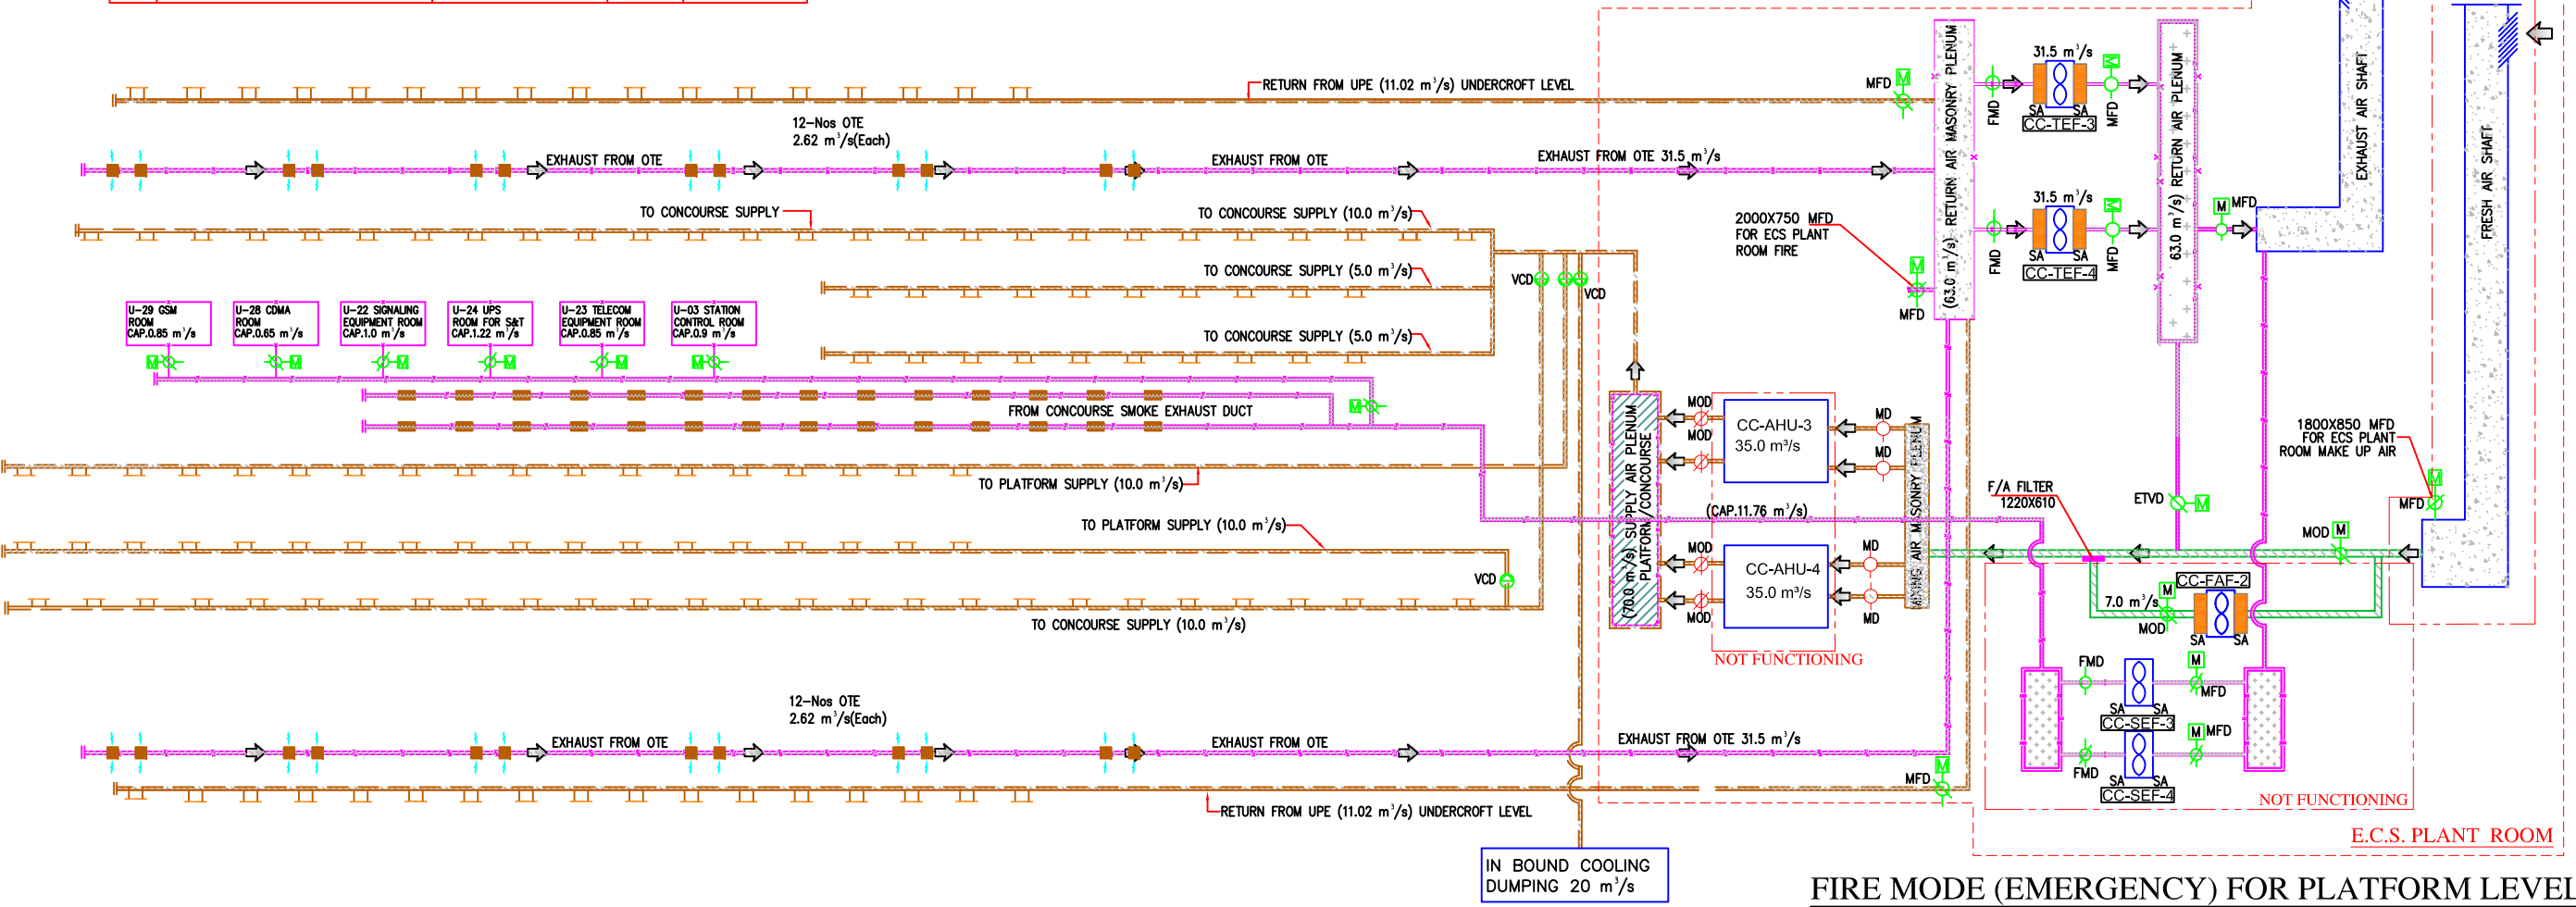

FIRE MODE (EMERGENCY) FOR PLATFORM LEVEL

THIS DRAWING IS THE PROPERTY OF DELHI METRO RAIL CORPORATION LTD.

GENERAL NOTES:
1. ALL DIMENSIONS ARE IN MILLIMETERS.
2. ALL DIMENSIONS ARE TO BE READ AND NOT MEASURED.
3. ANY DISCREPANCIES MUST BE BROUGHT TO THE NOTICE OF THE DMRC BEFORE EXECUTION OF THE WORK AT SITE.
4. THIS DRAWING MUST BE READ IN CONJUNCTION WITH ALL RELEVANT ARCHITECTURAL, STRUCTURAL, PLUMBING & FIRE FIGHTING, ELECTRICAL AND TRAFFIC MANAGEMENT DRAWINGS.
5. ALL DOOR/WINDOW CILL & LINTEL LEVELS ARE MEASURED FROM MAIN FLOOR FINISHED LEVELS.

REFERENCE DRAWINGS	
Dwg. No.	Description

REVISIONS							
REV	PARTICULARS	DRN.	CHD.	VER.	DATE	ISSUE DATE	REV. FOR CONSTRUCTION

APPROVAL BY DMRC			
DMRC APPROVAL	MGR/ARCH	DY CA (UG)-III	CA/ARCH
DY CSTE/TELECOM	CSTE-I	DY CE/DESIGN	CE/TECH
DY CSTE/IAFC		ED/S&T	CSO
DY CSTE/SIGNALLING	CSTE-III	GM/O	GMM
DY CE/PLANNING	DY CEE/E&M	DY CEE/ECS	ED/ELEC-II
DY CEE/(E)UG-TR	CGM(E) UG-TR	PM	CPM

Certified that this document has been designed and checked in accordance with DDC Quality Assurance Plan.

Architecture
Design In-charge/ Coordinator

Structure
Design In-charge/ Coordinator

E&M
Design In-charge/ Coordinator

Authorised Signatory for DDC.
JP/EW/1B/DDC01 Project Manager

DETAIL DESIGN CONSULTANT (DDC) FOR CIVIL, ARCHITECTURAL & BUILDING WORKS OF TWO UNDERGROUND STATION (CHOTI CHOUPAR & BADI CHOUPAR), SHAFT AND TUNNELS OF PHASE 1B OF JAIPUR METRO

ayesa Engineering, Information, Imagination.
56, Indo-Asia House, Institutional Area, sector-44 Gurgaon - 122002 (Haryana)

DELHI METRO RAIL CORPORATION LTD.
Metro Bhawan , Fire Brigade Lane, Barakhamba Road, New Delhi-110001

PHASE 1B JAIPUR METRO PROJECT

STATION: CHOTI CHOUPAR

DRAWING TITLE: AIR FLOW SCHEMATIC-ECS PLANT ROOM 19.2

DRAWN BY: ADIL		CHECKED BY: NITIN	VERIFIED BY: L.R.S
DATE: 31-03-2015	REV: R0	GRAPHICAL SCALE: N.T.S	STATUS: FOR TENDER
DRAWING NUMBER: JP-TD-ECS-10CC-1607		SHEET NO. 1 OF 1	SHEET SIZE UNE A1
		ORDER N° P36-0017	

This drawing must not be either loaned, copied or otherwise reproduced in whole or in part or used for any purpose without the prior written permission of DMRC.

JP/EW/1B/DDC01

ECS

Abbreviations


AHU	Air Handling Unit	MOD	Motor Operated Damper
DC	Damper close	OTE	Over Track Exhaust
DO	Damper Open	R.A	Return Air
DB	Distribution Board	S.A	SUPPLY Air
FAF	Fresh Air Fan	T/A	To Above
F/A	From Above	T/B	To Below
F/B	From Below	TEA	Track Way Exhaust Attenuator
FCU	Fan Coil Unit	TEF	Track Way Exhaust Fan
FD	Fire Damper	UPE	Under Platform Exhaust
FMD	Manual Damper (Fire rated)	VCD	Volume Control Damper (Non fire rated)
MD	Manual Damper	VCF	Volume Control Damper (Fire rated)
MFD	Motorised Fire Damper	VEF	Ventilation Exhaust Fan
SEF	Smoke Extraction Fan	VSF	Ventilation SUPPLY Fan
SAP	SUPPLY Air Plenum	OBD	OCClosed Blade Dampere
RAP	Return Air Plenum		
BPD	Back Plate Damper		

Legend

	Axial Fan (Schematic)
	Damper Closed
	Damper Open
	Manual Isolation Damper
	Volume Control Damper
	Motorised Fire Damper
	Sound Attenuator

EQUIPMENT SCHEDULE

S.NO	EQUIPMENT	CAPACITY	QTY	REMACCS
1	AHU (PLATFORM+CONCOURSE)	35.0-m ³ /s (EACH)	2-NOS.	
2	TRACK WAY EXHAUST FAN	31.5 m ³ /s (EACH)	2-NOS	
3	FRESH AIR FAN	7.0 m ³ /s	1-NO.	
4	SMOKE EXHAUST FAN	11.76 m ³ /s	2-NOS. (1W+1S BY)	

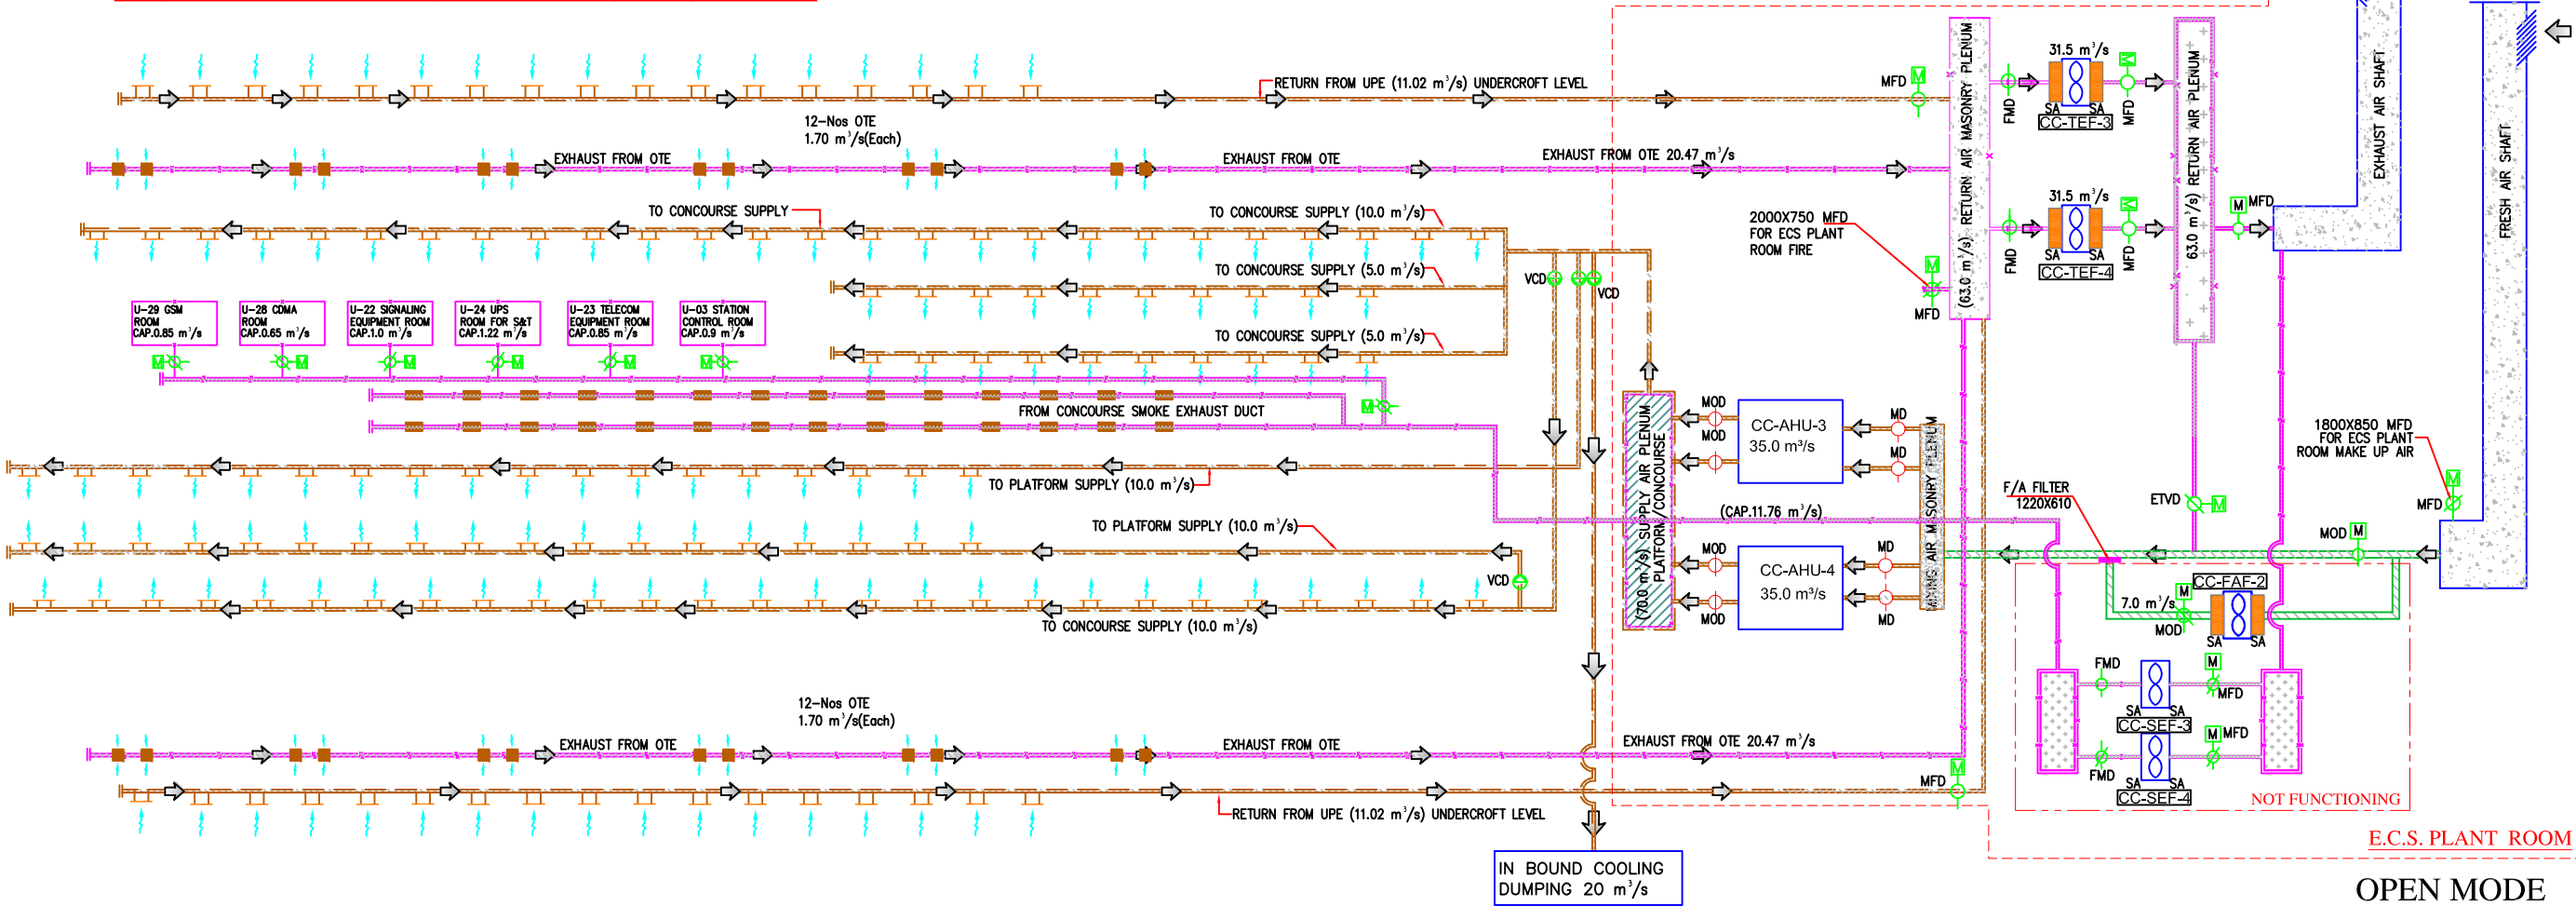

THIS DRAWING IS THE PROPERTY OF DELHI METRO RAIL CORPORATION LTD.	GENERAL NOTES: 1. ALL DIMENSIONS ARE IN MILLIMETERS. 2. ALL DIMENSIONS ARE TO BE READ AND NOT MEASURED. 3. ANY DISCREPANCIES MUST BE BROUGHT TO THE NOTICE OF THE DMRC BEFORE EXECUTION OF THE WORK AT SITE. 4. THIS DRAWING MUST BE READ IN CONJUNCTION WITH ALL RELEVANT ARCHITECTURAL, STRUCTURAL, PLUMBING & FIRE FIGHTING, ELECTRICAL AND TRAFFIC MANAGEMENT DRAWINGS. 5. ALL DOOR/WINDOW CILL & LINTEL LEVELS ARE MEASURED FROM MAIN FLOOR FINISHED LEVELS.		REVISIONS						APPROVAL BY DMRC				Certified that this document has been designed and checked in accordance with DDC Quality Assurance Plan.			Authorised Signatory for DDC. JP/EW/1B/DDC01 Project Manager			 DELHI METRO RAIL CORPORATION LTD. Metro Bhawan , Fire Brigade Lane, Barakhamba Road, New Delhi-110001																																																																																																																																																																																																																																																																																																																																																																																																																																																																																																																																																	
	REFERENCE DRAWINGS																																																																																																																																																																																																																																																																																																																																																																																																																																																																																																																																																																			

Abbreviations


AHU	Air Handling Unit	MOD	Motor Operated Damper
DC	Damper close	OTE	Over Track Exhaust
DO	Damper Open	R.A	Return Air
DB	Distribution Board	S.A	SUPPLY Air
FAF	Fresh Air Fan	T/A	To Above
F/A	From Above	T/B	To Below
F/B	From Below	TEA	Track Way Exhaust Attenuator
FCU	Fan Coil Unit	TEF	Track Way Exhaust Fan
FD	Fire Damper	UPE	Under Platform Exhaust
FMD	Manual Damper (Fire rated)	VCD	Volume Control Damper (Non fire rated)
MD	Manual Damper	VCF	Volume Control Damper (Fire rated)
MFD	Motorised Fire Damper	VEF	Ventilation Exhaust Fan
SEF	Smoke Extraction Fan	VSF	Ventilation SUPPLY Fan
SAP	SUPPLY Air Plenum	OBD	OCCosed Blade Dampere
RAP	Return Air Plenum		
BPD	Back Plate Damper		

Legend


	Axial Fan (Schematic)
	Damper Closed
	Damper Open
	Manual Isolation Damper
	Volume Control Damper
	Motorised Fire Damper
	Sound Attenuator

EQUIPMENT SCHEDULE


S.NO	EQUIPMENT	CAPACITY	QTY	REMACCS
1	AHU (PLATFORM+CONCOURSE)	35.0-m ³ /s (EACH)	2-NOS.	
2	TRACK WAY EXHAUST FAN	31.5 m ³ /s (EACH)	2-NOS	
3	FRESH AIR FAN	7.0 m ³ /s	1-NO.	
4	SMOKE EXHAUST FAN	11.76 m ³ /s	2-NOS. (1W+1S BY)	

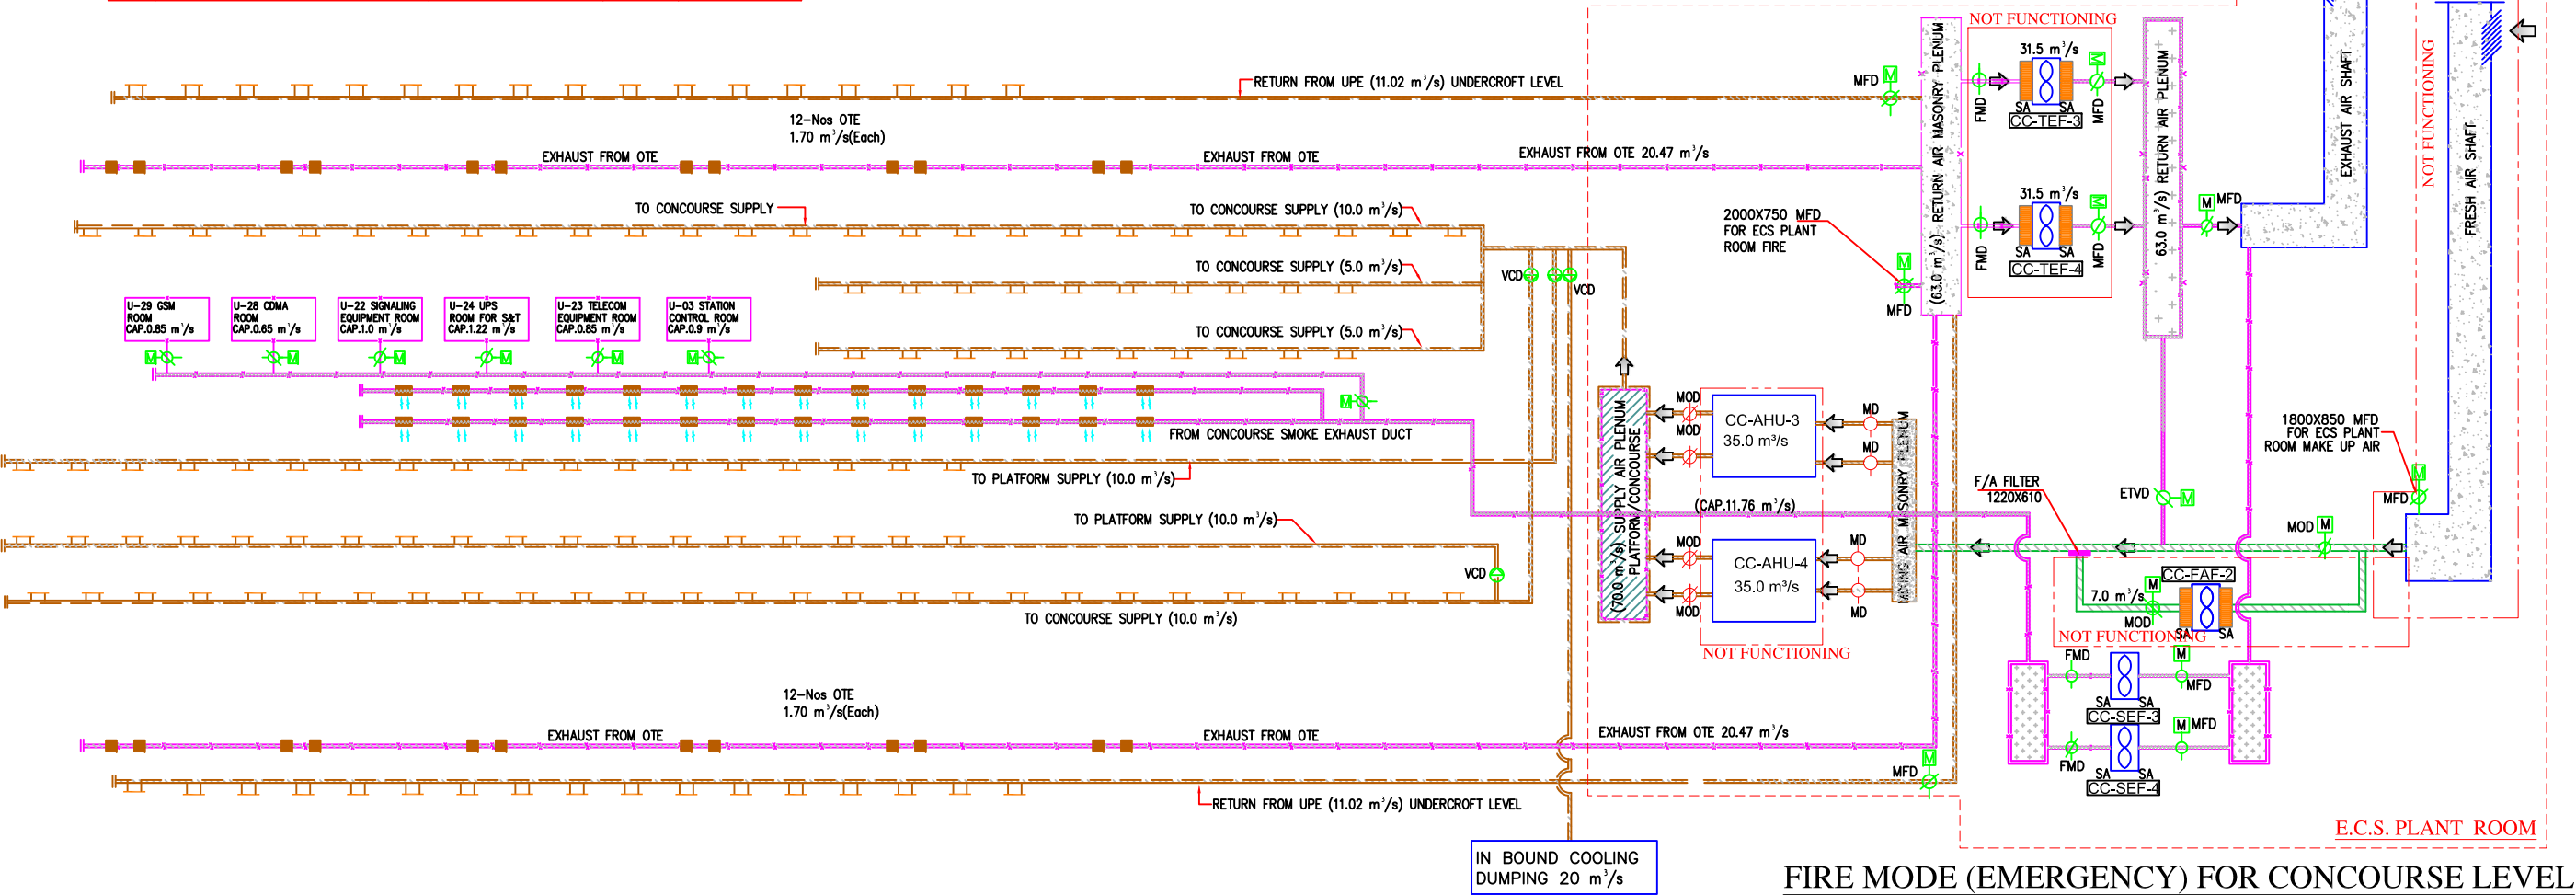

THIS DRAWING IS THE PROPERTY OF DELHI METRO RAIL CORPORATION LTD.	GENERAL NOTES: 1. ALL DIMENSIONS ARE IN MILLIMETERS. 2. ALL DIMENSIONS ARE TO BE READ AND NOT MEASURED. 3. ANY DISCREPANCIES MUST BE BROUGHT TO THE NOTICE OF THE DMRC BEFORE EXECUTION OF THE WORK AT SITE. 4. THIS DRAWING MUST BE READ IN CONJUNCTION WITH ALL RELEVANT ARCHITECTURAL, STRUCTURAL, PLUMBING & FIRE FIGHTING, ELECTRICAL AND TRAFFIC MANAGEMENT DRAWINGS. 5. ALL DOOR/WINDOW CILL & LINTEL LEVELS ARE MEASURED FROM MAIN FLOOR FINISHED LEVELS.		REVISIONS					APPROVAL BY DMRC				Certified that this document has been designed and checked in accordance with DDC Quality Assurance Plan.		Authorised Signatory for DDC. JP/EW/1B/DDC01 Project Manager		 DELHI METRO RAIL CORPORATION LTD. Metro Bhawan , Fire Brigade Lane, Barakhamba Road, New Delhi-110001		PHASE 1B JAIPUR METRO PROJECT		STATION: CHOTI CHOUPAR		DRAWING TITLE: AIR FLOW SCHEMATIC-ECS PLANT ROOM 19.2		DRAWN BY: ADIL CHECKED BY: NITIN VERIFIED BY: L.R.S		DATE: 03-02-2015 REV: R0 GRAPHICAL SCALE: 1:100 STATUS: FOR TENDER		DRAWING NUMBER: JP-TD-ECS-10CC-1608A SHEET NO. 1 OF 1 SHEET SIZE UNE A1 ORDER N° P36-0017		JP/EW/1B/DDC01 ECS													
	REFERENCE DRAWINGS											Architecture Design In-charge/ Coordinator		Structure Design In-charge/ Coordinator																		E&M Design In-charge/ Coordinator											
	Drg. No.		Description									DETAIL DESIGN CONSULTANT (DDC) FOR CIVIL, ARCHITECTURAL & BUILDING WORKS OF TWO UNDERGROUND STATION (CHOTI CHOUPAR & BADI CHOUPAR), SHAFT AND TUNNELS OF PHASE 1B OF JAIPUR METRO		 Engineering, Information, Imagination. 56, Indo-Asia House, Institutional Area, sector-44 Gurgaon - 122002 (Haryana)																													

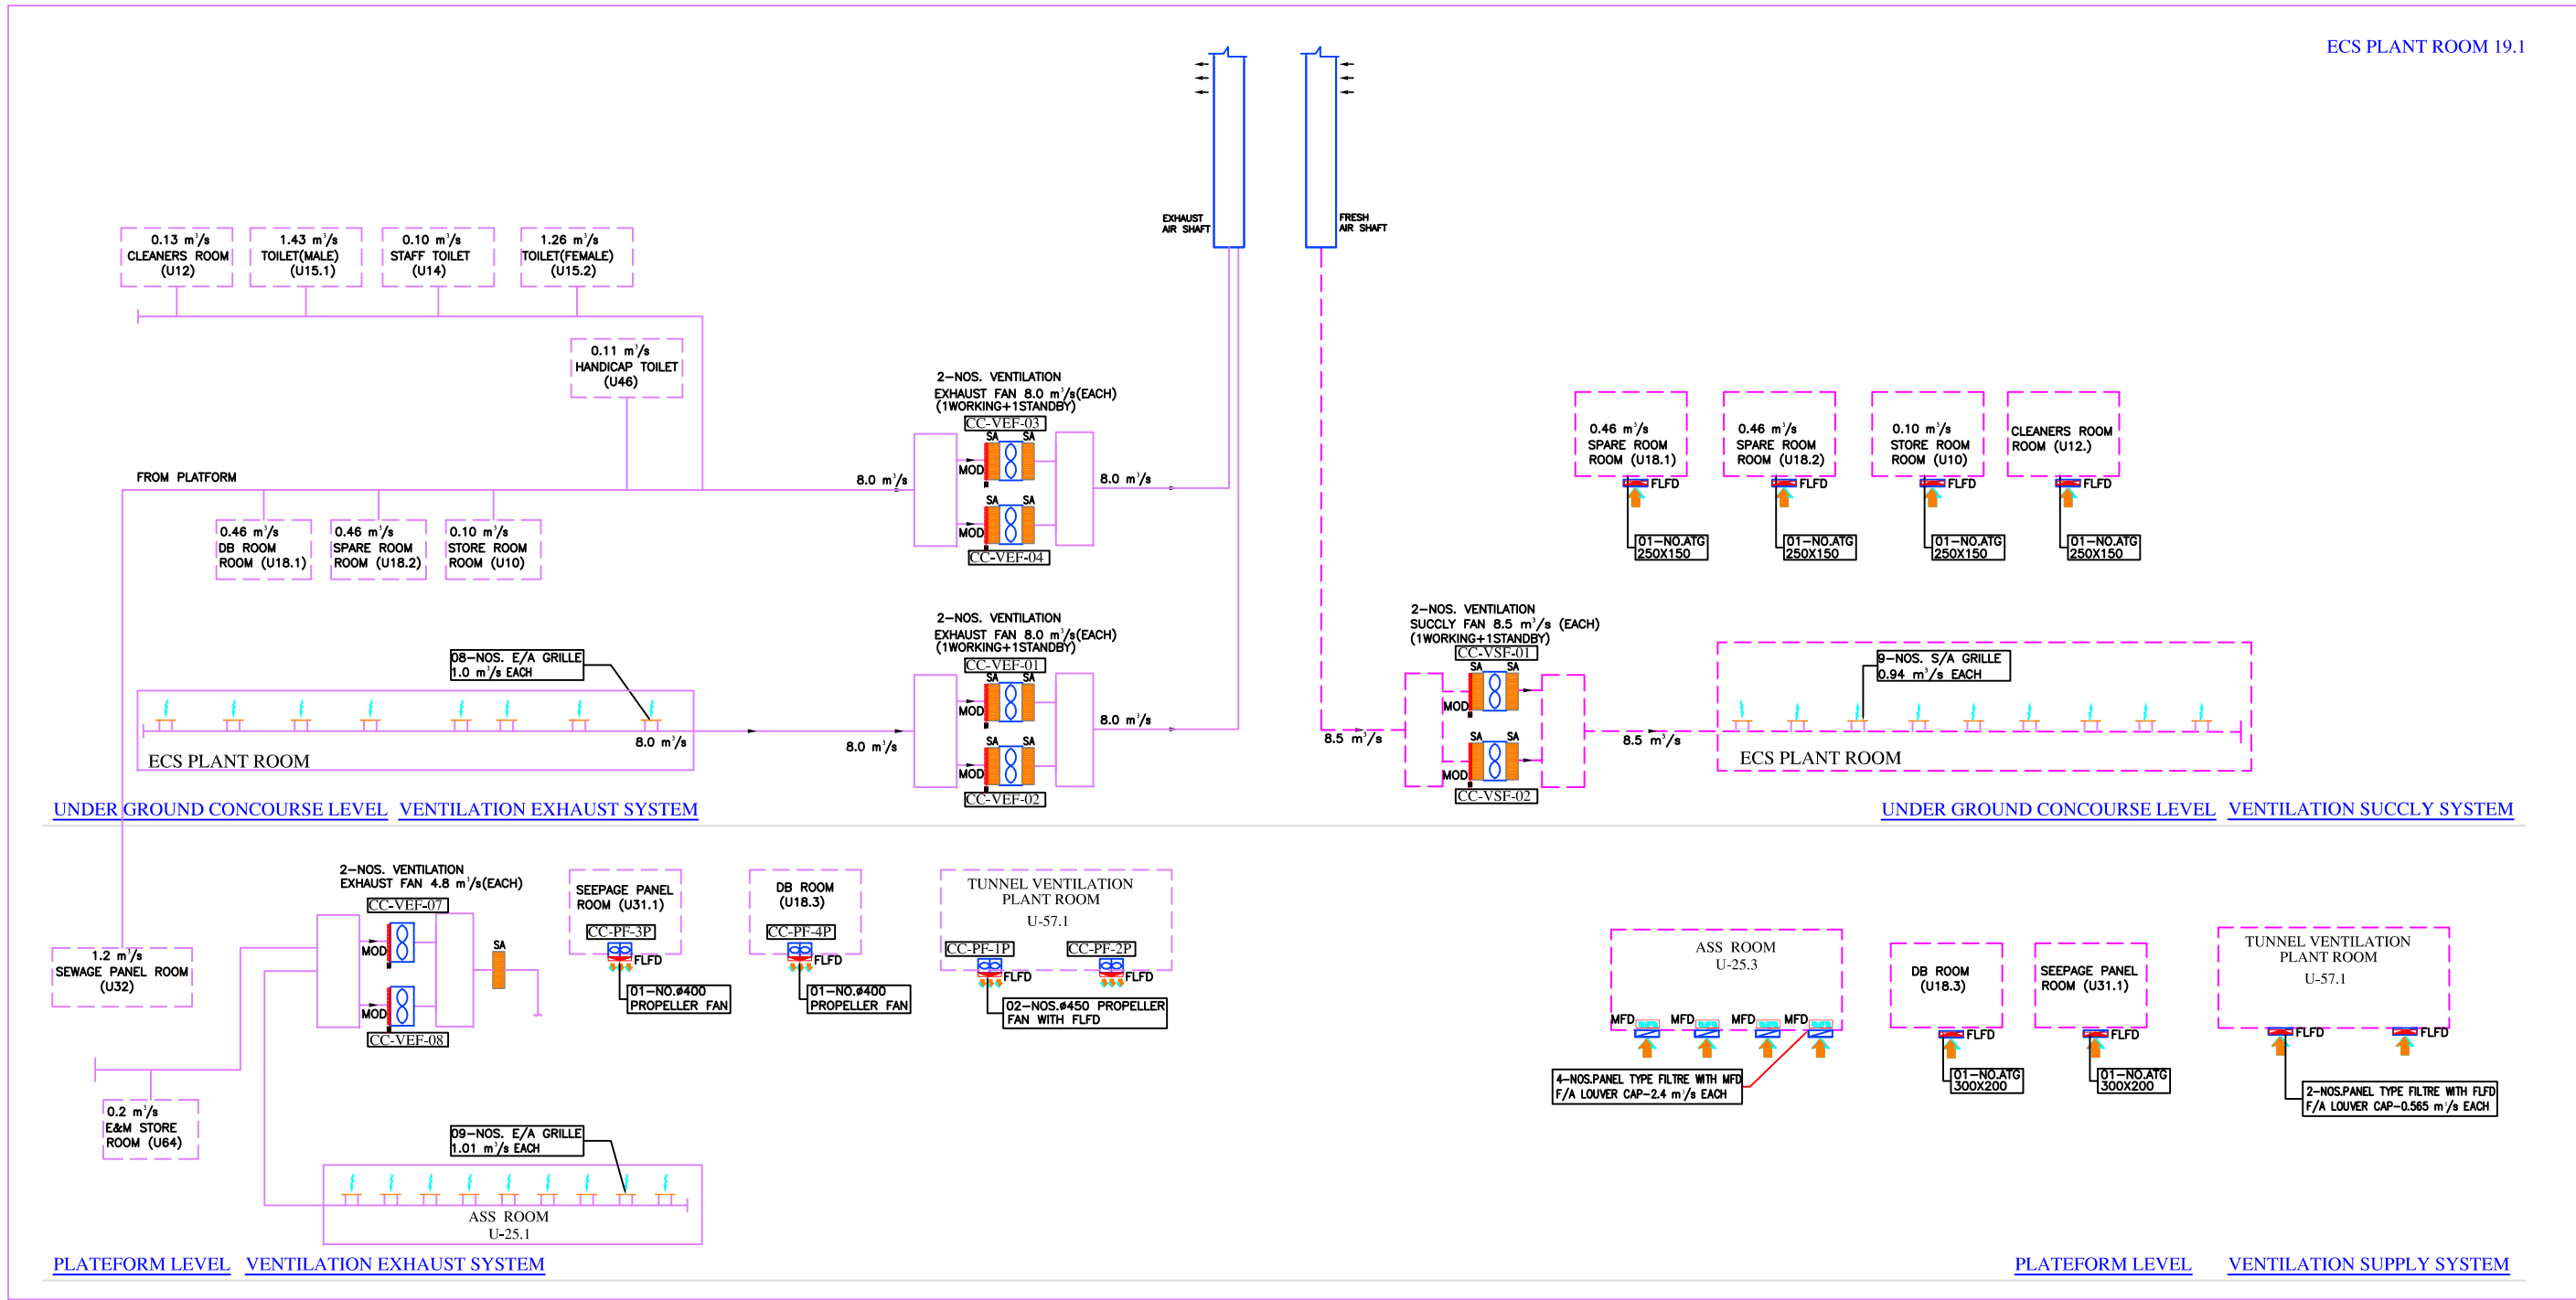


THIS DRAWING IS THE PROPERTY OF DELHI METRO RAIL CORPORATION LTD.	GENERAL NOTES: 1. ALL DIMENSIONS ARE IN MILLIMETERS. 2. ALL DIMENSIONS ARE TO BE READ AND NOT MEASURED. 3. ANY DISCREPANCIES MUST BE BROUGHT TO THE NOTICE OF THE DMRC BEFORE EXECUTION OF THE WORK AT SITE. 4. THIS DRAWING MUST BE READ IN CONJUNCTION WITH ALL RELEVANT ARCHITECTURAL, STRUCTURAL, PLUMBING & FIRE FIGHTING, ELECTRICAL AND TRAFFIC MANAGEMENT DRAWINGS. 5. ALL DOOR/WINDOW CILL & LINTEL LEVELS ARE MEASURED FROM MAIN FLOOR FINISHED LEVELS.		REVISIONS						APPROVAL BY DMRC				Certified that this document has been designed and checked in accordance with DDC Quality Assurance Plan.			Authorised Signatory for DDC. JP/EW/1B/DDC01 Project Manager			 DELHI METRO RAIL CORPORATION LTD. Metro Bhawan , Fire Brigade Lane, Barakhamba Road, New Delhi-110001																																																																																																																																																																																																																																																																																																																																																																																																																																																																																																																																		
	REFERENCE DRAWINGS																																																																																																																																																																																																																																																																																																																																																																																																																																																																																																																																																				

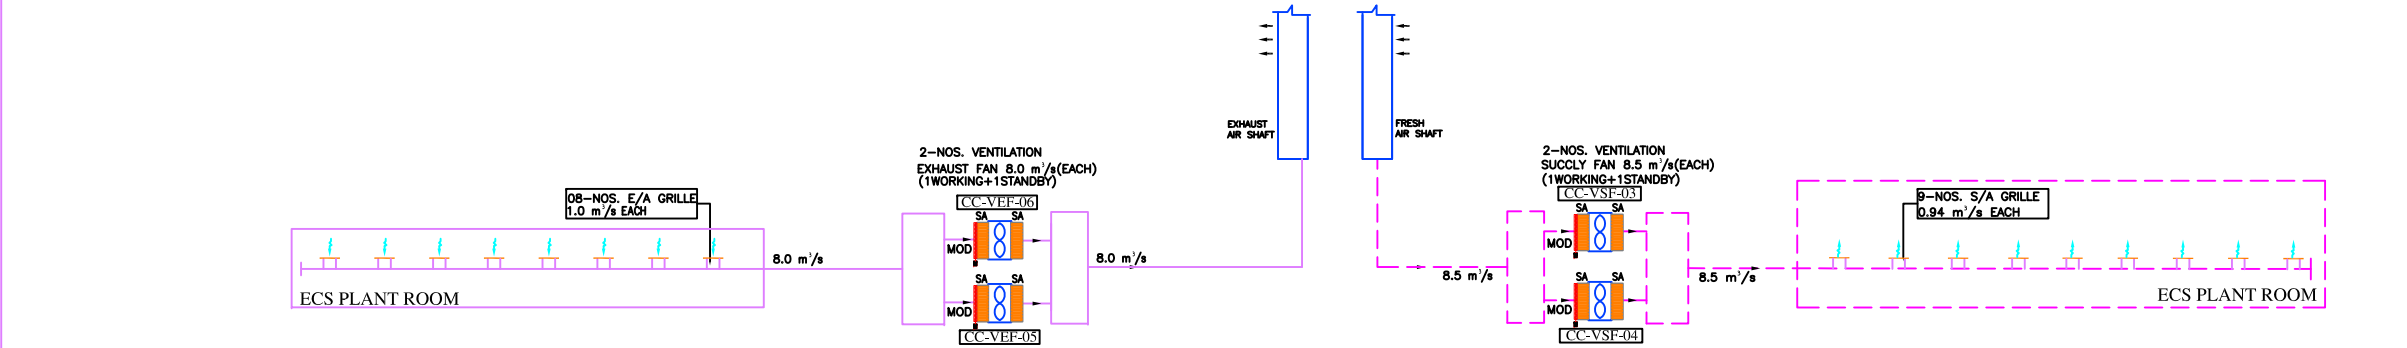


UNDER GROUND CONCOURSE LEVEL VENTILATION EXHAUST SYSTEM

UNDER GROUND CONCOURSE LEVEL VENTILATION SUPPLY SYSTEM

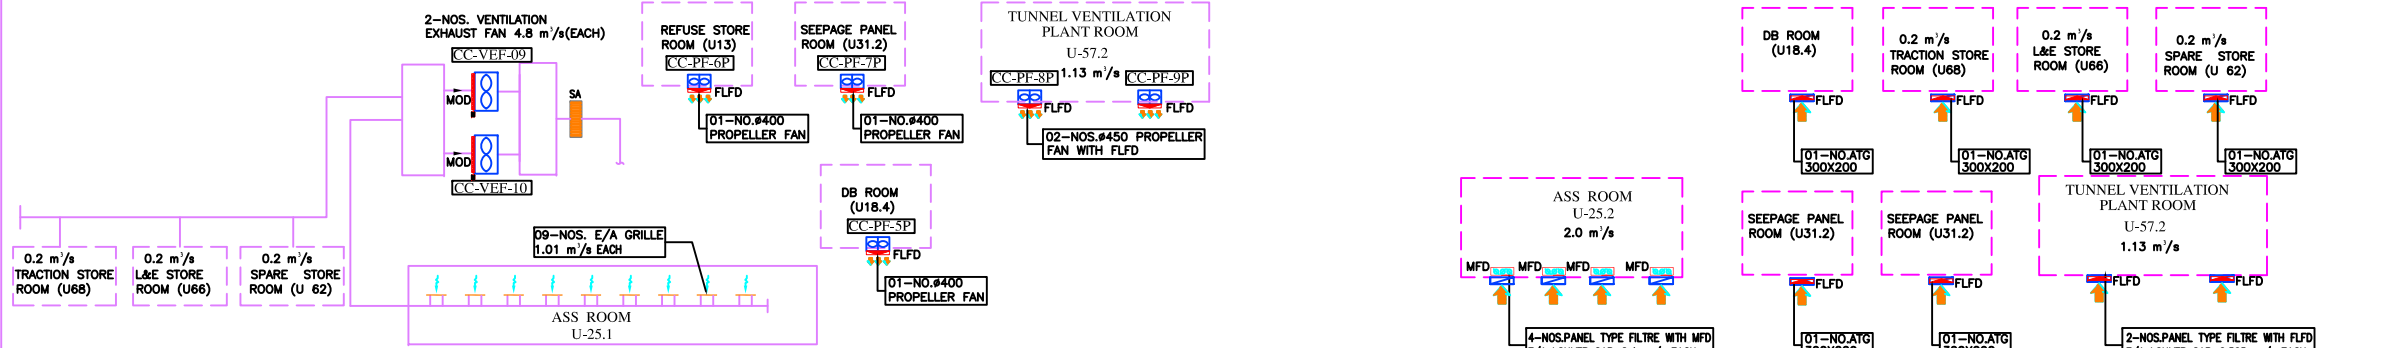

PLATFORM LEVEL VENTILATION EXHAUST SYSTEM

PLATFORM LEVEL VENTILATION SUPPLY SYSTEM

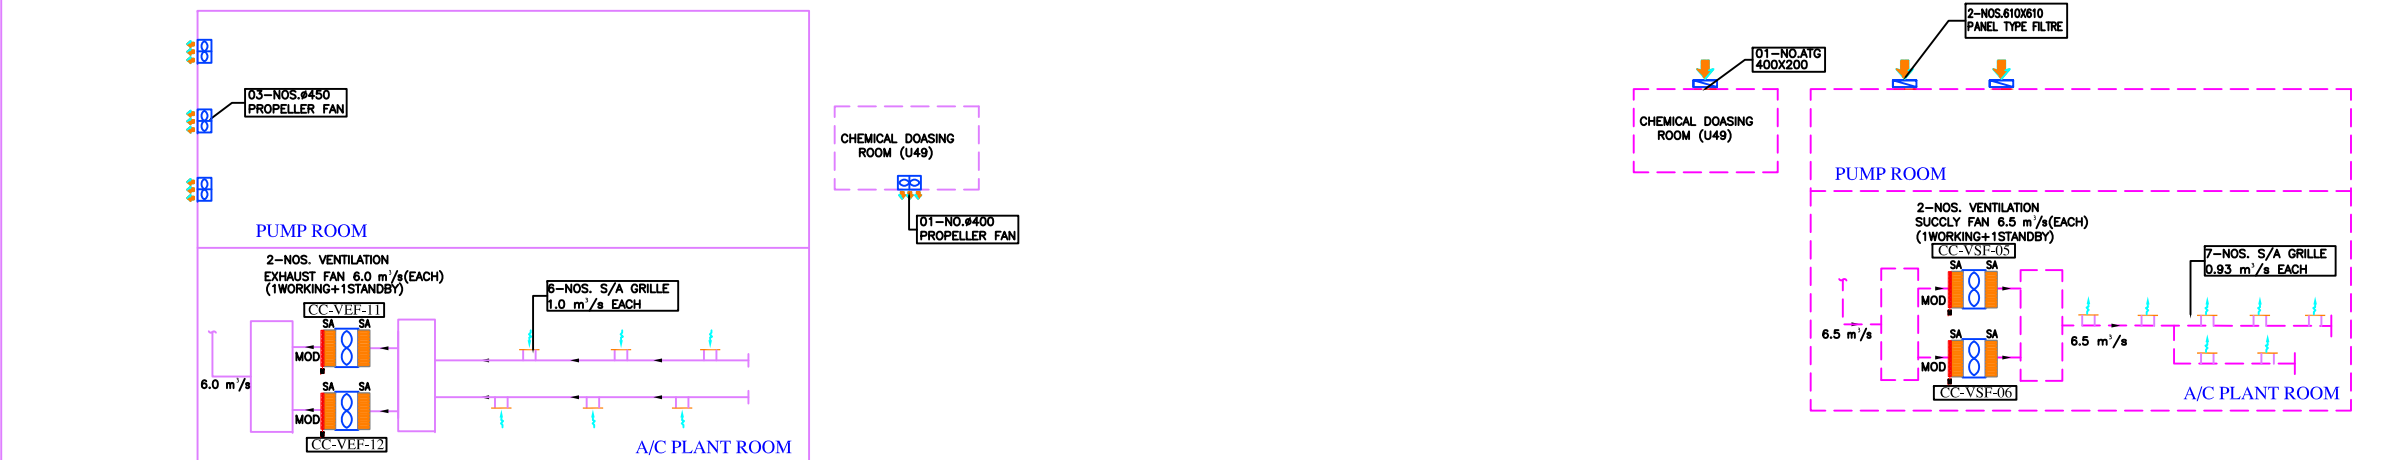


VENTILATION EXHAUST SYSTEM

VENTILATION SUPPLY SYSTEM


GENERAL NOTES 1. ALL DIMENSIONS ARE IN MILLIMETERS. 2. ALL DIMENSIONS ARE TO BE READ AND NOT MEASURED. 3. ANY DISCREPANCIES MUST BE BROUGHT TO THE NOTICE OF THE DMRC BEFORE EXECUTION OF THE WORK AT SITE. 4. THIS DRAWING MUST BE READ IN CONJUNCTION WITH ALL RELEVANT ARCHITECTURAL, STRUCTURAL, PLUMBING & FIRE FIGHTING, ELECTRICAL AND TRAFFIC MANAGEMENT DRAWINGS. 5. ALL DOOR/WINDOW CILL & LINTEL LEVELS ARE MEASURED FROM MAIN FLOOR FINISHED LEVELS.	REVISIONS							APPROVAL BY DMRC				Certified that this document has been designed and checked in accordance with DDC Quality Assurance Plan.			Authorised Signatory for DDC. JP/EW/1B/DDC01 Project Manager			 DELHI METRO RAIL CORPORATION LTD. Metro Bhawan , Fire Brigade Lane, Barakhamba Road, New Delhi-110001	
								DMRC APPROVAL	MGR/ARCH	DY CA (UG)II	CA/ARCH	Architecture Design In-charge/ Coordinator	Structure Design In-charge/ Coordinator	E&M Design In-charge/ Coordinator	DETAIL DESIGN CONSULTANT (DDC) FOR CIVIL, ARCHITECTURAL & BUILDING WORKS OF TWO UNDERGROUND STATION (CHOTI CHOUPAR & BADI CHOUPAR), SHAFT AND TUNNELS OF PHASE 1B OF JAIPUR METRO  ayesa Engineering, Information, Imagination. 56, Indo-Asja House, Institutional Area, sector-44 Gurgaon - 122002 (Haryana)				
								DY CSTE/TELECOM	CSTE-I	DY CE/DESIGN	CE/TECH								
								DY CSTE/AFC		EDIS&T	CSO								
								DY CSTE/SIGNALLING	CSTE-II	GM/O	GM/M								
								DY CE/PLANNING	DY CEE/E&M	DY CEE/ECS	ED/ELEC-II								
	DY CEE/(E)UG-TR	CGM(E) UG-TR	PM	CPM															
	REFERENCE DRAWINGS																		
	Drg. No.		Description																
				</															

ECS PLANT ROOM 19.1 SIDE

ECS PLANT ROOM 19.2 SIDE

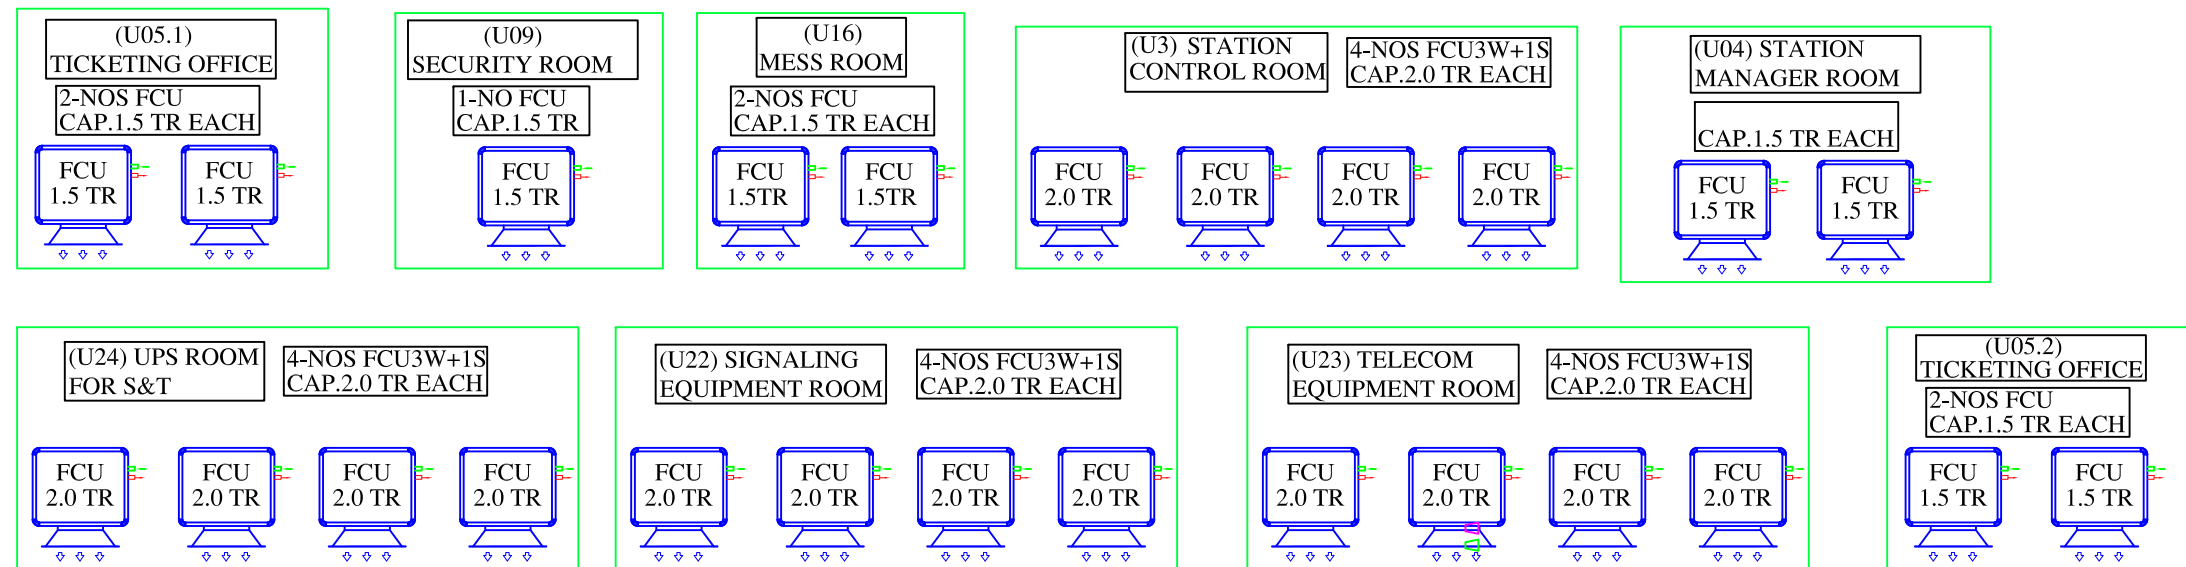

UNDER GROUND CONCOURSE LEVEL

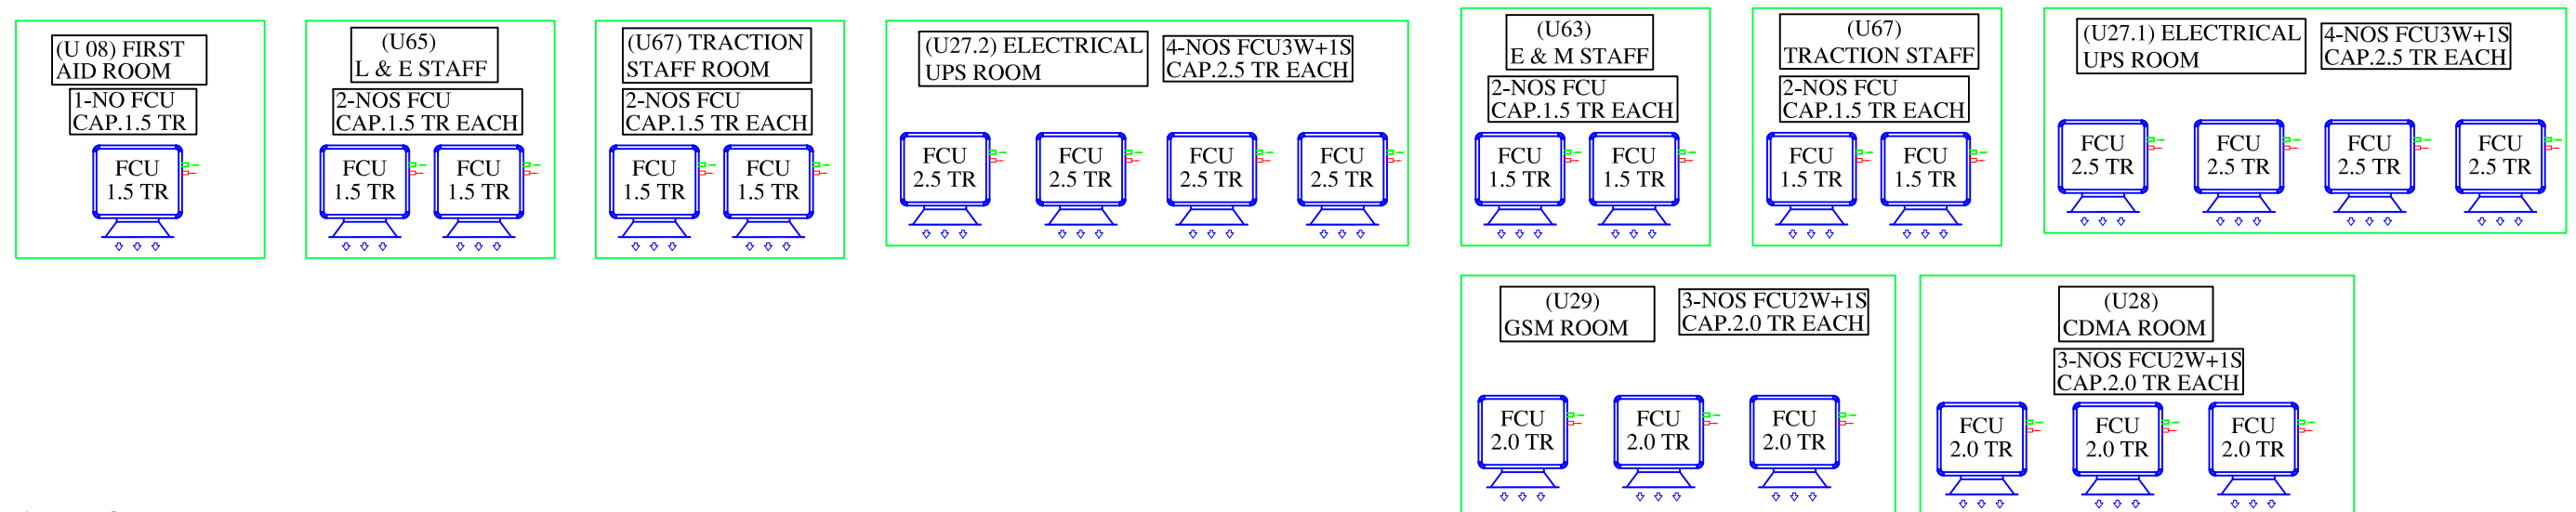

PLATFORM LEVEL

THIS DRAWING IS THE PROPERTY OF DELHI METRO RAIL CORPORATION LTD.	GENERAL NOTES: 1. ALL DIMENSIONS ARE IN MILLIMETERS. 2. ALL DIMENSIONS ARE TO BE READ AND NOT MEASURED. 3. ANY DISCREPANCIES MUST BE BROUGHT TO THE NOTICE OF THE DMRC BEFORE EXECUTION OF THE WORK AT SITE. 4. THIS DRAWING MUST BE READ IN CONJUNCTION WITH ALL RELEVANT ARCHITECTURAL, STRUCTURAL, PLUMBING & FIRE FIGHTING, ELECTRICAL AND TRAFFIC MANAGEMENT DRAWINGS. 5. ALL DOOR/WINDOW CILL & LINTEL LEVELS ARE MEASURED FROM MAIN FLOOR FINISHED LEVELS.		REVISIONS						APPROVAL BY DMRC				Certified that this document has been designed and checked in accordance with DDC Quality Assurance Plan.			Authorised Signatory for DDC. JP/EW/1B/DDC01 Project Manager			 DELHI METRO RAIL CORPORATION LTD. Metro Bhawan , Fire Brigade Lane, Barakhamba Road, New Delhi-110001																																																																																																																																																																																																																																																																																																																																																																																																																																																																																																																																		
	REFERENCE DRAWINGS																																																																																																																																																																																																																																																																																																																																																																																																																																																																																																																																																				</

LIST OF ECS/TVS DRAWINGS

SR.NO.	DESCRIPTION	DRAWING NO.	REVISION NO.
	CHOTI CHOUPER STATION		
01	LIST OF ECS/TVS DRAWINGS	JP-TD-ECS/TVS-10CC-1001	R0
02	ECS-TV S LAYOUT LEGENDS & NOTES	JP-TD-ECS/TVS-10CC-1002	R0
03	ECS LAYOUT ANCILLARY BUILDING LOWER GROUND LEVEL	JP-TD-ECS-10CC-1201	R0
04	ECS LAYOUT ANCILLARY BUILDING TERRACE LEVEL	JP-TD-ECS-10CC-1202	R0
05	ECS-TV S LAYOUT CONCOURSE LEVEL (SHEET-1 OF 3)	JP-TD-ECS/TVS-10CC-1301	R0
06	ECS-TV S LAYOUT CONCOURSE LEVEL (SHEET-2 OF 3)	JP-TD-ECS/TVS-10CC-1302	R0
07	ECS-TV S LAYOUT CONCOURSE LEVEL (SHEET-3 OF 3)	JP-TD-ECS/TVS-10CC-1303	R0
08	ECS-TV S LAYOUT PLATFORM LEVEL (SHEET-1 OF 3)	JP-TD-ECS/TVS-10CC-1401	R0
09	ECS-TV S LAYOUT PLATFORM LEVEL (SHEET-2 OF 3)	JP-TD-ECS/TVS-10CC-1402	R0
10	ECS-TV S LAYOUT PLATFORM LEVEL (SHEET-3 OF 3)	JP-TD-ECS/TVS-10CC-1403	R0
11	ECS-TV S LAYOUT UNDERCROFT LEVEL (SHEET-1 OF 3)	JP-TD-ECS/TVS-10CC-1501	R0
12	ECS-TV S LAYOUT UNDERCROFT LEVEL (SHEET-2 OF 3)	JP-TD-ECS/TVS-10CC-1502	R0
13	ECS-TV S LAYOUT UNDERCROFT LEVEL (SHEET-3 OF 3)	JP-TD-ECS/TVS-10CC-1503	R0
14	CHILLED WATER PIPING SCHEMATIC LAYOUT	JP-TD-ECS-10CC-1601	R0
15	CONDENSER WATER PIPING SCHEMATIC	JP-TD-ECS-10CC-1602	R0
16	AIR FLOW SCHEMATIC – ECS PLANT ROOM 19.1 CLOSE MODE (SUMMER)	JP-TD-ECS-10CC-1603	R0
17	AIR FLOW SCHEMATIC – PLATFORM 19.1 FIRE MODE (EMERGENCY)	JP-TD-ECS-10CC-1604	R0
18	AIR FLOW SCHEMATIC – ECS PLANT 19.1 END OPEN MODE (WINTER)	JP-TD-ECS-10CC-1605	R0
19	AIR FLOW SCHEMATIC – ECS PLANT ROOM 19.2 CLOSED MODE (SUMMER)	JP-TD-ECS-10CC-1606	R0
20	AIR FLOW SCHEMATIC – PLATFORM 19.2 FIRE MODE (EMERGENCY)	JP-TD-ECS-10CC-1607	R0
21	AIR FLOW SCHEMATIC – ECS PLANT ROOM 19.2 OPEN MODE (WINTER)	JP-TD-ECS-10CC-1608	R0
22	AIR FLOW SCHEMATIC – ECS PLANT 19.1 (EMERGENCY CONCOURSE)	JP-TD-ECS-10CC-1605A	R0
23	AIR FLOW SCHEMATIC – ECS PLANT 19.2 (EMERGENCY CONCOURSE)	JP-TD-ECS-10CC-1608A	R0
24	AIR FLOW SCHEMATIC – AIR FLOW VENTILATION ECS PLANT ROOM 19.1	JP-TD-ECS-10CC-1609	R0
25	AIR FLOW SCHEMATIC – AIR FLOW VENTILATION ECS PLANT ROOM 19.2	JP-TD-ECS-10CC-1610	R0
26	AIR FLOW SCHEMATIC FOR FCU	JP-TD-ECS-10CC-1611	R0

[illegible]

NOTES:-

1. ALL DIMENSIONS ARE IN MM. UNLESS OTHERWISE SPECIFIED.
2. ALL SUPPLY AND RETURN AIR DUCTING INSULATED WITH 25mm. THK. FIBREGLASS INSULATION IN A/C AREA.
3. ALL SUPPLY AND RETURN AIR DUCTING INSULATED WITH 50mm. THK. FIBREGLASS INSULATION IN NON-A/C AREA.
4. ALL CHILLED WATER PIPING INSULATED AS PER SPECIFICATION.
5. ALL LEVELS OF DUCTS AND PIPES ARE FROM FINISHED FLOOR LEVELS.
6. FOR SECTION REFER DRG. NO L8-CRD-ECS-09VV-1701 .
7. FOR ECS RELATED ELECTRICAL PLEASE REFER ELECTRICAL LAYOUT.

ABBREVIATIONS

CC	CHOTI CHOUPER STATION	NB	Nominal Bore
AHU	Air Handling Unit	OTE	Over Track Exhaust
DC	Damper close	R.A.G	Return Air Grille
DO	Damper Open	S.A.G	Supply Air Grille
DB	Distribution Board	C.S.G	Continous Supply Grille
ECA	Environment Control Attenuator	F.A.G	Fresh Air Grille
FAF	Fresh Air Fan	T/A	To Above
F/A	From Above	T/B	To Below
F/B	From Below	TEA	Track Way Exhaust Attenuator
FCU	Fan Coil Unit	TEF	Track Way Exhaust Fan
FD	Fire Damper(Fusible Link)	UPE	Under Platform Exhaust
FMD	Manual Damper (Fire rated)	VCD	Volume Control Damper (Non fire rated)
MD	Manual Damper	VCF	Volume Control Damper (Fire rated)
MFD	Motorised Fire Damper	VEF	Ventilation Exhaust Fan
DC/S	Damper Closed (Summer)	VSF	Ventilation Supply Fan
DO/M	Damper Open (Monsoon)	B.O.D.	Bottom of Duct
SAP	Supply Air Plenum	PRD	Pressure Relief Damper
RAP	Return Air Plenum	NO	Normally Open
SUI	Split Unit Indoor	CHWP	CHILLED WATER PIPE
SUO	Split Unit Outdoor	CDWP	CONDENSER WATER PIPE
DUC	Door Under Cut	VSD	VENTILATION SUPPLY DUCT
NC	Normally cloused	VED	VENTILATION EXHAUST DUCT
MOD	Motor Operated Damper		


LEGEND

	CHW SUPPLY PIPE
	CHW RETURNE PIPE
	CHW SUPPLY PIPE(AIR COOLED CHILLER)
	CHW RETURNE PIPE(AIR COOLED CHILLER)
	CDW SUPPLY PIPE
	CDW RETURNE PIPE
	EQUALIZER HEADER
	MAKEUP HEADER
	DRAIN&OVERFLOW HEADER
	VENTILATION EXHAUST DUCT
	VENTILATION SUPPLY DUCT
	MOTORISED OPRATED DAMPER
	VOLUME CONTROL DAMPER
	MOTORISED FIRE DAMPER
	FIRE RATED MANUAL DAMPER
	MANUAL DAMPER
	RETURNE AIR DUCT FIRE RATED
	SUPPLY AIR DUCT
	VENTILATION SUPPLY AIR DUCT
	VENTILATION EXHAUST AIR DUCT
	STAIRCASE PRESSURIZATION DUCT
	SMOKE EXHAUST DUCT
	SUPPLY AIR GRILLE
	EXHAUST/SMOKE EXHAUST GRILLE
	UNDER PLATFORM EXHAUST GRILLE
	BALANCING VALVE
	BUTTER FLY VALVE
	GATE VALVE

LEGEND

	AIR HANDLING UNIT(FLOOR MOUNTED)
	COOLING TOWER
	AIR COOLED CHILLER
	WATER COOLED CHILLER
	CONDENSER PUMP
	SECONDARY PUMP
	PRIMARY PUMP
	FAN COIL UNIT
	TRACK WAY EXHAUST FAN
	AXIL FAN
	PROPELLER FAN
	TUNNEL VENTILATION FAN

THIS DRAWING IS THE PROPERTY OF DELHI METRO RAIL CORPORATION LTD.	GENERAL NOTES: 1. ALL DIMENSIONS ARE IN MILLIMETERS. 2. ALL DIMENSIONS ARE TO BE READ AND NOT MEASURED. 3. ANY DISCREPANCIES MUST BE BROUGHT TO THE NOTICE OF THE DMRC BEFORE EXECUTION OF THE WORK AT SITE. 4. THIS DRAWINGS MUST BE READ IN CONJUNCTION WITH ALL RELEVANT ARCHITECTURAL, STRUCTURAL, PLUMBING & FIRE FIGHTING, ELECTRICAL AND TRAFFIC MANAGEMENT DRAWINGS. 5. ALL DOOR/WINDOW CILL & LINTEL LEVELS ARE MEASURED FROM MAIN FLOOR FINISHED LEVELS.										REVISIONS				APPROVAL BY DMRC				Certified that this document has been designed and checked in accordance with DDC Quality Assurance Plan.			Authorised Signatory for DDC. JP/EW/1B/DDC01 Project Manager			 DELHI METRO RAIL CORPORATION LTD. Metro Bhawan , Fire Brlgade Lane, Barakhamba Road, New Delhi-110001		
																						PHASE 1B JAIPUR METRO PROJECT					
																						STATION: CHOTI CHOUPAR					
																						DRAWING TITLE: ECS/TVS LAYOUT LEGENDS & NOTES					
																								JP/EW/1B/DDC01 ECS/TVS			

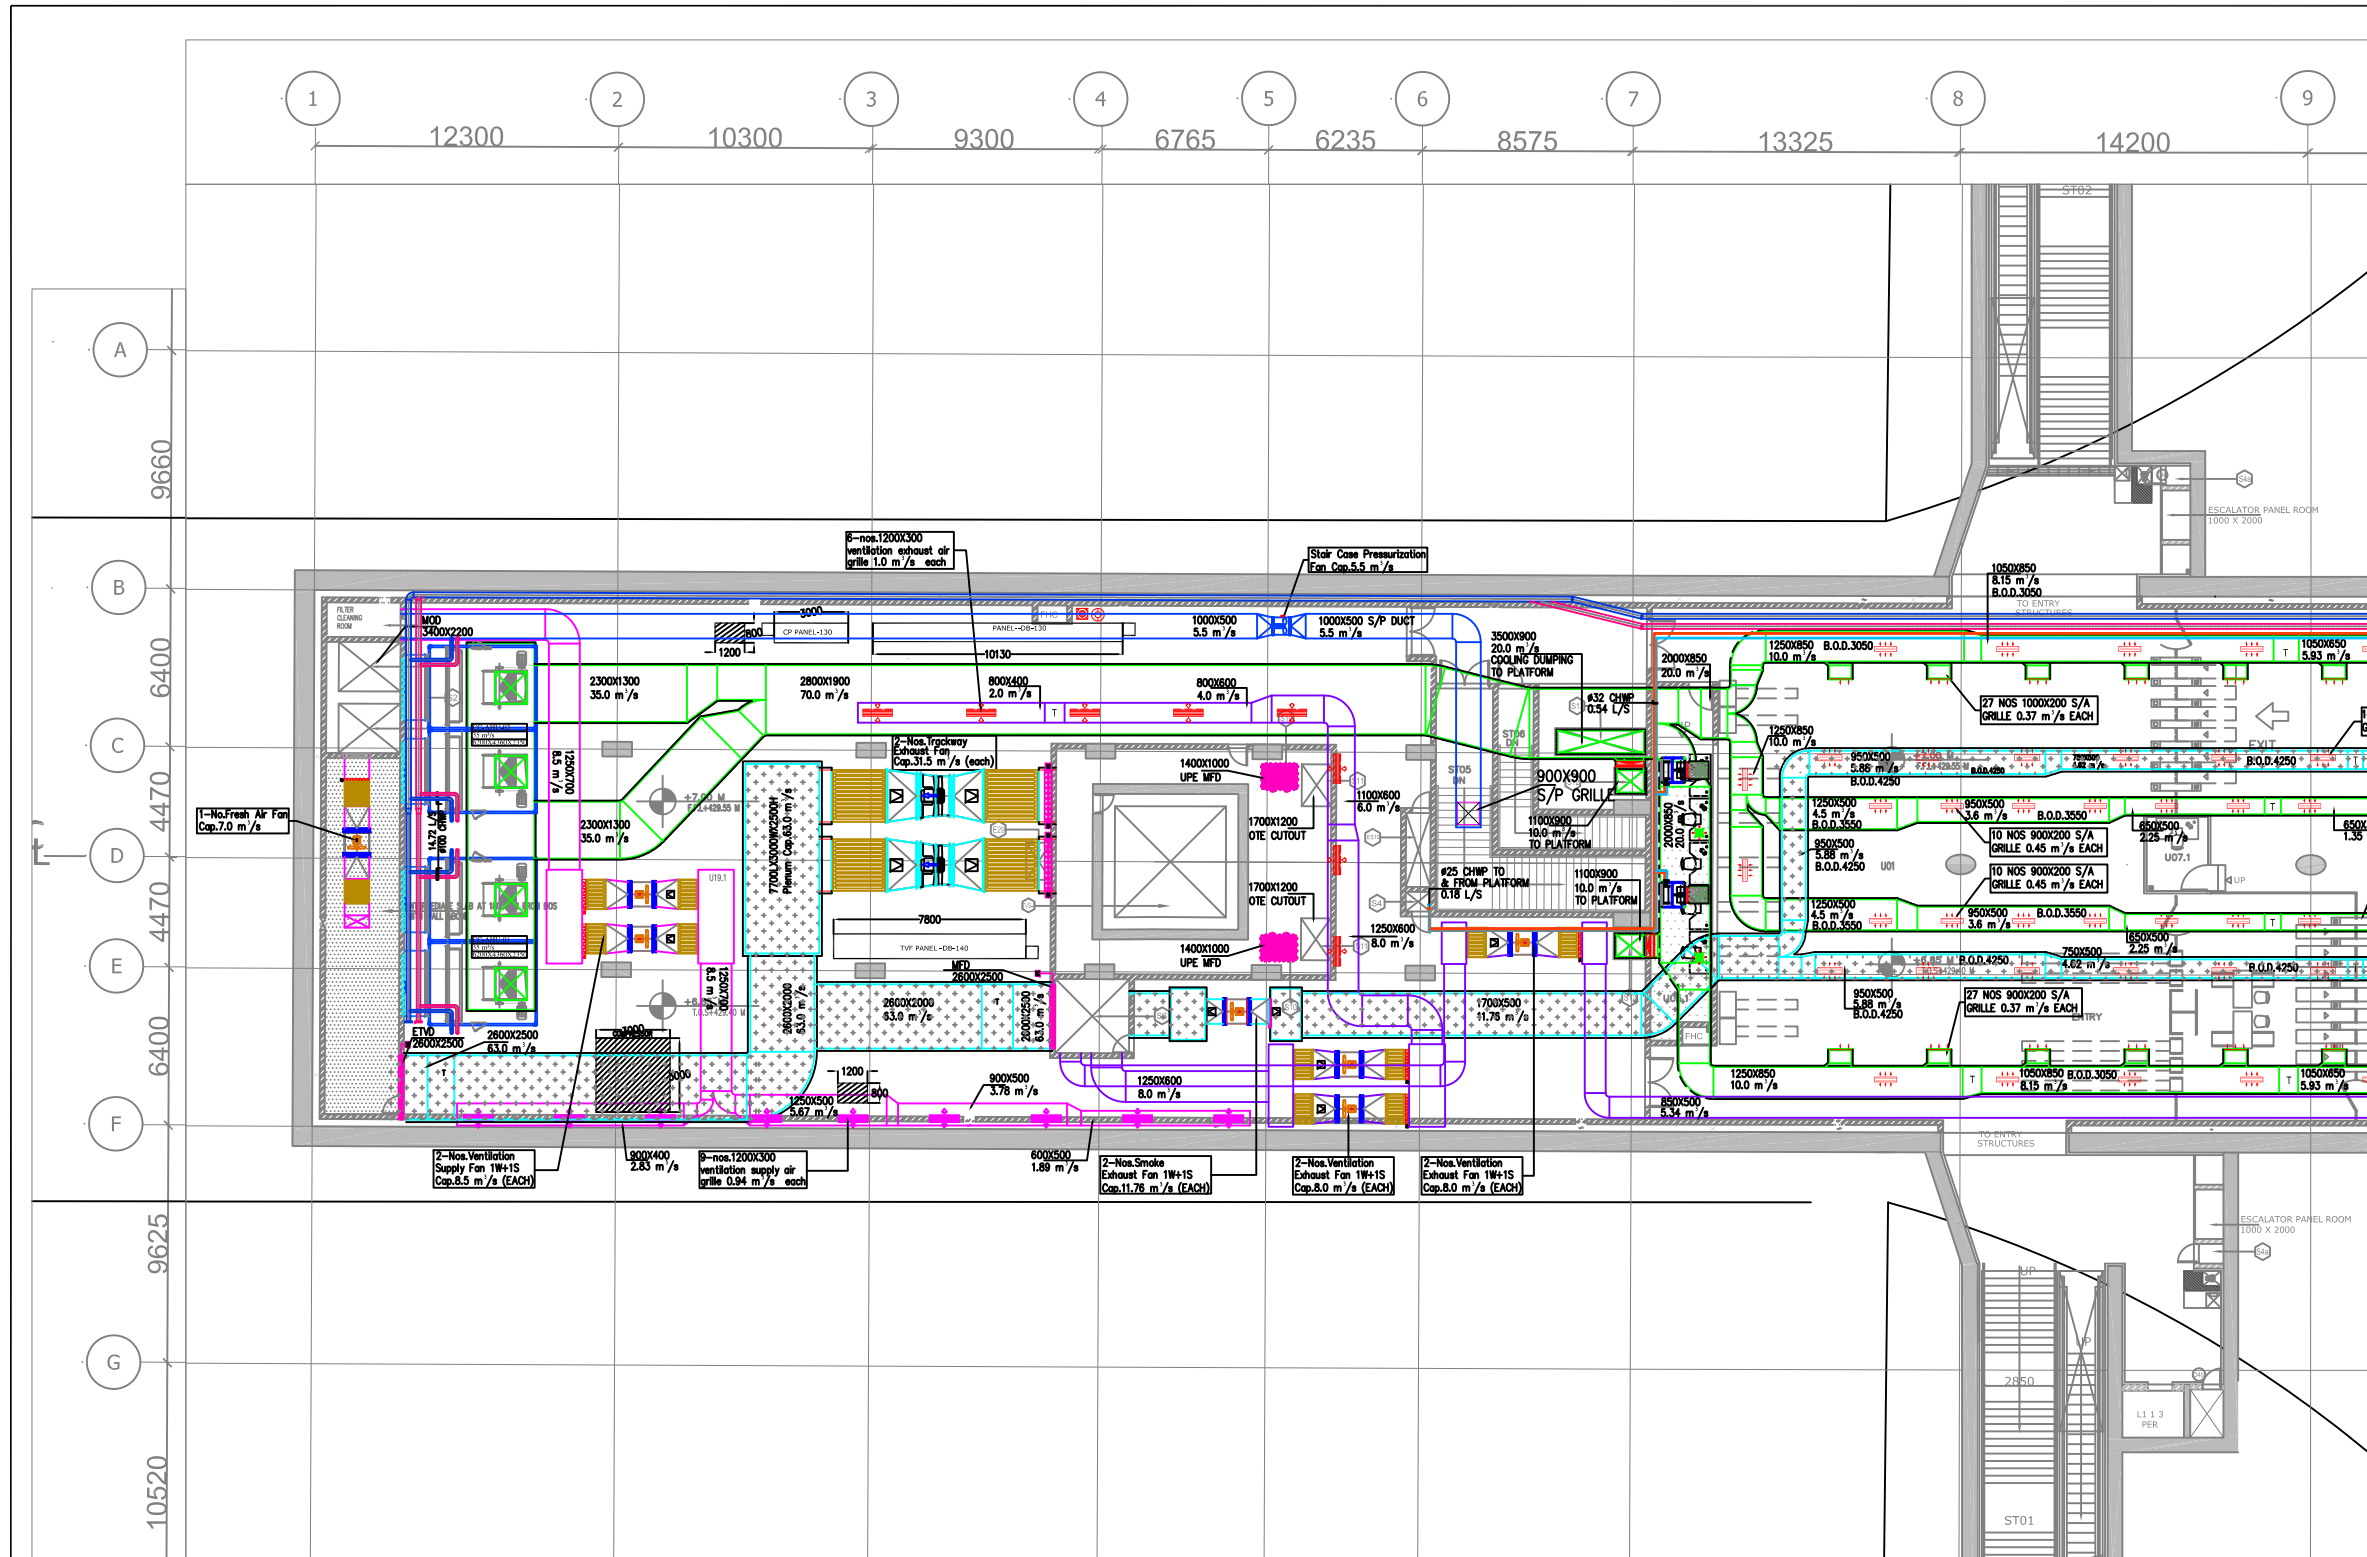

NOTES:-

1. ALL DIMENSIONS ARE IN MM. UNLESS OTHERWISE SPECIFIED.
2. ALL SUPPLY AND RETURN AIR DUCTING INSULATED WITH 25mm. THK. FIBREGLASS INSULATION IN A/C AREA.
3. ALL SUPPLY AND RETURN AIR DUCTING INSULATED WITH 50mm. THK. FIBREGLASS INSULATION IN NON-A/C AREA.
4. ALL CHILLED WATER PIPING INSULATED AS PER SPECIFICATION.
5. ALL LEVELS OF DUCTS AND PIPES ARE FROM FINISHED FLOOR LEVELS.
6. FOR ECS RELATED ELECTRICAL PLEASE REFER ECS ELECTRICAL LAYOUT.

LEGEND

- CHW SUPPLY PIPE
- CHW RETURN PIPE
- CHW SUPPLY PIPE(AIR COOLED CHILLER)
- CHW RETURN PIPE(AIR COOLED CHILLER)
- CDW SUPPLY PIPE
- CDW RETURN PIPE
- EQUALIZER HEADER
- MAKEUP HEADER
- DRAIN&OVERFLOW HEADER
- VENTILATION EXHAUST DUCT
- VENTILATION SUPPLY DUCT
- MOTORISED OPERATED DAMPER
- VOLUME CONTROL DAMPER
- MOTORISED FIRE DAMPER
- FIRE RATED MANUAL DAMPER
- MANUAL DAMPER
- RETURN AIR DUCT FIRE RATED
- SUPPLY AIR DUCT
- VENTILATION SUPPLY AIR DUCT
- VENTILATION EXHAUST AIR DUCT
- STAIRCASE PRESSURIZATION DUCT
- SMOKE EXHAUST DUCT
- SUPPLY AIR GRILLE
- EXHAUST/SMOKE EXHAUST GRILLE
- UNDER PLATFORM EXHAUST GRILLE

ABBREVIATIONS

CC CHOTI CHOUPAR STATION
AHU Air Handling Unit
FAF Fresh Air Fan
FCU Fan Coil Unit
MD Manual Damper
MFD Motorised Fire Damper
MOD Motor Operated Damper
OTE Over Track Exhaust
RAG Return Air Grille
SAG Supply Air Grille
FAG Fresh Air Grille
TEF Track Way Exhaust Fan
UPE Under Platform Exhaust
VCD Volume Control Damper (Non fire rated)
VEF Ventilation Exhaust Fan
VSF Ventilation Supply Fan
B.O.D. Bottom of Duct
CHWP CHILLED WATER PIPE
CDWP CONDENSER WATER PIPE
VSD VENTILATION SUPPLY DUCT
VED VENTILATION EXHAUST DUCT

LEGEND

AIR HANDLING UNIT FLOOR MOUNTED

FAN COIL UNIT

TRACK WAY EXHAUST FAN

AXIL FAN

PROPELLER FAN

TUNNEL VENTILATION FAN


MATCH LINE FOR CONTINUATION REFER DRAWING NO. - JP-1

ROOM SCHEDULE			AREA (Sq.m)	
S.NO.	ROOM SCHEDULE	ROOM NAME	DIMENSION (M) (LxW)	AREA (Sq.m)
1	U01	UNPAID AREA		1035.90*
2	U02	PAID AREA		1487.75*
3	U03	STATION CONTROL ROOM (SCR)	7.700 x 7.050	54.29
4	U04	STATION MANAGER ROOM (SMR)	4.300 x 7.035	30.37*
5	U05.1	TICKET OFFICE (TOM)	2.500 x 14.34	34.80*
6	U05.2	TICKET OFFICE (TOM)	2.500 x 14.34	34.80*
7	U07.1	EXCESS FARE OFFICE (EFO)	2.500 x 3.000	7.50
8	U07.2	EXCESS FARE OFFICE (EFO)	2.500 x 3.000	7.50
9	U09	SECURITY ROOM	1.700x2.000	3.40
10	U10	STATION STORE ROOM	7.100 x 5.280	37.35
11	U12	CLEANER'S ROOM	1.700 x 2.000	3.40
12	U14	STAFF TOILET	1.700 x 2.475	4.21
13	U15.1	PUBLIC TOILETS (Male)	5.850 x 4.675	27.32
14	U15.2	PUBLIC TOILETS (Female)	4.100 x 5.550	22.90*
15	U16	MESS ROOM	5.280 x 6.100	32.21
16	U18.1	DR ROOM	8.100 x 7.065	53.74*
17	U18.2	DR ROOM	6.000 x 7.065	41.24*
18	U19.1	ECS PLANT ROOM (ECS)	50.350 x 20.740	803.05*
19	U19.2	ECS PLANT ROOM (ECS)	53.300 x 20.740	804.05*
20	U22	SIGNALLING EQUIPMENT ROOM (SER)	6.820 x 10.715	72.80*
21	U23	TELECOM EQUIPMENT ROOM (TER)	5.000 x 10.715	53.58
22	U24	UPS ROOM for S&T	4.400 x 10.715	46.72*
23	U46	HANDICAP TOILET	1.750 x 2.250	3.94
24	U47	PD AREA	32.25 x 20.00	637.28*

* AS PER POLY LINE

ECS SCHEDULE				
OUT NUMBER	PURPOSE	SIZE (M)	AREA(SqM)	OUTPUT POSITION
S2	FRESH AIR - 2ND.	SHAFT	2.5X2.0	5.0
S2a	FRESH AIR - 1ND.	SHAFT	2.5X4.0	10.0
S3	EXHAUST AIR - 2ND.	SHAFT	3.0X3.0	9.0
S10	UPE OUT- 4 NO.		1.4X1.0	1.40 FLOOR
S11	O.T.E OUT-4ND.		1.2X1.7	2.04 FLOOR
S12	SUPPLY AIR DUCT TO PLATFORM-4ND.		1.3X1.1	1.43 FLOOR
S13	OUT OUT DUCT FOR DUMP. TO PLATFORM-2ND.		3.7X1.1	4.07 FLOOR

TVS SCHEDULE				
OUT NUMBER	PURPOSE	SIZE (M)	AREA(SqM)	OUTPUT POSITION
TVS-1	TUNNEL VENTILATION CUTOUT 2 NO	4.5X4.5	20.25	FLOOR
	TUNNEL VENTILATION SHAFT 2 NO	5.5X5.5	25.25	-

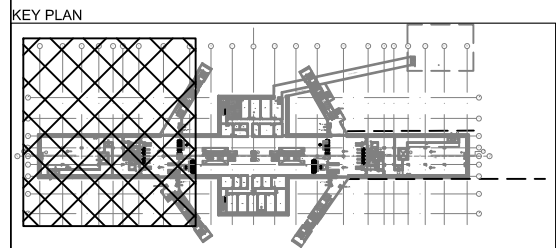

GENERAL NOTES:

1. ALL DIMENSIONS ARE IN MILLIMETERS.
2. ALL DIMENSIONS ARE TO BE READ AND NOT MEASURED.
3. ANY DISCREPANCIES MUST BE BROUGHT TO THE NOTICE OF THE DMRC BEFORE EXECUTION OF THE WORK AT SITE.
4. THIS DRAWING MUST BE READ IN CONJUNCTION WITH ALL RELEVANT ARCHITECTURAL, STRUCTURAL, PLUMBING & FIRE FIGHTING, ELECTRICAL AND TRAFFIC MANAGEMENT DRAWINGS.
5. ALL DOOR/WINDOW CILL & LINTEL LEVELS ARE MEASURED FROM MAIN FLOOR FINISHED LEVELS.

REFERENCE DRAWINGS

Drp. No.	Description

REVISIONS

REV	PARTICULARS	DRN.	CHD.	VER.	DATE	ISSUE DATE	REV. FOR CONSTRUCTION

APPROVAL BY DMRC

DMRC APPROVAL	MGR/ARCH	DY CA (UG)-III	CA/ARCH
DY CSTE/TELECOM	CSTE-I	DY CE/DESIGN	CE/TECH
DY CSTE/AFC		ED/S&T	CSO
DY CSTE/SIGNALLING	CSTE-III	GMO	GMM
DY CE/PLANNING	DY CEE/E&M	DY CEE/ECS	ED/ELEC-II
DY CEE(E)/UG-TR	CGM(E) UG-TR	PM	CPM

Certified that this document has been designed and checked in accordance with DDC Quality Assurance Plan.

Authorised Signatory for DDC.
JP/EW/1B/DDC01 Project Manager

Architecture Design In-charge/ Coordinator
Structure Design In-charge/ Coordinator
E&M Design In-charge/ Coordinator

DETAIL DESIGN CONSULTANT (DDC) FOR CIVIL, ARCHITECTURAL & BUILDING WORKS OF TWO UNDERGROUND STATION (CHOTI CHOUPAR & BADI CHOUPAR), SHAFT AND TUNNELS OF PHASE 1B OF JAIPUR METRO

ayesa Engineering, Information, Imagination.
56, Indo-Asia House, Institutional Area, sector-44 Gurgaon - 122002 (Haryana)

DELHI METRO RAIL CORPORATION LTD.
Metro Bhawan, Fire Brigade Lane, Barakhamba Road, New Delhi-110001

PHASE 1B JAIPUR METRO PROJECT

STATION: CHOTI CHOUPAR


DRAWING TITLE: ECS/TVS LAYOUT CONCOURSE LEVEL

DRAWN BY: ADIL
CHECKED BY: NITIN
VERIFIED BY: L.R.S

DATE: 31-03-2015
REV: R0
GRAPHICAL SCALE: 1:150
STATUS: FOR TENDER

DRAWING NUMBER: JP-TD-ECS/TVS-10CC-1301
SHEET NO. 1 OF 3
SHEET SIZE UNE A1
ORDER N° P36-0017

This drawing must not be either loaned, copied or otherwise reproduced in whole or in part or used for any purpose without the prior written permission of DMRC.

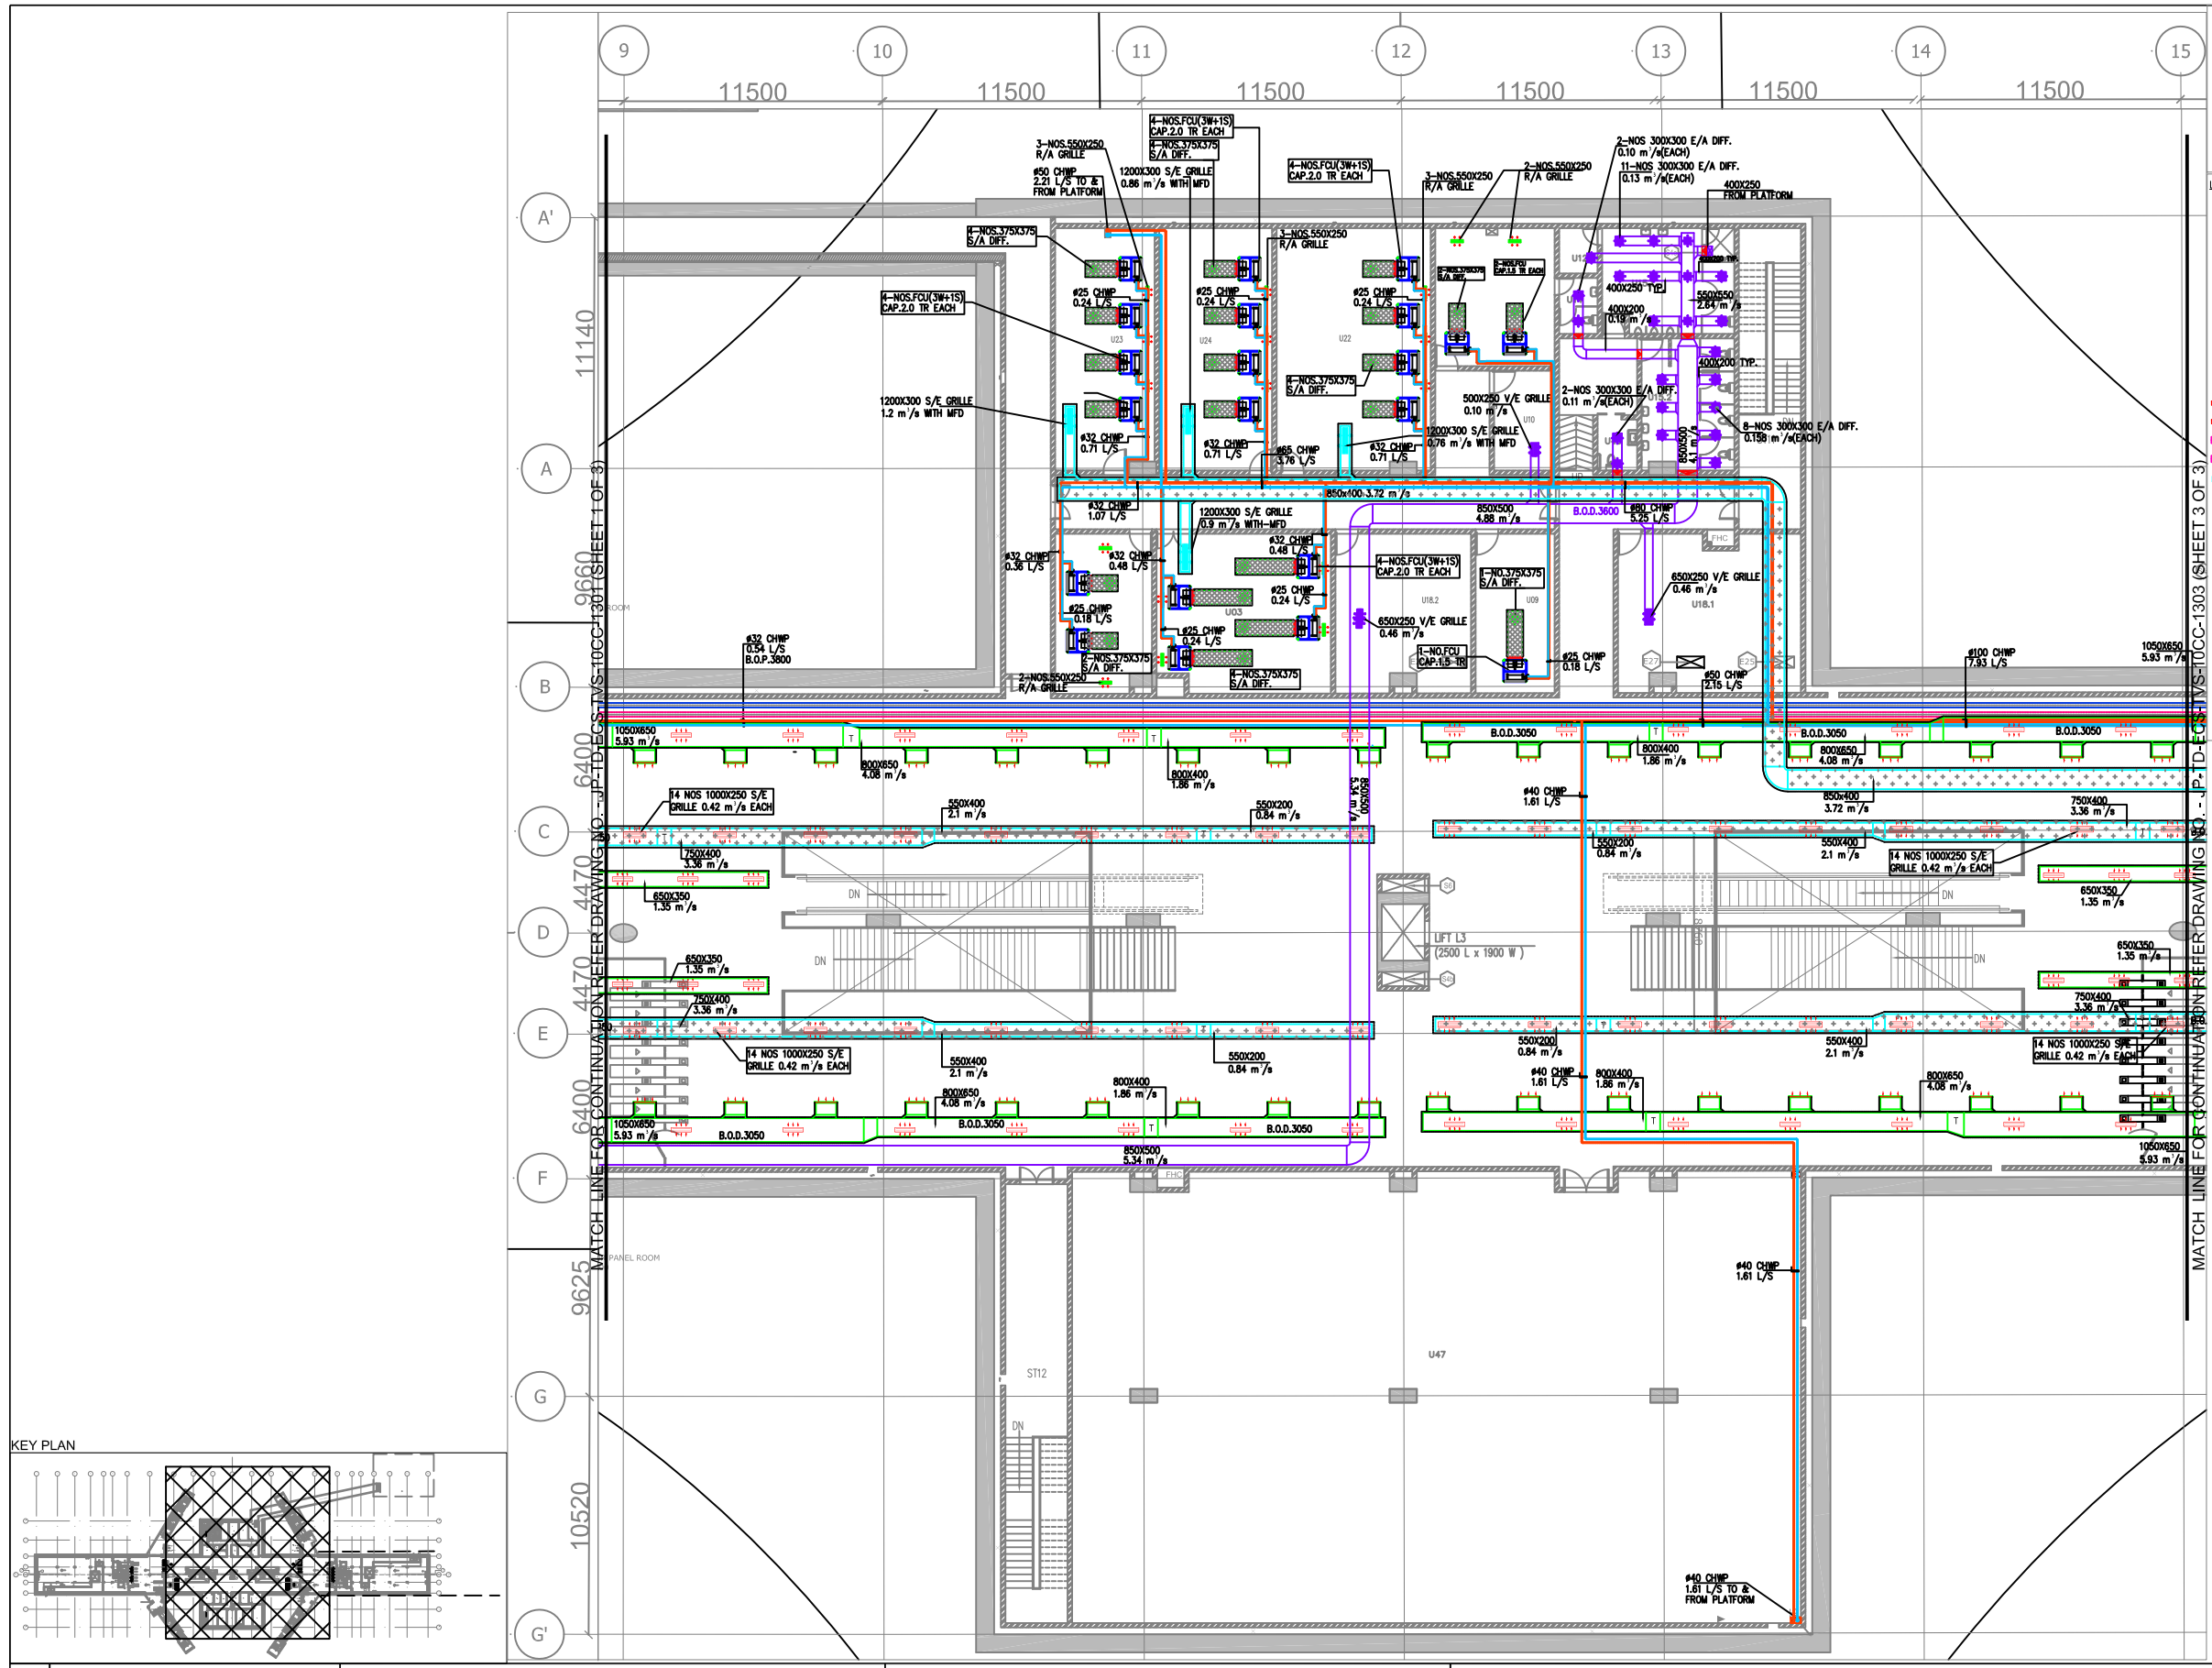

NOTES:-

1. ALL DIMENSIONS ARE IN MM. UNLESS OTHERWISE SPECIFIED.
2. ALL SUPPLY AND RETURN AIR DUCTING INSULATED WITH 25mm. THK. FIBREGLASS INSULATION IN A/C AREA.
3. ALL SUPPLY AND RETURN AIR DUCTING INSULATED WITH 50mm. THK. FIBREGLASS INSULATION IN NON-A/C AREA.
4. ALL CHILLED WATER PIPING INSULATED AS PER SPECIFICATION.
5. ALL LEVELS OF DUCTS AND PIPES ARE FROM FINISHED FLOOR LEVELS.
6. FOR ECS RELATED ELECTRICAL PLEASE REFER ECS ELECTRICAL LAYOUT.

LEGEND

- CHW SUPPLY PIPE
- CHW RETURN PIPE
- CHW SUPPLY PIPE(AIR COOLED CHILLER)
- CHW RETURN PIPE(AIR COOLED CHILLER)
- CDW SUPPLY PIPE
- CDW RETURN PIPE
- EQUALIZER HEADER
- MAKEUP HEADER
- DRAIN&OVERFLOW HEADER
- VENTILATION SUPPLY DUCT
- VENTILATION EXHAUST DUCT
- MOTORISED OPERATED DAMPER
- VOLUME CONTROL DAMPER
- MOTORISED FIRE DAMPER
- FIRE RATED MANUAL DAMPER
- MANUAL DAMPER
- RETURN AIR DUCT FIRE RATED
- SUPPLY AIR DUCT
- VENTILATION SUPPLY AIR DUCT
- VENTILATION EXHAUST AIR DUCT
- STAIRCASE PRESSURIZATION DUCT
- SMOKE EXHAUST DUCT
- SUPPLY AIR GRILLE
- EXHAUST/SMOKE EXHAUST GRILLE
- UNDER PLATFORM EXHAUST GRILLE

ABBREVIATIONS

- CC CHOTI CHOUPAR STATION
- AHU Air Handling Unit
- FAF Fresh Air Fan
- FCU Fan Coil Unit
- MD Motorised Damper
- MFD Motorised Fire Damper
- MOD Motor Operated Damper
- OTE Over Track Exhaust
- R.A.G. Return Air Grille
- S.A.G. Supply Air Grille
- F.A.G. Fresh Air Grille
- TEF Track Way Exhaust Fan
- UPE Under Platform Exhaust
- VCD Volume Control Damper (Non fire rated)
- VEF Ventilation Exhaust Fan
- VSF Ventilation Supply Fan
- B.O.D. Bottom of Duct
- CHWP CHILLED WATER PIPE
- CDWP CONDENSER WATER PIPE
- VSD VENTILATION SUPPLY DUCT
- VED VENTILATION EXHAUST DUCT

LEGEND


- AIR HANDLING UNIT FLOOR MOUNTED
- FAN COIL UNIT
- TRACK WAY EXHAUST FAN
- AXIAL FAN
- PROPELLER FAN
- TUNNEL VENTILATION FAN

ROOM SCHEDULE				
S.NO.	ROOM SCHEDULE	ROOM NAME	DIMENSION (M)	AREA (Sq.m)
1	U01	UNPAID AREA		1035.90
2	U02	PAID AREA		1487.75
3	U03	STATION CONTROL ROOM (SCR)	7.700 x 7.050	54.29
4	U04	STATION MANAGER ROOM (SMR)	4.300 x 7.035	30.37
5	U05.1	TICKET OFFICE (TOM)	2.500 x 14.34	34.80
6	U05.2	TICKET OFFICE (TOM)	2.500 x 14.34	34.80
7	U07.1	EXCESS FARE OFFICE (EFO)	2.500 x 3.000	7.50
8	U07.2	EXCESS FARE OFFICE (EFO)	2.500 x 3.000	7.50
9	U09	SECURITY ROOM	1.700x2.000	3.40
10	U10	STATION STORE ROOM	7.100 x 5.280	37.35
11	U12	CLEANER'S ROOM	1.700 x 2.000	3.40
12	U14	STAFF TOILET	1.700 x 2.475	4.21
13	U15.1	PUBLIC TOILETS (Male)	5.850 x 4.675	27.32
14	U15.2	PUBLIC TOILETS (Female)	4.100 x 5.550	22.90
15	U16	MESS ROOM	5.280 x 6.100	32.21
16	U18.1	DB ROOM	8.100 x 7.085	57.39
17	U18.2	DB ROOM	6.000 x 7.085	42.51
18	U19.1	ECS PLANT ROOM (ECS)	50.350 x 20.740	803.05
19	U19.2	ECS PLANT ROOM (ECS)	53.300 x 20.740	804.05
20	U22	SIGNALLING EQUIPMENT ROOM (SER)	6.820 x 10.715	72.80
21	U23	TELECOM EQUIPMENT ROOM (TER)	5.000 x 10.715	53.58
22	U24	UPS ROOM for S&T	4.400 x 10.715	46.72
23	U46	HANDICAP TOILET	1.750 x 2.250	3.94
24	U47	PD AREA	32.25 x 20.00	637.28


* AS PER POLY LINE

ECS SCHEDULE				
OUT OUT NUMBER	PURPOSE	SIZE (M)	AREA(SqM)	OUTPUT POSITION
S2	FRESH AIR - 2ND	2.5X2.0	5.0	-
S2a	FRESH AIR - 1ND	2.5X4.0	10.0	-
S3	EXHAUST AIR - 2ND	3.0X3.0	9.0	-
S10	UPE OUT - 4 NO.	1.4X1.0	1.40	FLOOR
S11	O.T.E OUT -4ND	1.2X1.7	2.04	FLOOR
S12	SUPPLY AIR DUCT TO PLATFORM -4ND	1.3X1.1	1.43	FLOOR
S13	OUT OUT DUCT FOR DUMP. TO PLATFORM-2ND	3.7X1.1	4.07	FLOOR

TVS SCHEDULE				
OUT OUT NUMBER	PURPOSE	SIZE (M)	AREA(SqM)	OUTPUT POSITION
TVS-1	TUNNEL VENTILATION OUTPUT 2 NO	4.5X4.5	20.25	FLOOR
	TUNNEL VENTILATION SHAFT 2 NO	5.5X5.5	25.25	-

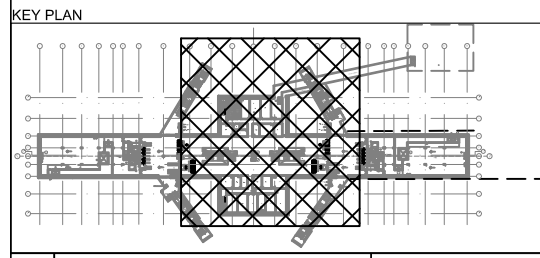

GENERAL NOTES: 1. ALL DIMENSIONS ARE IN MILLIMETERS. 2. ALL DIMENSIONS ARE TO BE READ AND NOT MEASURED. 3. ANY DISCREPANCIES MUST BE BROUGHT TO THE NOTICE OF THE DMRC BEFORE EXECUTION OF THE WORK AT SITE. 4. THIS DRAWING MUST BE READ IN CONJUNCTION WITH ALL RELEVANT ARCHITECTURAL, STRUCTURAL, PLUMBING & FIRE FIGHTING, ELECTRICAL AND TRAFFIC MANAGEMENT DRAWINGS. 5. ALL DOOR/WINDOW CILL & LINTEL LEVELS ARE MEASURED FROM MAIN FLOOR FINISHED LEVELS. REFERENCE DRAWINGS <table><tr><th>Drp. No.</th><th>Description</th></tr><tr><td></td><td></td></tr></table>	Drp. No.	Description			REVISIONS <table><tr><th>REV</th><th>PARTICULARS</th><th>DRN.</th><th>CHD.</th><th>VER.</th><th>DATE</th><th>ISSUE DATE</th><th>REV. FOR CONSTRUCTION</th></tr><tr><td></td><td></td><td></td><td></td><td></td><td></td><td></td><td></td></tr></table>	REV	PARTICULARS	DRN.	CHD.	VER.	DATE	ISSUE DATE	REV. FOR CONSTRUCTION									APPROVAL BY DMRC <table><tr><td>DMRC APPROVAL</td><td>MGR/ARCH</td><td>DY CA (UG)-III</td><td>CA/ARCH</td></tr><tr><td>DY CSTE/TELECOM</td><td rowspan="2">CSTE-I</td><td>DY CE/DESIGN</td><td>CE/TECH</td></tr><tr><td>DY CSTE/AFC</td><td>ED/S&T</td><td>CSO</td></tr><tr><td>DY CSTE/SIGNALLING</td><td>CSTE-III</td><td>GM/O</td><td>GMM</td></tr><tr><td>DY CE/PLANNING</td><td>DY CEE/E&M</td><td>DY CEE/ECS</td><td>ED/ELEC-II</td></tr><tr><td>DY CEE(E)/UG-TR</td><td>CGM(E) UG-TR</td><td>PM</td><td>CPM</td></tr></table>	DMRC APPROVAL	MGR/ARCH	DY CA (UG)-III	CA/ARCH	DY CSTE/TELECOM	CSTE-I	DY CE/DESIGN	CE/TECH	DY CSTE/AFC	ED/S&T	CSO	DY CSTE/SIGNALLING	CSTE-III	GM/O	GMM	DY CE/PLANNING	DY CEE/E&M	DY CEE/ECS	ED/ELEC-II	DY CEE(E)/UG-TR	CGM(E) UG-TR	PM	CPM	Certified that this document has been designed and checked in accordance with DDC Quality Assurance Plan. Architecture Design In-charge/ Coordinator Structure Design In-charge/ Coordinator E&M Design In-charge/ Coordinator Authorised Signatory for DDC. JP/EW/1B/DDC01 Project Manager DETAIL DESIGN CONSULTANT (DDC) FOR CIVIL, ARCHITECTURAL & BUILDING WORKS OF TWO UNDERGROUND STATION (CHOTI CHOUPAR & BADI CHOUPAR), SHAFT AND TUNNELS OF PHASE 1B OF JAIPUR METRO ayesa Engineering, Information, Imagination. 56, Indo-Asia House, Institutional Area, sector-44 Gurgaon - 122002 (Haryana)	DELHI METRO RAIL CORPORATION LTD. Metro Bhawan, Fire Brigade Lane, Barakhamba Road, New Delhi-110001 PHASE 1B JAIPUR METRO PROJECT STATION: CHOTI CHOUPAR DRAWING TITLE: ECS/TVS LAYOUT CONCOURSE LEVEL <table><tr><td>DRAWN BY: ADIL</td><td>CHECKED BY: NITIN</td><td>VERIFIED BY: L.R.S</td></tr><tr><td>DATE: 31-03-2015</td><td>REV: R0</td><td>GRAPHICAL SCALE: 1:150</td></tr><tr><td>DRAWING NUMBER: JP-TD-ECS/TVS-10CC-1302</td><td>SHEET NO. 2 OF 3</td><td>SHEET SIZE UNE A1</td></tr></table> STATUS: FOR TENDER ORDER N° P36-0017 JP/EW/1B/DDC01 ECSTVS	DRAWN BY: ADIL	CHECKED BY: NITIN	VERIFIED BY: L.R.S	DATE: 31-03-2015	REV: R0	GRAPHICAL SCALE: 1:150	DRAWING NUMBER: JP-TD-ECS/TVS-10CC-1302	SHEET NO. 2 OF 3	SHEET SIZE UNE A1	This drawing must not be either loaned, copied or otherwise reproduced in whole or in part or used for any purpose without the prior written permission of DMRC.
Drp. No.	Description																																																								
REV	PARTICULARS	DRN.	CHD.	VER.	DATE	ISSUE DATE	REV. FOR CONSTRUCTION																																																		
DMRC APPROVAL	MGR/ARCH	DY CA (UG)-III	CA/ARCH																																																						
DY CSTE/TELECOM	CSTE-I	DY CE/DESIGN	CE/TECH																																																						
DY CSTE/AFC		ED/S&T	CSO																																																						
DY CSTE/SIGNALLING	CSTE-III	GM/O	GMM																																																						
DY CE/PLANNING	DY CEE/E&M	DY CEE/ECS	ED/ELEC-II																																																						
DY CEE(E)/UG-TR	CGM(E) UG-TR	PM	CPM																																																						
DRAWN BY: ADIL	CHECKED BY: NITIN	VERIFIED BY: L.R.S																																																							
DATE: 31-03-2015	REV: R0	GRAPHICAL SCALE: 1:150																																																							
DRAWING NUMBER: JP-TD-ECS/TVS-10CC-1302	SHEET NO. 2 OF 3	SHEET SIZE UNE A1																																																							

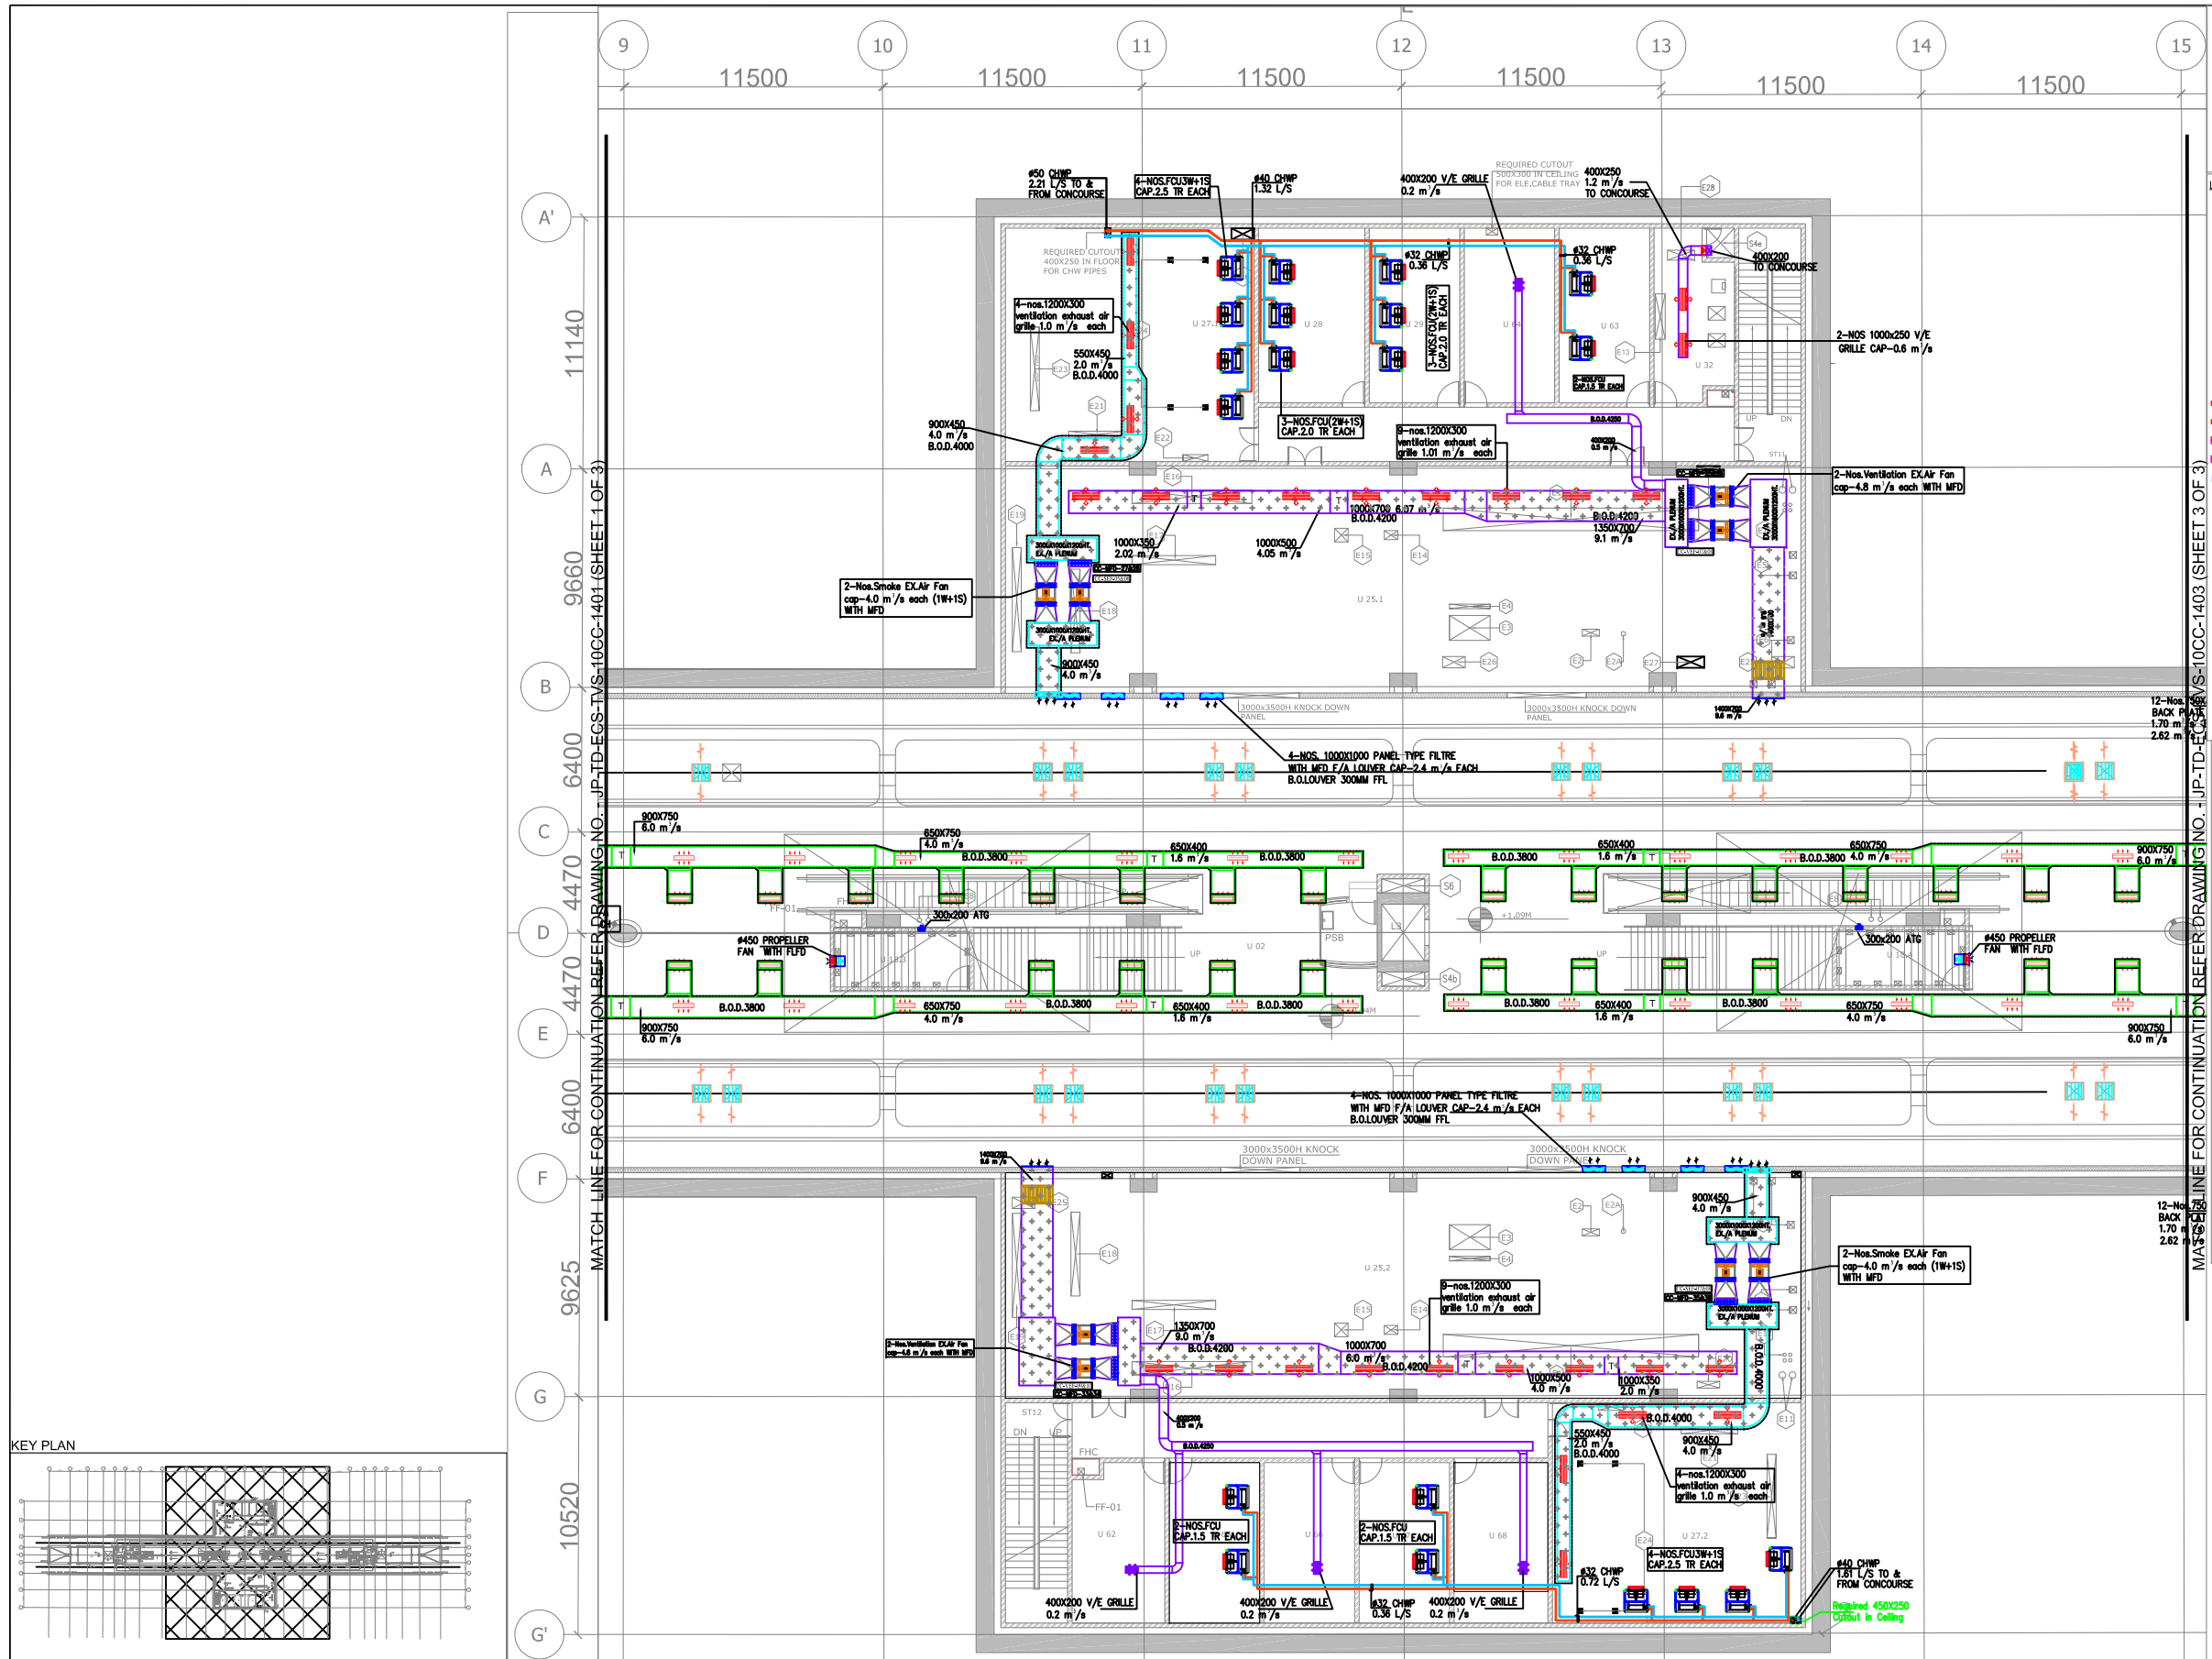

NOTES:-

- ALL DIMENSIONS ARE IN MM. UNLESS OTHERWISE SPECIFIED.
- ALL SUPPLY AND RETURN AIR DUCTING INSULATED WITH 25mm. THK. FIBREGLASS INSULATION IN A/C AREA.
- ALL SUPPLY AND RETURN AIR DUCTING INSULATED WITH 50mm. THK. FIBREGLASS INSULATION IN NON-A/C AREA.
- ALL CHILLED WATER PIPING INSULATED AS PER SPECIFICATION.
- ALL LEVELS OF DUCTS AND PIPES ARE FROM FINISHED FLOOR LEVELS.
- FOR ECS RELATED ELECTRICAL PLEASE REFER ECS ELECTRICAL LAYOUT.

LEGEND

- CHW SUPPLY PIPE
- CHW RETURN PIPE
- CHW SUPPLY PIPE(AIR COOLED CHILLER)
- CHW RETURN PIPE(AIR COOLED CHILLER)
- CDW SUPPLY PIPE
- CDW RETURN PIPE
- EQUALIZER HEADER
- MAKEUP HEADER
- DRAIN/OVERFLOW HEADER
- VENTILATION SUPPLY DUCT
- VENTILATION EXHAUST DUCT
- MOTORISED OPERATED DAMPER
- VOLUME CONTROL DAMPER
- MOTORISED FIRE DAMPER
- FIRE RATED MANUAL DAMPER
- MANUAL DAMPER
- RETURN AIR DUCT FIRE RATED
- SUPPLY AIR DUCT
- VENTILATION SUPPLY AIR DUCT
- VENTILATION EXHAUST AIR DUCT
- STAIRCASE PRESSURIZATION DUCT
- SMOKE EXHAUST DUCT
- SUPPLY AIR GRILLE
- EXHAUST/SMOKE EXHAUST GRILLE
- UNDER PLATFORM EXHAUST GRILLE

ABBREVIATIONS

CC CHOTI CHOUPAR STATION
AHU Air Handling Unit
FAH Fresh Air Fan
FCU Fan Coil Unit
MD Manual Damper
MFD Motorised Fire Damper
MOD Motor Operated Damper
OTE Over Track Exhaust
R.A.G. Return Air Grille
S.A.G. Supply Air Grille
F.A.G. Fresh Air Grille
TEF Track Way Exhaust Fan
UPE Under Platform Exhaust
VCD Volume Control Damper (Non fire rated)
VEF Ventilation Exhaust Fan
VSF Ventilation Supply Fan
B.O.D. Bottom of Duct
CHWP CHILLED WATER PIPE
CDWP CONDENSER WATER PIPE
VSD VENTILATION SUPPLY DUCT
VED VENTILATION EXHAUST DUCT

LEGEND

- AIR HANDLING UNIT FLOOR MOUNTED
- FAN COIL UNIT
- TRACK WAY EXHAUST FAN
- AXIAL FAN
- PROPELLER FAN
- TUNNEL VENTILATION FAN


ROOM SCHEDULE

S.NO.	ROOM SCHEDULE	ROOM NAME	DIMENSION (M.) (LxW)	AREA (Sq.m.)
1	U02	PAID AREA	3,960 x 3,960	15,68
2	U08	FIRST AID SPACE	3,960 x 3,960	15,68
3	U12	CLEANER'S ROOM 1	4,000 x 7,715	30,86
4	U13	REFUSE STORE 1	3,960 x 3,960	15,68
5	U18.3	DB ROOM	5,955 x 2,450	14,59
6	U18.4	DB ROOM	5,655 x 2,450	13,85
7	U25.1	AUXILIARY SUB STATION(AS1)	35,200 x 10,000	348,40*
8	U25.2	AUXILIARY SUB STATION(AS2)	35,200 x 10,000	356,80*
9	U27.1	ELECTRICAL UPS ROOM 1	11,000 x 10,300	112,83*
10	U27.2	ELECTRICAL UPS ROOM 2	11,000 x 9,750	107,25
11	U28	OSM ROOM	4,700 x 7,715	36,26
12	U29	OSM ROOM	4,000 x 7,715	30,86
13	U31.1	SEEPAGE ROOM 1	5,900 x 4,470	22,77*
14	U31.2	SEEPAGE ROOM 2	5,900 x 4,470	22,77*
15	U32	SEEPAGE ROOM	3,550 x 7,715	26,34*
16	U57.1	TUNNEL VENTILATION ROOM(TVS1)	14,800 x 9,140	133,67*
17	U57.2	TUNNEL VENTILATION ROOM(TVS2)	14,800 x 9,140	133,67*
18	PS8	PLATFORM SUPERVISOR BOOTH	2,550 x 2,650	6,76
19	U62	SPARE ROOM	4,000 x 7,100	28,06*
20	U63	E & M STAFF ROOM	4,000 x 7,715	30,86
21	U64	E & M STAFF ROOM	4,000 x 7,715	30,86
22	U65	L & E STAFF	4,000 x 7,100	28,40
23	U66	L & E STAFF	4,000 x 7,100	28,40
24	U67	TRACTION STAFF	4,000 x 7,100	28,40
25	U68	TRACTION STORE	4,150 x 7,100	29,47

* AS PER POLY LINE

ECS SCHEDULE

CUT OUT NUMBER	PURPOSE	SIZE (M)	AREA(Sq.M)	CUTOUT POSITION
S10	UPE CUT OUT	1,40X1,00	1,40	FLOOR

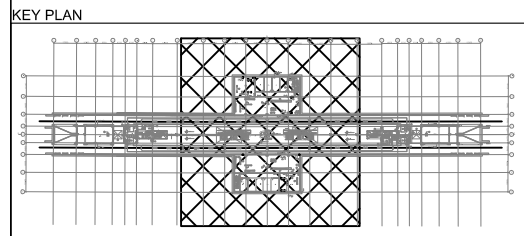

GENERAL NOTES:

- ALL DIMENSIONS ARE IN MILLIMETERS.
- ALL DIMENSIONS ARE TO BE READ AND NOT MEASURED.
- ANY DISCREPANCIES MUST BE BROUGHT TO THE NOTICE OF THE DMRC BEFORE EXECUTION OF THE WORK AT SITE.
- THIS DRAWING MUST BE READ IN CONJUNCTION WITH ALL RELEVANT ARCHITECTURAL, STRUCTURAL, PLUMBING & FIRE FIGHTING, ELECTRICAL AND TRAFFIC MANAGEMENT DRAWINGS.
- ALL DOOR/WINDOW CILL & LINTEL LEVELS ARE MEASURED FROM MAIN FLOOR FINISHED LEVELS.

REFERENCE DRAWINGS

Dwg. No.	Description

REVISIONS

REV	PARTICULARS	DRN.	CHD.	VER.	DATE	ISSUE DATE	REV. FOR CONSTRUCTION

APPROVAL BY DMRC

DMRC APPROVAL	MGR/ARCH	DY CA (UG)-III	CA/ARCH
DY CSTE/TELECOM	CSTE-I	DY CE/DESIGN	CE/TECH
DY CSTE/AFC		ED/IS&T	CSO
DY CSTE/SIGNALLING	CSTE-III	GM/O	GMM
DY CE/PLANNING	DY CEE/E&M	DY CEE/ECS	ED/ELEC-II
DY CEE(E)/UG-TR	CGME(E) UG-TR	PM	CPM

Certified that this document has been designed and checked in accordance with DDC Quality Assurance Plan.

Authorised Signatory for DDC.
JP/EW/1B/DDC01 Project Manager

Architecture Design In-charge/ Coordinator Structure Design In-charge/ Coordinator E&M Design In-charge/ Coordinator

DETAIL DESIGN CONSULTANT (DDC) FOR CIVIL, ARCHITECTURAL & BUILDING WORKS OF TWO UNDERGROUND STATION (CHOTI CHOUPAR & BADI CHOUPAR), SHAFT AND TUNNELS OF PHASE 1B OF JAIPUR METRO

ayesa Engineering, Information, Imagination.
56, Indo-Asia House, Institutional Area, sector-44 Gurgaon - 122002 (Haryana)

DELHI METRO RAIL CORPORATION LTD.
Metro Bhawan , Fire Brdgade Lane, Barakhamba Road, New Delhi-110001

PHASE 1B JAIPUR METRO PROJECT

STATION: CHOTI CHOUPAR

DRAWING TITLE: ECS/TVS LAYOUT PLATFORM LEVEL


DRAWN BY: ADIL **CHECKED BY:** NITIN **VERIFIED BY:** L.R.S

DATE: 31-03-2015 **REV:** R0 **GRAPHICAL SCALE:** 1:150 **STATUS:** FOR TENDER

DRAWING NUMBER: JP-TD-ECS/TVS-10CC-1402 **SHEET NO.** 2 OF 3 **SHEET SIZE** UNE A1 **ORDER N°** P36-0017

This drawing must not be either loaned, copied or otherwise reproduced in whole or in part or used for any purpose without the prior written permission of DMRC.

MATCH LINE FOR CONTINUATION REFER DRAWING NO. JP-TD-ECS-TVS-10CC-1402 (SHEET 2 OF 3)

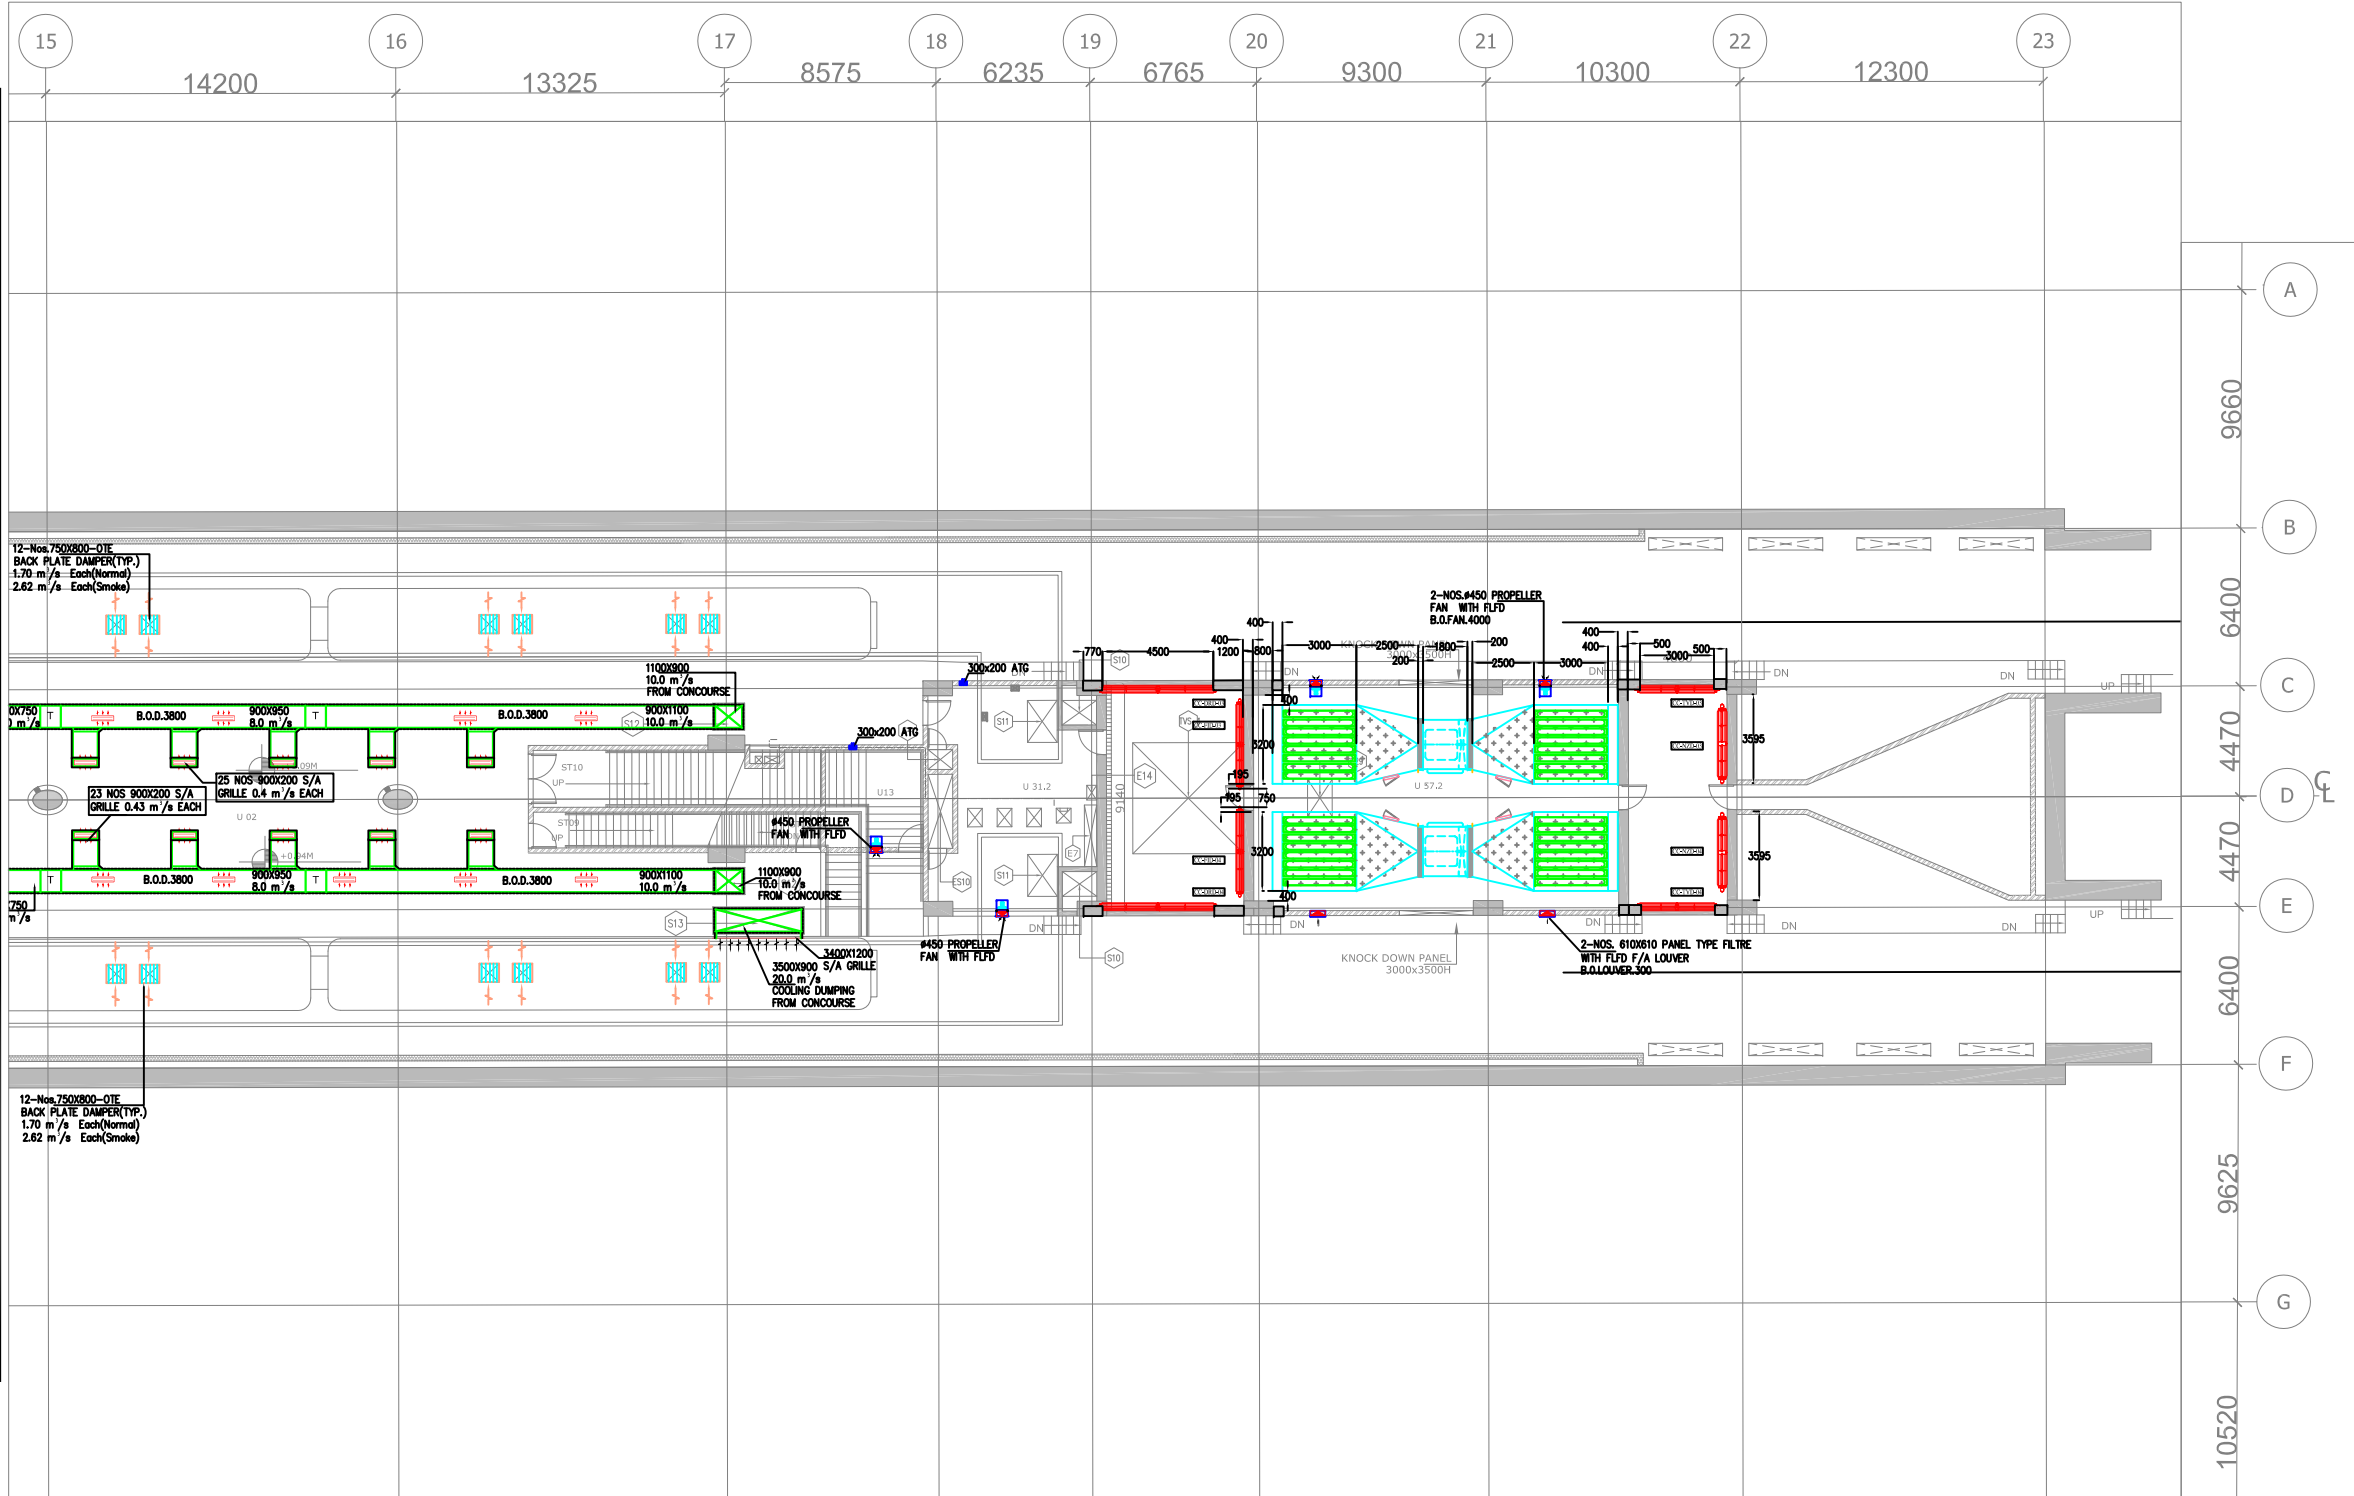

NOTES:-

- ALL DIMENSIONS ARE IN MM. UNLESS OTHERWISE SPECIFIED.
- ALL SUPPLY AND RETURN AIR DUCTING INSULATED WITH 25mm. THK. FIBREGLASS INSULATION IN A/C AREA.
- ALL SUPPLY AND RETURN AIR DUCTING INSULATED WITH 50mm. THK. FIBREGLASS INSULATION IN NON-A/C AREA.
- ALL CHILLED WATER PIPING INSULATED AS PER SPECIFICATION.
- ALL LEVELS OF DUCTS AND PIPES ARE FROM FINISHED FLOOR LEVELS.
- FOR ECS RELATED ELECTRICAL PLEASE REFER ECS ELECTRICAL LAYOUT.

LEGEND

- CHW SUPPLY PIPE
- CHW RETURN PIPE
- CHW SUPPLY PIPE(AIR COOLED CHILLER)
- CHW RETURN PIPE(AIR COOLED CHILLER)
- CDW SUPPLY PIPE
- CDW RETURN PIPE
- EQUALIZER HEADER
- MAKEUP HEADER
- DRAIN&OVERFLOW HEADER
- VENTILATION EXHAUST DUCT
- VENTILATION SUPPLY DUCT
- MOTORISED OPERATED DAMPER
- VOLUME CONTROL DAMPER
- MOTORISED FIRE DAMPER
- FIRE RATED MANUAL DAMPER
- MANUAL DAMPER
- RETURN AIR DUCT FIRE RATED
- SUPPLY AIR DUCT
- VENTILATION SUPPLY AIR DUCT
- VENTILATION EXHAUST AIR DUCT
- STAIRCASE PRESSURIZATION DUCT
- SMOKE EXHAUST DUCT
- SUPPLY AIR GRILLE
- EXHAUST/SMOKE EXHAUST GRILLE
- UNDER PLATFORM EXHAUST GRILLE

ABBREVIATIONS

CC CHOTI CHOUPAR STATION
AHU Air Handling Unit
FAF Fresh Air Fan
FCU Fan Coil Unit
MD Manual Damper
MFD Motorised Fire Damper
MOD Motor Operated Damper
OTE Over Track Exhaust
R.A.G Return Air Grille
S.A.G Supply Air Grille
F.A.G Fresh Air Grille
TEF Track Way Exhaust Fan
UPE Under Platform Exhaust
VCD Volume Control Damper (Non fire rated)
VEF Ventilation Exhaust Fan
VSF Ventilation Supply Fan
B.O.D. Bottom of Duct
CHWP CHILLED WATER PIPE
CDWP CONDENSER WATER PIPE
VSD VENTILATION SUPPLY DUCT
VED VENTILATION EXHAUST DUCT

LEGEND

AIR HANDLING UNIT FLOOR MOUNTED

FAN COIL UNIT

TRACK WAY EXHAUST FAN


AXIL FAN

PROPELLER FAN

TUNNEL VENTILATION FAN

ROOM SCHEDULE			
S.NO.	ROOM SCHEDULE	ROOM NAME	AREA (Sq.m.)
1	U02	PAID AREA	1362.05*
2	U08	FIRST AID SPACE	15.68
3	U12	CLEANER'S ROOM 1	30.86
4	U13	REFUSE STORE 1	15.68
5	U18.3	DB ROOM	14.59
6	U18.4	DB ROOM	13.85
7	U25.1	AUXILIARY SUB STATION(AS1)	348.40*
8	U25.2	AUXILIARY SUB STATION(AS2)	356.65*
9	U27.1	ELECTRICAL UPS ROOM 1	112.83*
10	U27.2	ELECTRICAL UPS ROOM 2	107.25
11	U28	OSM ROOM	36.26
12	U29	OSM ROOM	30.86
13	U31.1	SEEPAGE ROOM 1	22.77*
14	U31.2	SEEPAGE ROOM 2	22.77*
15	U32	SEWAGE ROOM	26.34*
16	U57.1	TUNNEL VENTILATION ROOM(TVS)1	133.67*
17	U57.2	TUNNEL VENTILATION ROOM(TVS)2	133.67*
18	PSB	PLATFORM SUPERVISOR BOOTH	6.76
19	U62	SPARE ROOM	28.06*
20	U63	E & M STAFF ROOM	30.86
21	U64	E & M STORE ROOM	30.86
22	U65	L & E STAFF	28.40
23	U66	L & E STORE	28.40
24	U67	TRACTION STAFF	28.40
25	U68	TRACTION STORE	29.47

ECS SCHEDULE			
CUT OUT NUMBER	PURPOSE	SIZE (M)	AREA(Sq.M)
S10	UPE CUT OUT	1.40X1.00	1.40

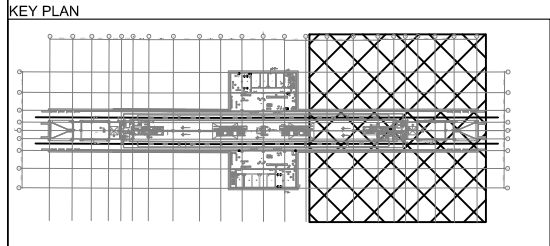

GENERAL NOTES:

- ALL DIMENSIONS ARE IN MILLIMETERS.
- ALL DIMENSIONS ARE TO BE READ AND NOT MEASURED.
- ANY DISCREPANCIES MUST BE BROUGHT TO THE NOTICE OF THE DMRC BEFORE EXECUTION OF THE WORK AT SITE.
- THIS DRAWING MUST BE READ IN CONJUNCTION WITH ALL RELEVANT ARCHITECTURAL, STRUCTURAL, PLUMBING & FIRE FIGHTING, ELECTRICAL AND TRAFFIC MANAGEMENT DRAWINGS.
- ALL DOOR/WINDOW CILL & LINTEL LEVELS ARE MEASURED FROM MAIN FLOOR FINISHED LEVELS.

REFERENCE DRAWINGS

Drp. No.	Description

REVISIONS

REV	PARTICULARS	DRN.	CHD.	VER.	DATE	ISSUE DATE	REV. FOR CONSTRUCTION

APPROVAL BY DMRC

DMRC APPROVAL	MGR/ARCH	DY CA (UG)-III	CA/ARCH
DY CSTE/TELECOM	CSTE-I	DY CE/DESIGN	CE/TECH
DY CSTE/AFC		ED/S&T	CSO
DY CSTE/SIGNALLING	CSTE-III	GM/O	GMM
DY CE/PLANNING	DY CEE/E&M	DY CEE/ECS	ED/ELEC-II
DY CEE(E)/UG-TR	CGM(E) UG-TR	PM	CPM

Certified that this document has been designed and checked in accordance with DDC Quality Assurance Plan.

Authorised Signatory for DDC.
JP/EW/1B/DDC01 Project Manager

Architecture	Structure	E&M
Design In-charge/ Coordinator	Design In-charge/ Coordinator	Design In-charge/ Coordinator

DETAIL DESIGN CONSULTANT (DDC) FOR CIVIL, ARCHITECTURAL & BUILDING WORKS OF TWO UNDERGROUND STATION (CHOTI CHOUPAR & BADI CHOUPAR), SHAFT AND TUNNELS OF PHASE 1B OF JAIPUR METRO

ayesa Engineering, Information, Imagination.
56, Indo-Asia House, Institutional Area, sector-44 Gurgaon - 122002 (Haryana)

DELHI METRO RAIL CORPORATION LTD.
Metro Bhawan , Fire Brgade Lane, Barakhamba Road, New Delhi-110001

PHASE 1B JAIPUR METRO PROJECT

STATION: CHOTI CHOUPAR


DRAWING TITLE: ECS/TVS LAYOUT PLATFORM LEVEL

DRAWN BY:	CHECKED BY:	VERIFIED BY:
ADIL	NITIN	L.R.S

DATE:	REV:	GRAPHICAL SCALE:	STATUS:
31-03-2015	R0	1:150	FOR TENDER

DRAWING NUMBER:	SHEET NO.	SHEET SIZE	ORDER N°
JP-TD-ECS/TVS-10CC-1403	3 OF 3	UNE A1	P36-0017

This drawing must not be either loaned, copied or otherwise reproduced in whole or in part or used for any purpose without the prior written permission of DMRC.

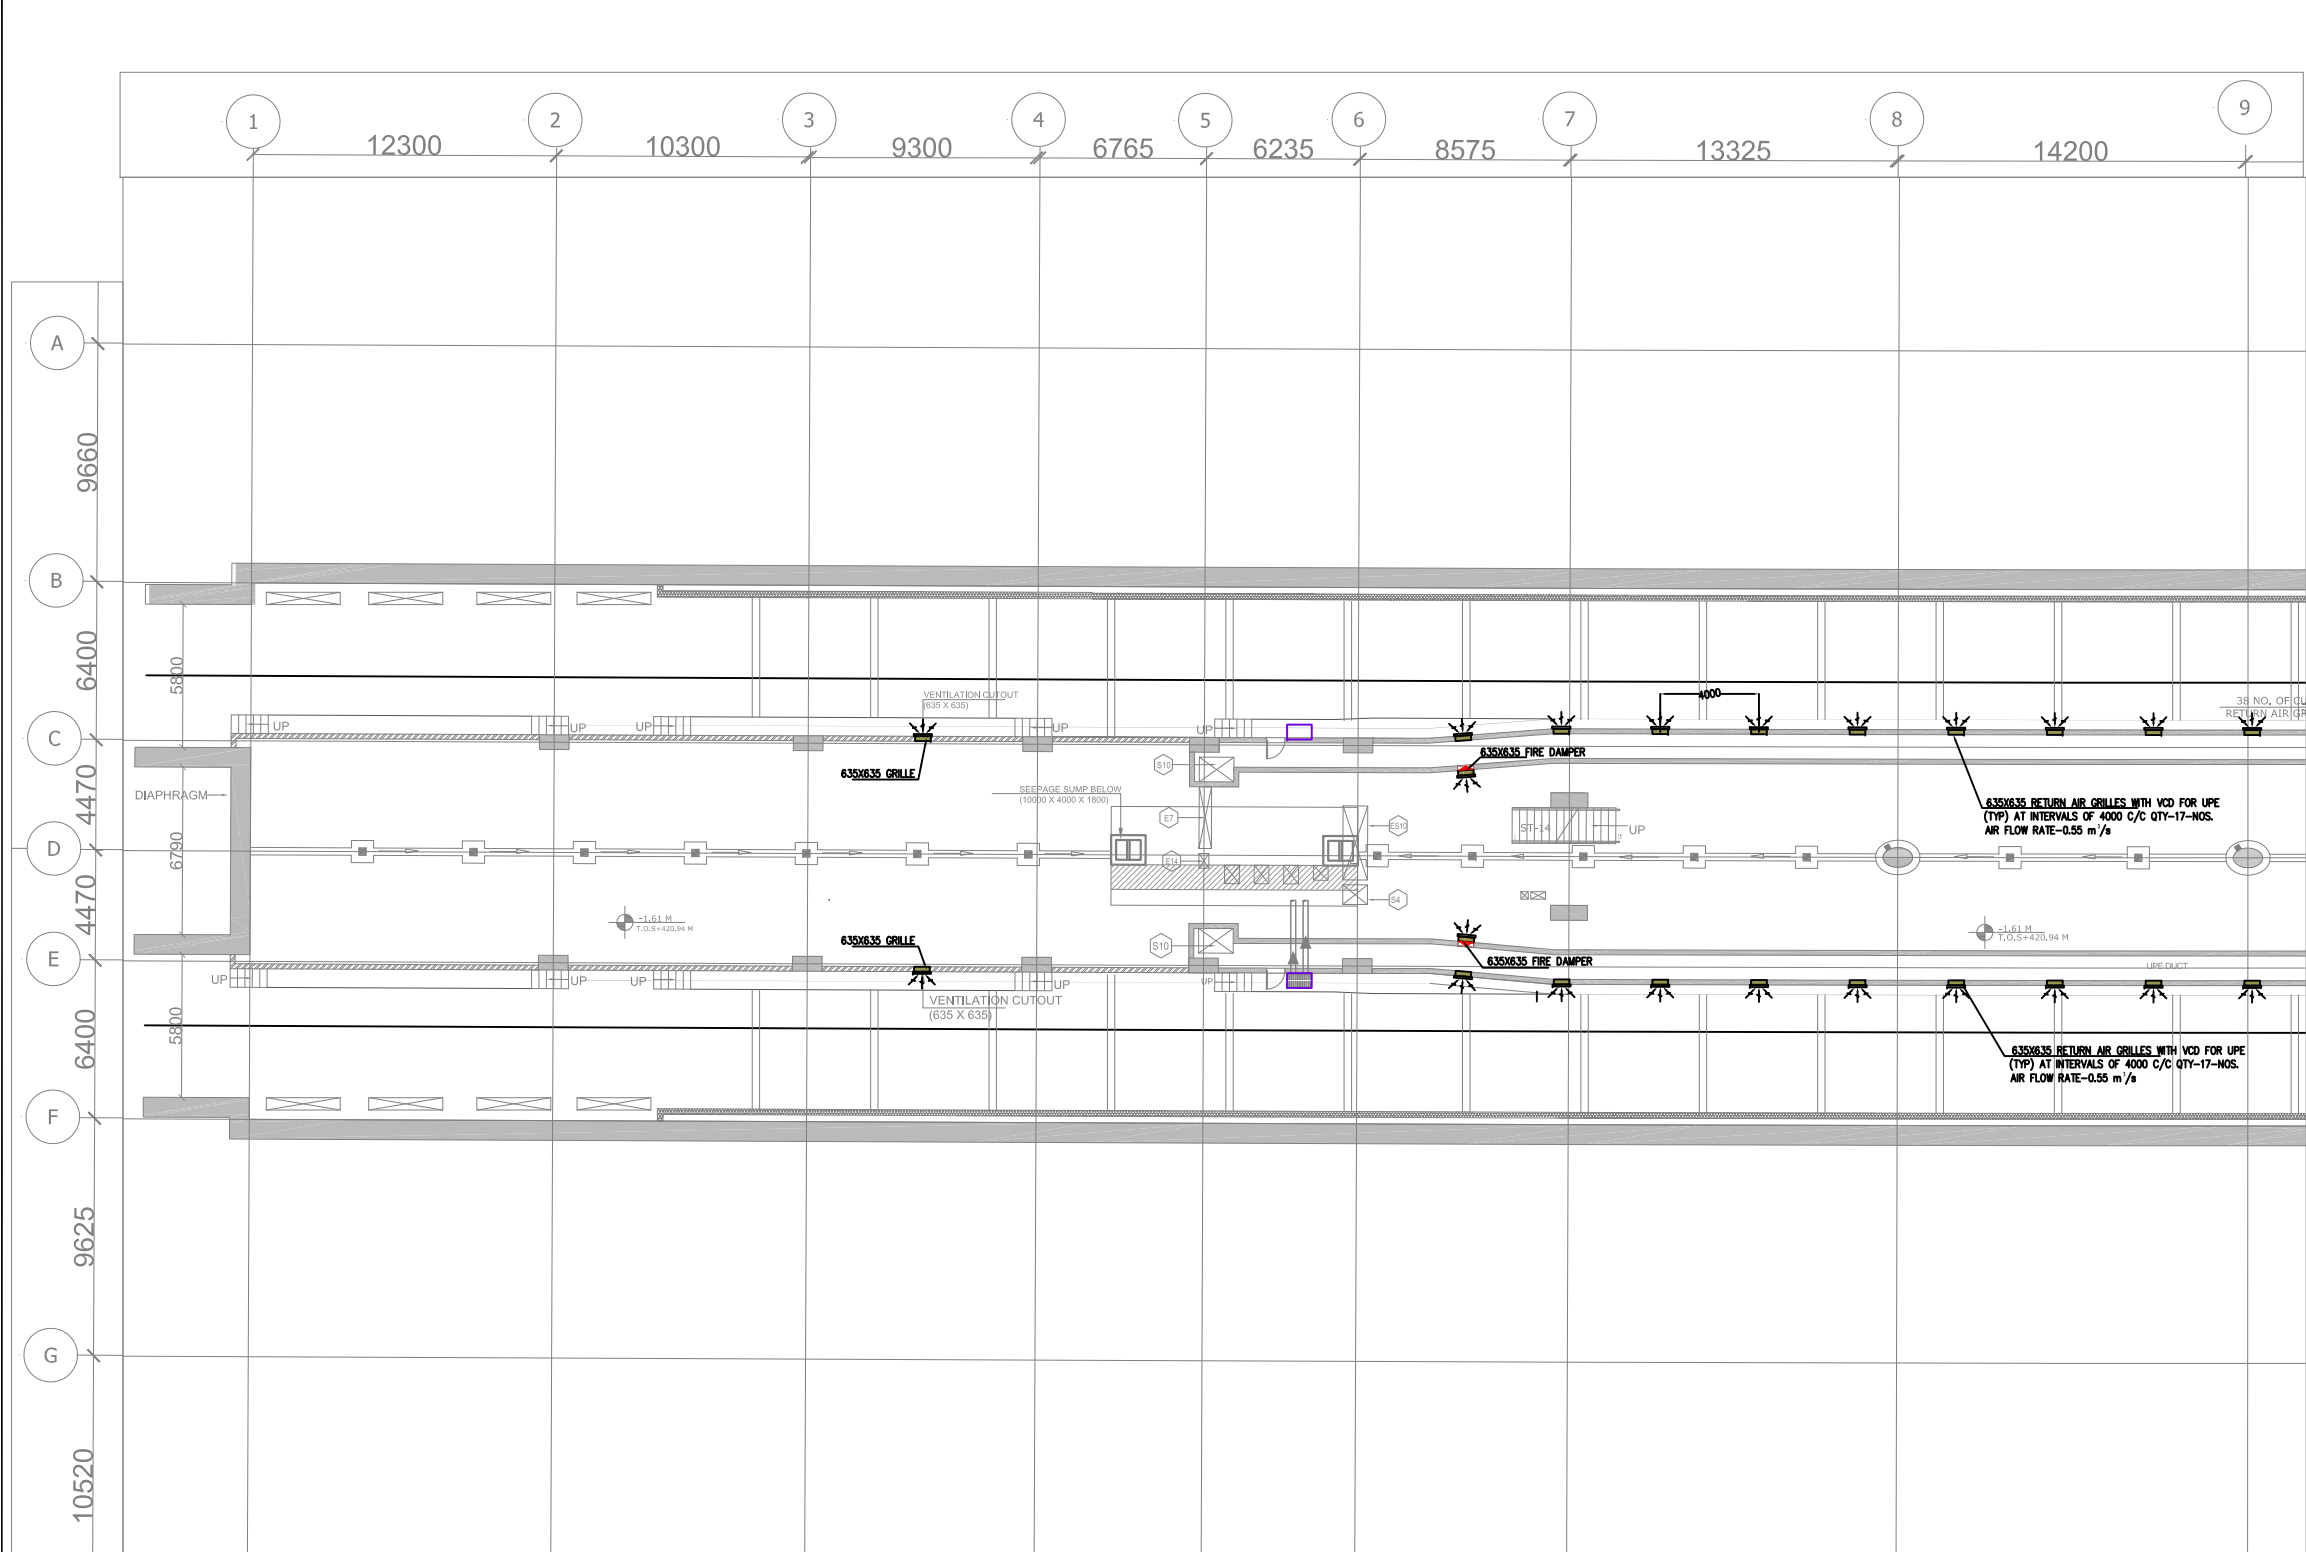

NOTES:-


1. ALL DIMENSIONS ARE IN MM. UNLESS OTHERWISE SPECIFIED.
2. ALL SUPPLY AND RETURN AIR DUCTING INSULATED WITH 25mm. THK. FIBREGLASS INSULATION IN A/C AREA.
3. ALL SUPPLY AND RETURN AIR DUCTING INSULATED WITH 50mm. THK. FIBREGLASS INSULATION IN NON-A/C AREA.
4. ALL CHILLED WATER PIPING INSULATED AS PER SPECIFICATION.
5. ALL LEVELS OF DUCTS AND PIPES ARE FROM FINISHED FLOOR LEVELS.
6. FOR ECS RELATED ELECTRICAL PLEASE REFER ECS ELECTRICAL LAYOUT.

ABBREVIATIONS


CC	CHOTI CHOUPAR STATION
AHU	Air Handling Unit
FAF	Fresh Air Fan
FCU	Fan Coil Unit
MD	Manual Damper
MFD	Motorised Fire Damper
MOD	Motor Operated Damper
OTE	Over Track Exhaust
R.A.G	Return Air Grille
S.A.G	Supply Air Grille
F.A.G	Fresh Air Grille
TEF	Track Way Exhaust Fan
UPE	Under Platform Exhaust
VCD	Volume Control Damper (Non fire rated)
VEF	Ventilation Exhaust Fan
VSF	Ventilation Supply Fan
B.O.D.	Bottom of Duct
CHWP	CHILLED WATER PIPE
CDWP	CONDENSER WATER PIPE
VSD	VENTILATION SUPPLY DUCT
VED	VENTILATION EXHAUST DUCT

LEGEND

CHW SUPPLY PIPE	CHW RETURN PIPE
CHW SUPPLY PIPE(AIR COOLED CHILLER)	CHW RETURN PIPE(AIR COOLED CHILLER)
CDW SUPPLY PIPE	CDW RETURN PIPE
EQUALIZER HEADER	MAKEUP HEADER
DRAIN/OVERFLOW HEADER	VENTILATION EXHAUST DUCT
VENTILATION SUPPLY DUCT	MOTORISED OPERATED DAMPER
VOLUME CONTROL DAMPER	MOTORISED FIRE DAMPER
MOTORISED FIRE DAMPER	FIRE RATED MANUAL DAMPER
MANUAL DAMPER	RETURN AIR DUCT FIRE RATED
SUPPLY AIR DUCT	VENTILATION SUPPLY AIR DUCT
VENTILATION EXHAUST AIR DUCT	STAIRCASE PRESSURIZATION DUCT
SMOKE EXHAUST DUCT	SUPPLY AIR GRILLE
EXHAUST/SMOKE EXHAUST GRILLE	UNDER PLATFORM EXHAUST GRILLE

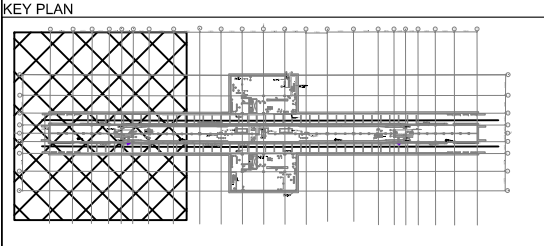

THIS DRAWING IS THE PROPERTY OF DELHI METRO RAIL CORPORATION LTD.	GENERAL NOTES: 1. ALL DIMENSIONS ARE IN MILLIMETERS. 2. ALL DIMENSIONS ARE TO BE READ AND NOT MEASURED. 3. ANY DISCREPANCIES MUST BE BROUGHT TO THE NOTICE OF THE DMRC BEFORE EXECUTION OF THE WORK AT SITE. 4. THIS DRAWING MUST BE READ IN CONJUNCTION WITH ALL RELEVANT ARCHITECTURAL, STRUCTURAL, PLUMBING & FIRE FIGHTING, ELECTRICAL AND TRAFFIC MANAGEMENT DRAWINGS. 5. ALL DOOR/WINDOW CILL & LINTEL LEVELS ARE MEASURED FROM MAIN FLOOR FINISHED LEVELS.	REVISIONS <table><thead><tr><th>REV</th><th>PARTICULARS</th><th>DRN.</th><th>CHD.</th><th>VER.</th><th>DATE</th><th>ISSUE DATE</th><th>REV. FOR CONSTRUCTION</th></tr></thead><tbody></tbody></table>						REV	PARTICULARS	DRN.	CHD.	VER.	DATE	ISSUE DATE	REV. FOR CONSTRUCTION	APPROVAL BY DMRC <table><thead><tr><th>DMRC APPROVAL</th><th>MGR/ARCH</th><th>DY CA (UG)-III</th><th>CA/ARCH</th></tr></thead><tbody><tr><td>DY CSTE/TELECOM</td><td rowspan="2">CSTE-I</td><td>DY CE/DESIGN</td><td>CE/TECH</td></tr><tr><td>DY CSTE/AFC</td><td>ED/S&T</td><td>CSO</td></tr><tr><td>DY CSTE/SIGNALLING</td><td>CSTE-II</td><td>GM/O</td><td>GMM</td></tr><tr><td>DY CE/PLANNING</td><td>DY CEE/E&M</td><td>DY CEE/ECS</td><td>ED/ELEC-II</td></tr><tr><td>DY CEE/(E)UG-TR</td><td>CGM(E) UG-TR</td><td>PM</td><td>CPM</td></tr></tbody></table>				DMRC APPROVAL	MGR/ARCH	DY CA (UG)-III	CA/ARCH	DY CSTE/TELECOM	CSTE-I	DY CE/DESIGN	CE/TECH	DY CSTE/AFC	ED/S&T	CSO	DY CSTE/SIGNALLING	CSTE-II	GM/O	GMM	DY CE/PLANNING	DY CEE/E&M	DY CEE/ECS	ED/ELEC-II	DY CEE/(E)UG-TR	CGM(E) UG-TR	PM	CPM	Certified that this document has been designed and checked in accordance with DDC Quality Assurance Plan. Authorised Signatory for DDC. JP/EW/1B/DDC01 Project Manager <table><tr><td>Architecture Design In-charge/ Coordinator</td><td>Structure Design In-charge/ Coordinator</td><td>E&M Design In-charge/ Coordinator</td></tr></table>			Architecture Design In-charge/ Coordinator	Structure Design In-charge/ Coordinator	E&M Design In-charge/ Coordinator	DELHI METRO RAIL CORPORATION LTD. Metro Bhawan , Fire Brigade Lane, Barakhamba Road, New Delhi-110001 PHASE 1B JAIPUR METRO PROJECT STATION: CHOTI CHOUPAR DRAWING TITLE: ECS/TVS LAYOUT UNDER CROFT LEVEL <table><tr><td>DRAWN BY: ADIL</td><td>CHECKED BY: NITIN</td><td>VERIFIED BY: L.R.S</td></tr><tr><td>DATE: 31-03-2015</td><td>REV: R0</td><td>GRAPHICAL SCALE: 1:150</td></tr><tr><td colspan="2">STATUS: FOR TENDER</td><td></td></tr><tr><td>DRAWING NUMBER: JP-TD-ECS/TVS-10CC-1501</td><td>SHEET NO. 1 OF 3</td><td>SHEET SIZE UNE A1</td></tr><tr><td colspan="2">ORDER N° P36-0017</td><td></td></tr></table> This drawing must not be either loaned, copied or otherwise reproduced in whole or in part or used for any purpose without the prior written permission of DMRC.			DRAWN BY: ADIL	CHECKED BY: NITIN	VERIFIED BY: L.R.S	DATE: 31-03-2015	REV: R0	GRAPHICAL SCALE: 1:150	STATUS: FOR TENDER			DRAWING NUMBER: JP-TD-ECS/TVS-10CC-1501	SHEET NO. 1 OF 3	SHEET SIZE UNE A1	ORDER N° P36-0017		
	REV	PARTICULARS	DRN.	CHD.	VER.	DATE	ISSUE DATE	REV. FOR CONSTRUCTION																																																										
	DMRC APPROVAL	MGR/ARCH	DY CA (UG)-III	CA/ARCH																																																														
	DY CSTE/TELECOM	CSTE-I	DY CE/DESIGN	CE/TECH																																																														
	DY CSTE/AFC		ED/S&T	CSO																																																														
DY CSTE/SIGNALLING	CSTE-II	GM/O	GMM																																																															
DY CE/PLANNING	DY CEE/E&M	DY CEE/ECS	ED/ELEC-II																																																															
DY CEE/(E)UG-TR	CGM(E) UG-TR	PM	CPM																																																															
Architecture Design In-charge/ Coordinator	Structure Design In-charge/ Coordinator	E&M Design In-charge/ Coordinator																																																																
DRAWN BY: ADIL	CHECKED BY: NITIN	VERIFIED BY: L.R.S																																																																
DATE: 31-03-2015	REV: R0	GRAPHICAL SCALE: 1:150																																																																
STATUS: FOR TENDER																																																																		
DRAWING NUMBER: JP-TD-ECS/TVS-10CC-1501	SHEET NO. 1 OF 3	SHEET SIZE UNE A1																																																																
ORDER N° P36-0017																																																																		
DETAIL DESIGN CONSULTANT (DDC) FOR CIVIL, ARCHITECTURAL & BUILDING WORKS OF TWO UNDERGROUND STATION (CHOTI CHOUPAR & BADI CHOUPAR), SHAFT AND TUNNELS OF PHASE 1B OF JAIPUR METRO																																																																		
ayesa Engineering, Information, Imagination. 56, Indo-Asia House, Institutional Area, sector-44 Gurgaon - 122002 (Haryana)																																																																		

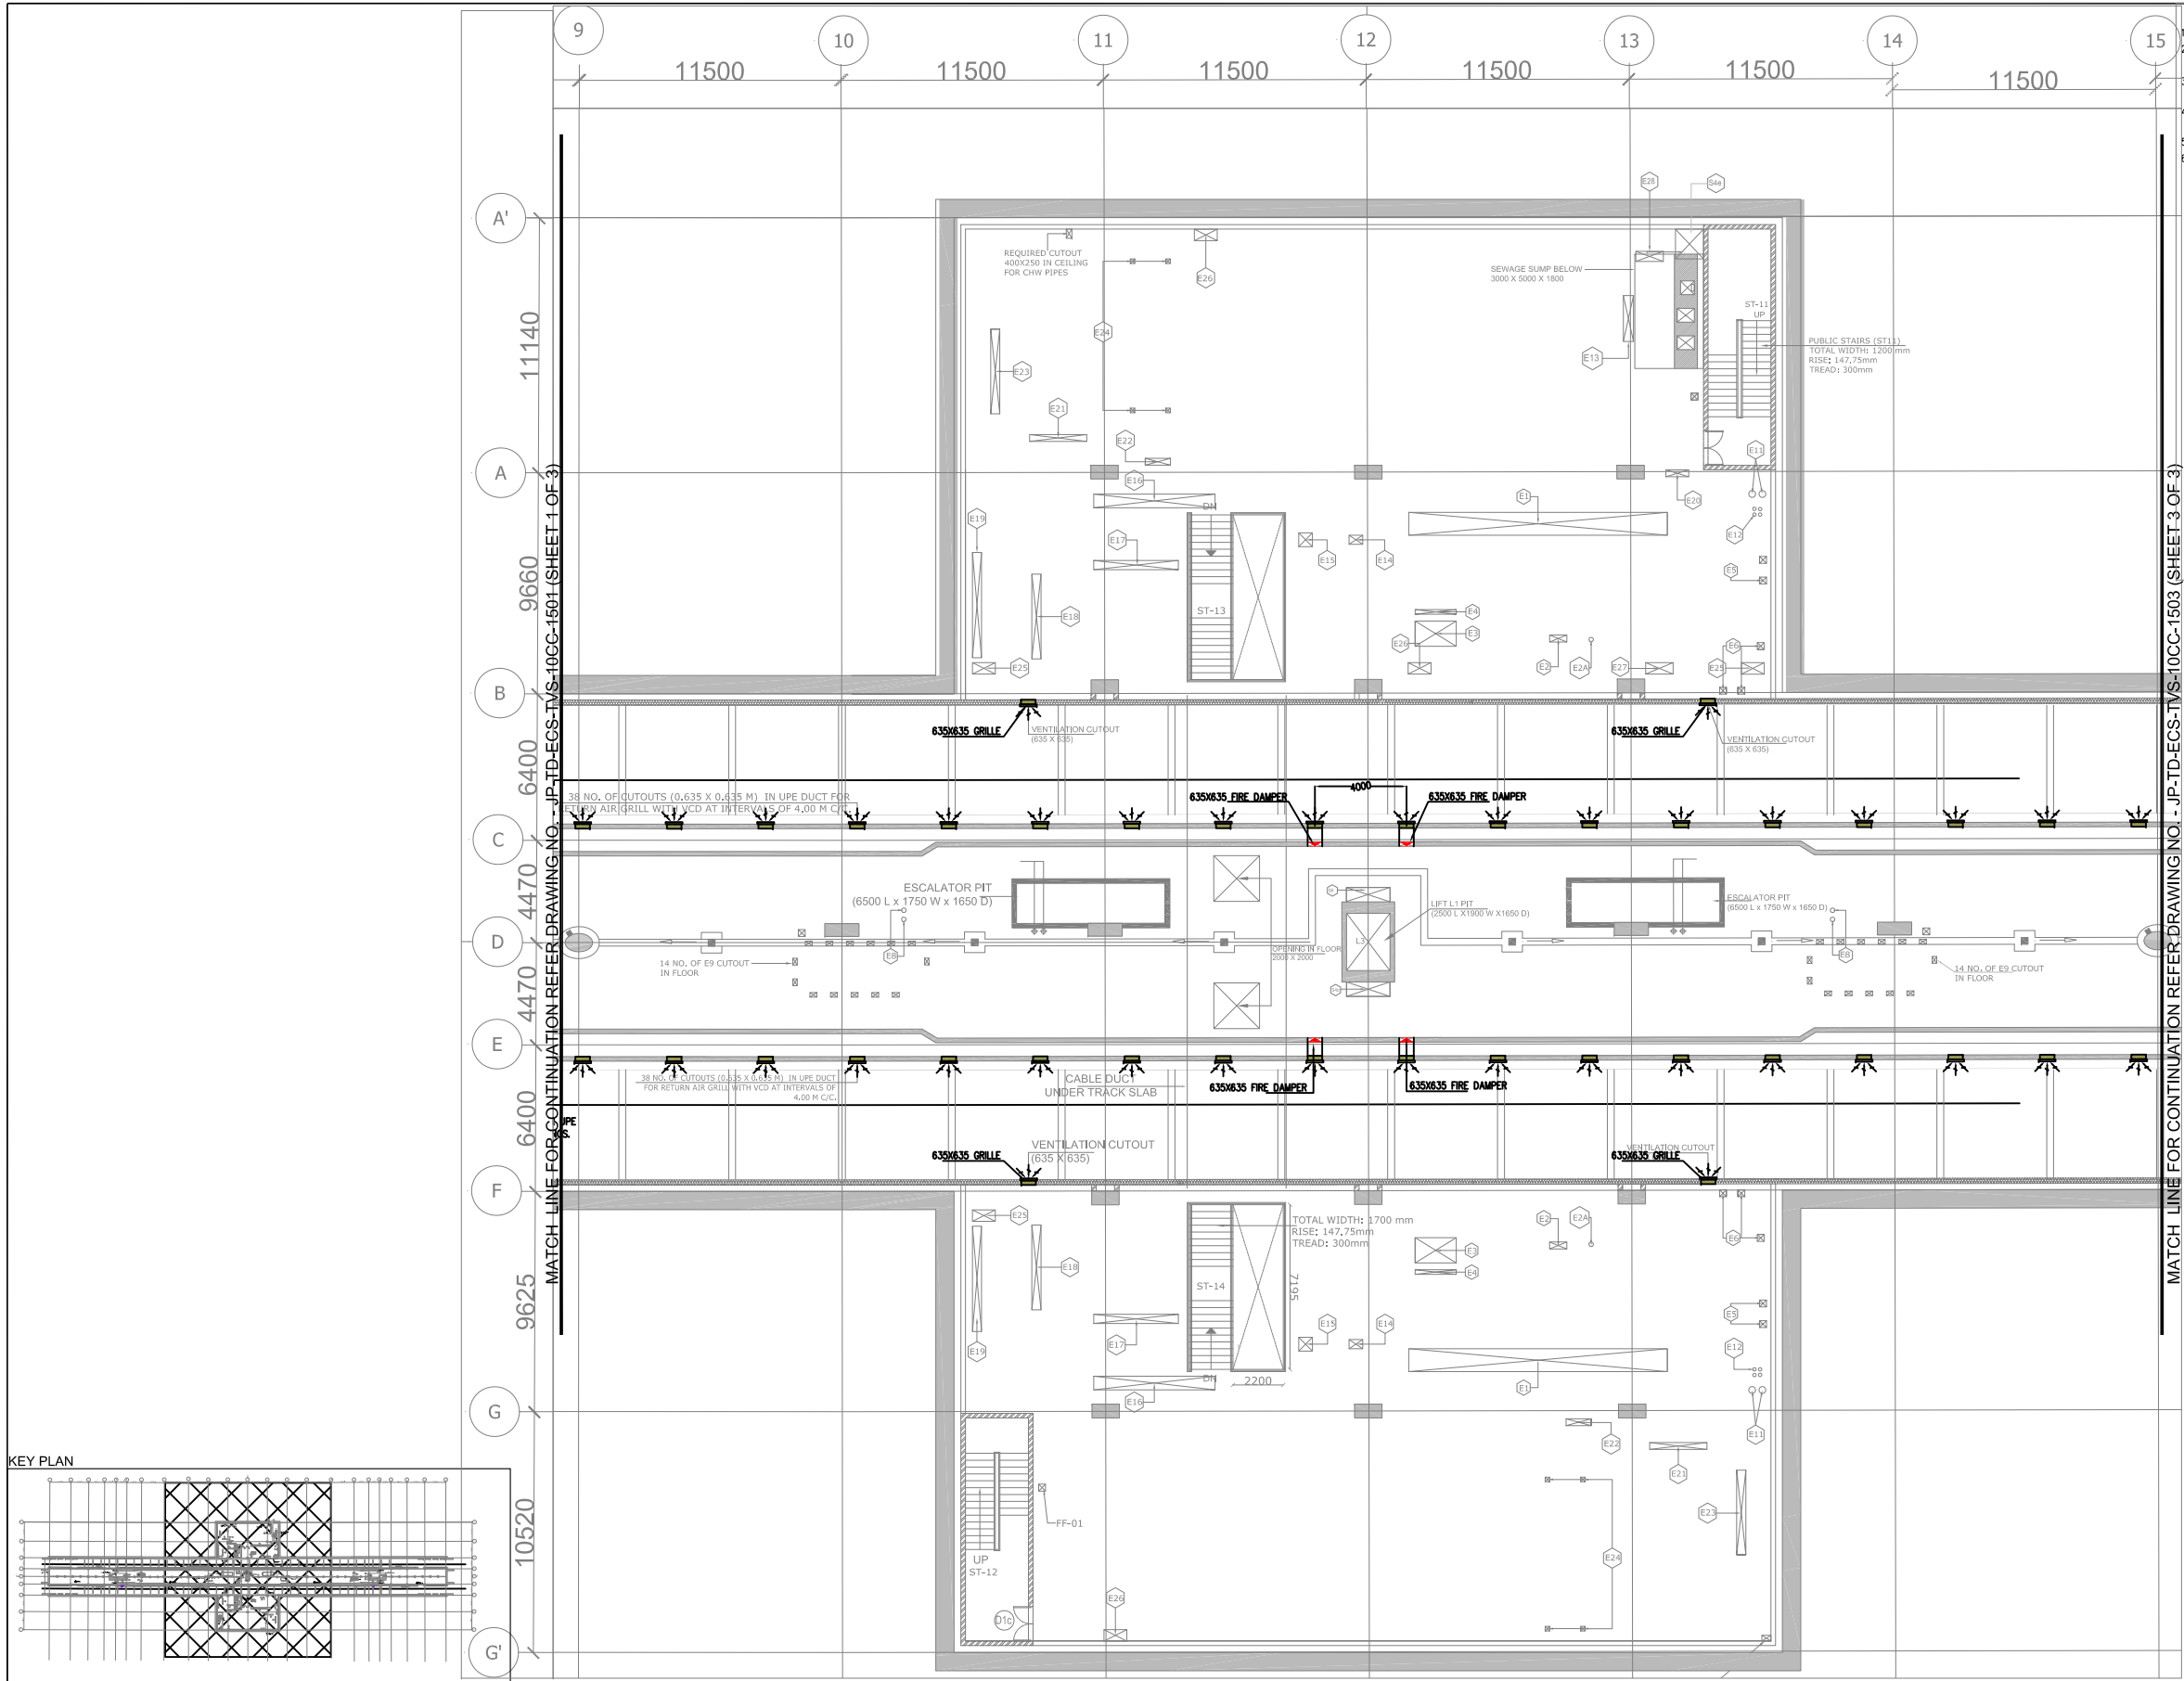

NOTES:-


- ALL DIMENSIONS ARE IN MM. UNLESS OTHERWISE SPECIFIED.
- ALL SUPPLY AND RETURN AIR DUCTING INSULATED WITH 25mm. THK. FIBREGLASS INSULATION IN A/C AREA.
- ALL SUPPLY AND RETURN AIR DUCTING INSULATED WITH 50mm. THK. FIBREGLASS INSULATION IN NON-A/C AREA.
- ALL CHILLED WATER PIPING INSULATED AS PER SPECIFICATION.
- ALL LEVELS OF DUCTS AND PIPES ARE FROM FINISHED FLOOR LEVELS.
- FOR ECS RELATED ELECTRICAL PLEASE REFER ECS ELECTRICAL LAYOUT.

ABBREVIATIONS

CC	CHOTI CHOUPAR STATION
AHU	Air Handling Unit
FAF	Fresh Air Fan
FCU	Fan Coil Unit
MD	Manual Damper
MFD	Motorised Fire Damper
MOD	Motor Operated Damper
OTE	Over Track Exhaust
R.A.G	Return Air Grille
S.A.G	Supply Air Grille
F.A.G	Fresh Air Grille
TEF	Track Way Exhaust Fan
UPE	Under Platform Exhaust
VCD	Volume Control Damper (Non fire rated)
VEF	Ventilation Exhaust Fan
VSF	Ventilation Supply Fan
B.O.D.	Bottom of Duct


LEGEND

CHW SUPPLY PIPE	CHW RETURN PIPE
CHW SUPPLY PIPE(AIR COOLED CHILLER)	CHW RETURN PIPE(AIR COOLED CHILLER)
CDW SUPPLY PIPE	CDW RETURN PIPE
EQUALIZER HEADER	MAKEUP HEADER
DRAIN/OVERFLOW HEADER	VENTILATION EXHAUST DUCT
VENTILATION SUPPLY DUCT	MOTORISED OPERATED DAMPER
VOLUME CONTROL DAMPER	MOTORISED FIRE DAMPER
FIRE RATED MANUAL DAMPER	MANUAL DAMPER
RETURN AIR DUCT FIRE RATED	SUPPLY AIR DUCT
VENTILATION SUPPLY AIR DUCT	VENTILATION EXHAUST AIR DUCT
STAIRCASE PRESSURIZATION DUCT	SMOKE EXHAUST DUCT
SUPPLY AIR GRILLE	EXHAUST/SMOKE EXHAUST GRILLE
UNDER PLATFORM EXHAUST GRILLE	

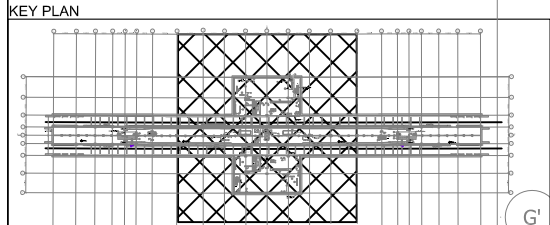

THIS DRAWING IS THE PROPERTY OF DELHI METRO RAIL CORPORATION LTD.	GENERAL NOTES: 1. ALL DIMENSIONS ARE IN MILLIMETERS. 2. ALL DIMENSIONS ARE TO BE READ AND NOT MEASURED. 3. ANY DISCREPANCIES MUST BE BROUGHT TO THE NOTICE OF THE DMRC BEFORE EXECUTION OF THE WORK AT SITE. 4. THIS DRAWING MUST BE READ IN CONJUNCTION WITH ALL RELEVANT ARCHITECTURAL, STRUCTURAL, PLUMBING & FIRE FIGHTING, ELECTRICAL AND TRAFFIC MANAGEMENT DRAWINGS. 5. ALL DOOR/WINDOW CILL & LINTEL LEVELS ARE MEASURED FROM MAIN FLOOR FINISHED LEVELS.							REVISIONS							APPROVAL BY DMRC				Certified that this document has been designed and checked in accordance with DDC Quality Assurance Plan.			Authorised Signatory for DDC. JP/EW/1B/DDC01 Project Manager			 DELHI METRO RAIL CORPORATION LTD. Metro Bhawan , Fire Brtgade Lane, Barakhamba Road, New Delhi-110001							
	REFERENCE DRAWINGS Drg. No. Description														DMRC APPROVAL				MGR/ARCH		DY CA (UG)III		CA/ARCH		Architecture Design In-charge/ Coordinator		Structure Design In-charge/ Coordinator		E&M Design In-charge/ Coordinator		PHASE 1B JAIPUR METRO PROJECT STATION: CHOTI CHOUPAR DRAWING TITLE: ECS/TVS LAYOUT UNDER CROFT LEVEL DRAWN BY: ADIL CHECKED BY: NITIN VERIFIED BY: L.R.S DATE: 31-03-2015 REV: R0 GRAPHICAL SCALE: 1:150 STATUS: FOR TENDER DRAWING NUMBER: JP-TD-ECS/TVS-10CC-1502 SHEET NO. 2 OF 3 SHEET SIZE UNE A1 ORDER N° P36-0017 56, Indo-Asia House, Institutional Area, sector-44 Gurgaon - 122002 (Haryana)  Engineering, Information, Imagination.	
															DY CST/TELECOM				CST/4		DY CE/DESIGN		CE/TECH									
															DY CST/AFC						ED/S&T		CSO									
															DY CST/SIGNALLING				CST/III		GM/O		GMM									
															DY CE/PLANNING				DY CEE/E&M		DY CEE/ECS		ED/ELEC-II									
	DY CEE(E)/UG-TR				CGM(E)/UG-TR		PM		CPM																							
	REV		PARTICULARS					DRN.	CHD.	VER.	DATE	ISSUE DATE	REV. FOR CONSTRUCTION																			

MATCH LINE FOR CONTINUATION REFER DRAWING NO. - JP-TD-ECS-TVS-10CC-1502 (SHEET 2 OF 3)

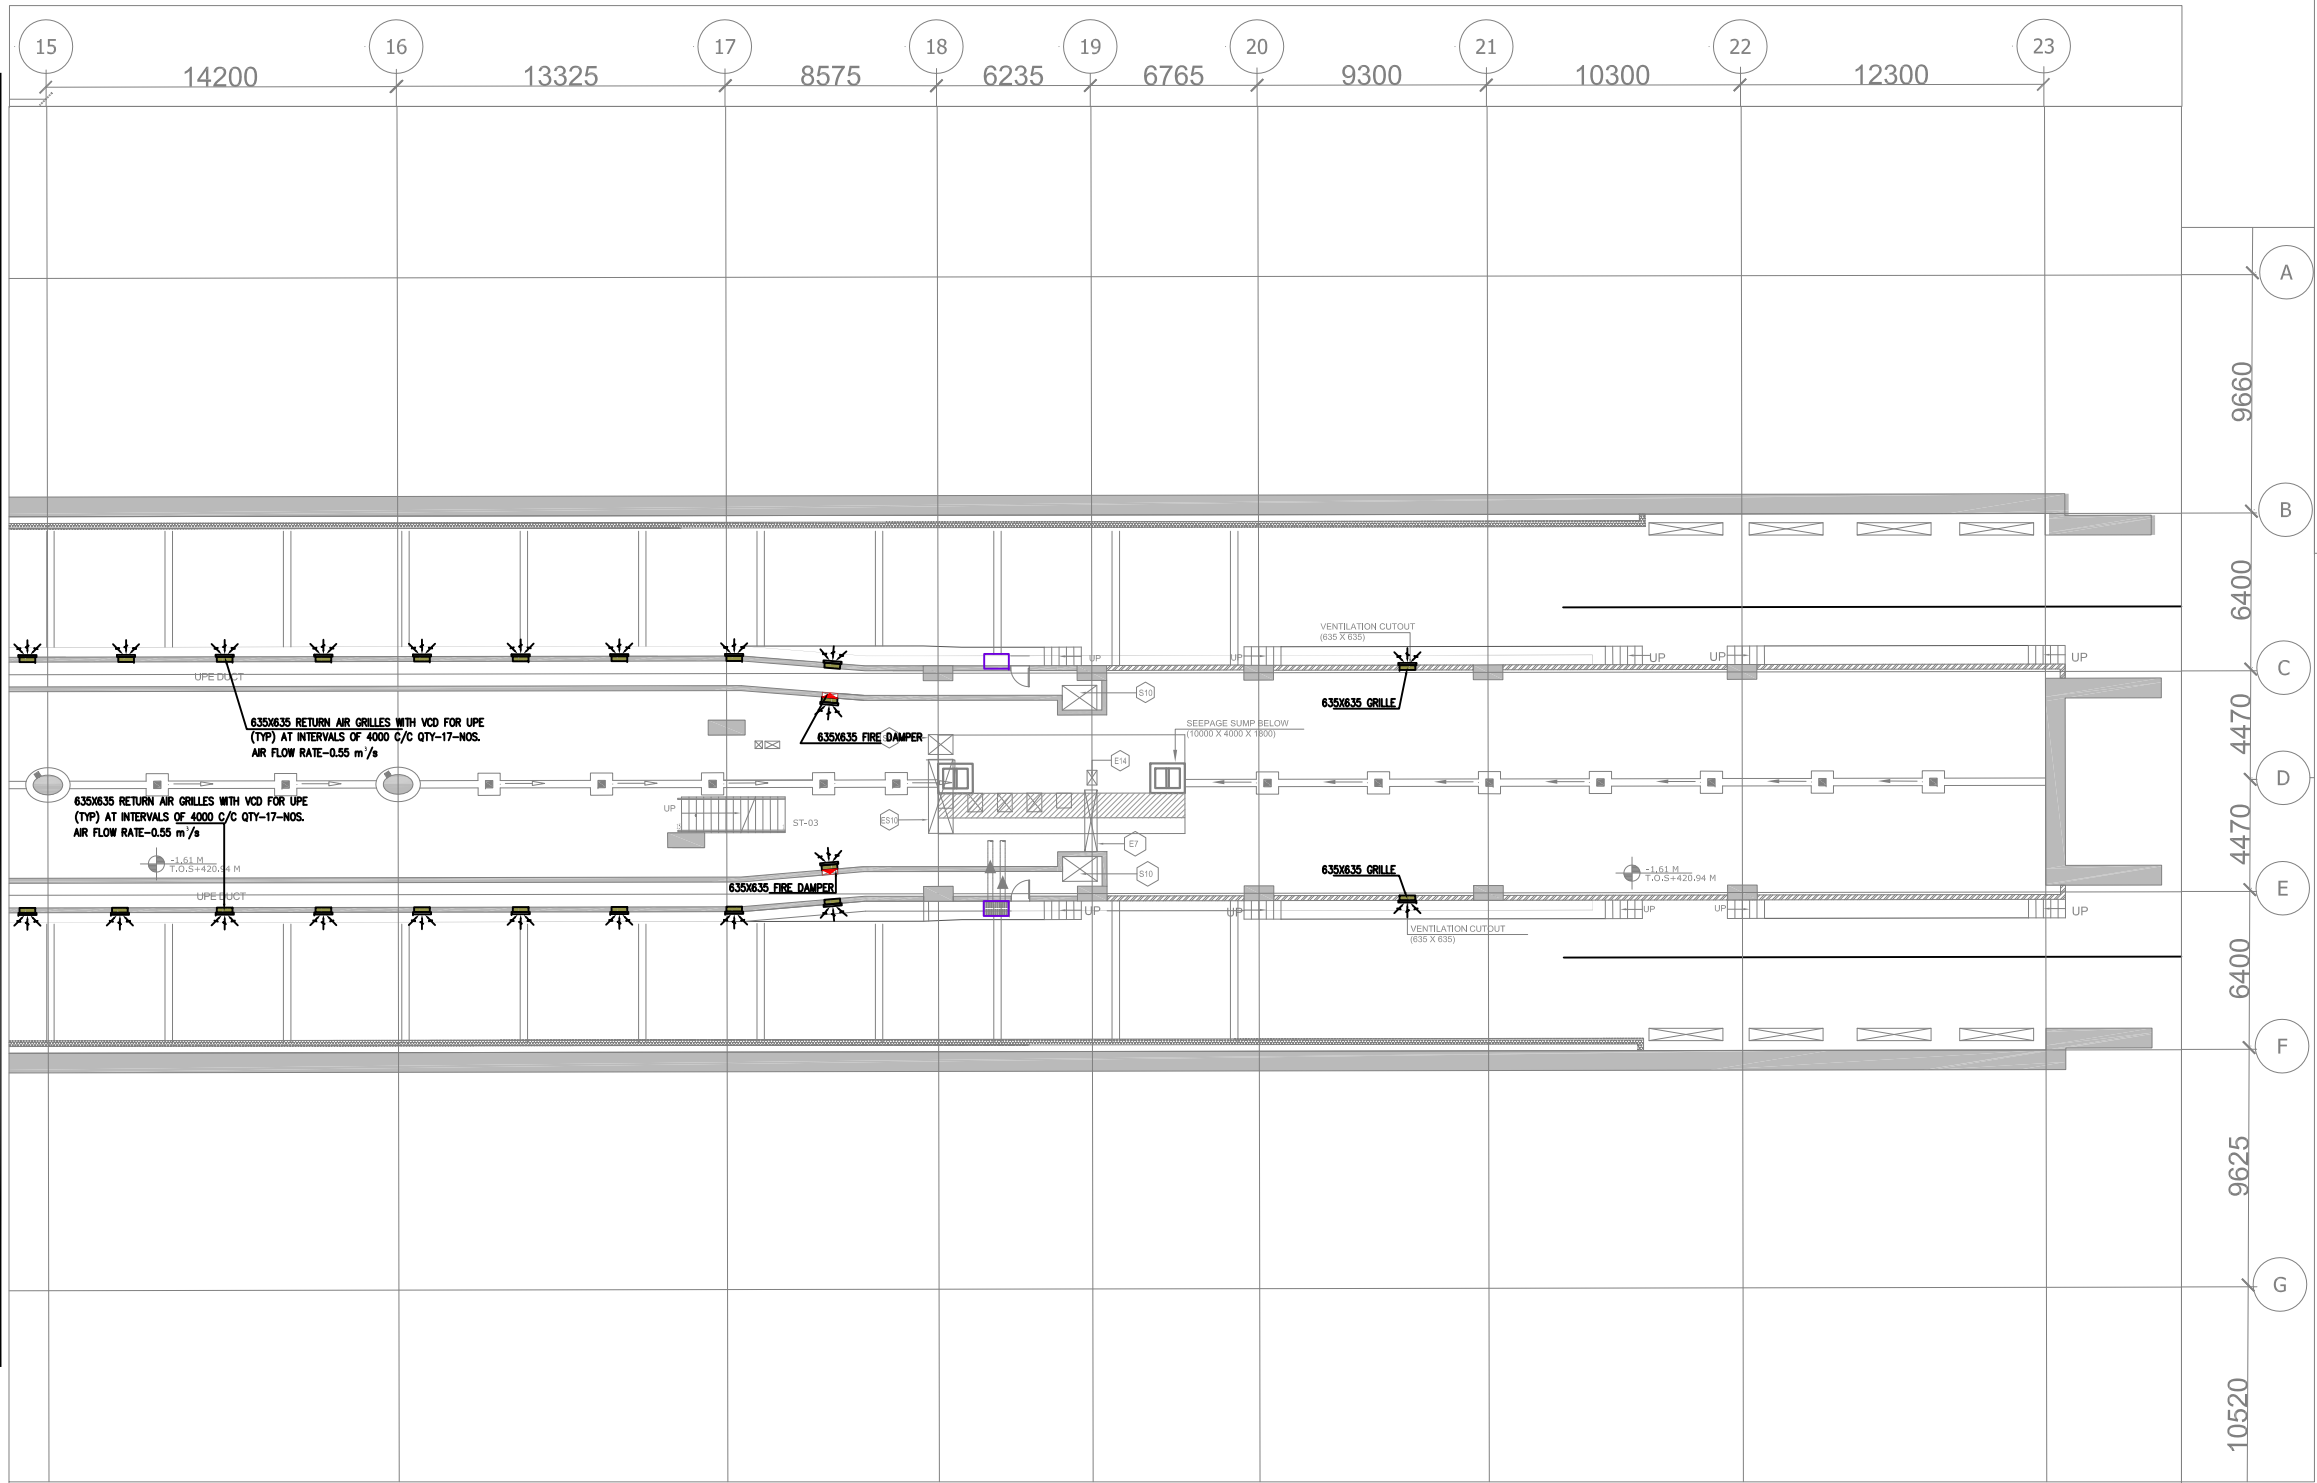

NOTES:-

- ALL DIMENSIONS ARE IN MM. UNLESS OTHERWISE SPECIFIED.
- ALL SUPPLY AND RETURN AIR DUCTING INSULATED WITH 25mm. THK. FIBREGLASS INSULATION IN A/C AREA.
- ALL SUPPLY AND RETURN AIR DUCTING INSULATED WITH 50mm. THK. FIBREGLASS INSULATION IN NON-A/C AREA.
- ALL CHILLED WATER PIPING INSULATED AS PER SPECIFICATION.
- ALL LEVELS OF DUCTS AND PIPES ARE FROM FINISHED FLOOR LEVELS.
- FOR ECS RELATED ELECTRICAL PLEASE REFER ECS ELECTRICAL LAYOUT.



ABBREVIATIONS

CC	CHOTI CHOUPAR STATION
AHU	Air Handling Unit
FAF	Fresh Air Fan
FCU	Fan Coil Unit
MD	Manual Damper
MFD	Motorised Fire Damper
MOD	Motor Operated Damper
OTE	Over Track Exhaust
R.A.G	Return Air Grille
S.A.G	Supply Air Grille
F.A.G	Fresh Air Grille
TEF	Track Way Exhaust Fan
UPE	Under Platform Exhaust
VCD	Volume Control Damper (Non fire rated)
VEF	Ventilation Exhaust Fan
VSF	Ventilation Supply Fan
B.O.D	Bottom of Duct
CHWP	CHILLED WATER PIPE
CDWP	CONDENSER WATER PIPE
VSD	VENTILATION SUPPLY DUCT
VED	VENTILATION EXHAUST DUCT

LEGEND

CHWP SUPPLY PIPE	CHWP RETURN PIPE
CHWP SUPPLY PIPE(AIR COOLED CHILLER)	CHWP RETURN PIPE(AIR COOLED CHILLER)
CDWP SUPPLY PIPE	CDWP RETURN PIPE
EQUALIZER HEADER	MAKEUP HEADER
DRAIN/OVERFLOW HEADER	VENTILATION EXHAUST DUCT
VENTILATION SUPPLY DUCT	MOTORISED OPERATED DAMPER
VOLUME CONTROL DAMPER	MOTORISED FIRE DAMPER
FIRE RATED MANUAL DAMPER	MANUAL DAMPER
RETURN AIR DUCT FIRE RATED	SUPPLY AIR DUCT
VENTILATION SUPPLY AIR DUCT	VENTILATION EXHAUST AIR DUCT
STAIRCASE PRESSURIZATION DUCT	SMOKE EXHAUST DUCT
SUPPLY AIR GRILLE	EXHAUST/SMOKE EXHAUST GRILLE
UNDER PLATFORM EXHAUST GRILLE	

 KEY PLAN

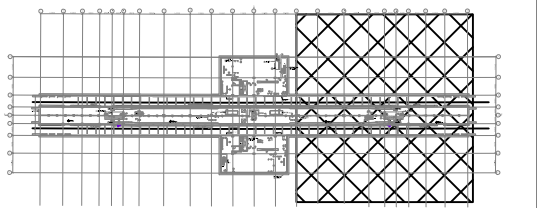

THIS DRAWING IS THE PROPERTY OF DELHI METRO RAIL CORPORATION LTD.	GENERAL NOTES: 1. ALL DIMENSIONS ARE IN MILLIMETERS. 2. ALL DIMENSIONS ARE TO BE READ AND NOT MEASURED. 3. ANY DISCREPANCIES MUST BE BROUGHT TO THE NOTICE OF THE DMRC BEFORE EXECUTION OF THE WORK AT SITE. 4. THIS DRAWING MUST BE READ IN CONJUNCTION WITH ALL RELEVANT ARCHITECTURAL, STRUCTURAL, PLUMBING & FIRE FIGHTING, ELECTRICAL AND TRAFFIC MANAGEMENT DRAWINGS. 5. ALL DOOR/WINDOW CILL & LINTEL LEVELS ARE MEASURED FROM MAIN FLOOR FINISHED LEVELS.							REVISIONS							APPROVAL BY DMRC				Certified that this document has been designed and checked in accordance with DDC Quality Assurance Plan.				Authorised Signatory for DDC. JP/EW/1B/DDC01 Project Manager				 DELHI METRO RAIL CORPORATION LTD. Metro Bhawan , Fire Brigade Lane, Barakhamba Road, New Delhi-110001																																																																																				
															PHASE 1B JAIPUR METRO PROJECT																																																																																																
															STATION: CHOTI CHOUPAR																																																																																																
															DRAWING TITLE: ECS/TVS LAYOUT UNDER CROFT LEVEL																																																																																																
	DRAWN BY: ADIL				CHECKED BY: NITIN				VERIFIED BY: L.R.S																																																																																																						
	DATE: 31-03-2015				REV: R0				GRAPHICAL SCALE: 1:150				STATUS: FOR TENDER																																																																																																		
	DRAWING NUMBER: JP-TD-ECS/TVS-10CC-1503								SHEET NO. 3 OF 3				SHEET SIZE UNE A1				ORDER N° P36-0017																																																																																														
REV														PARTICULARS														DRN														CHD														VER														DATE														ISSUE DATE														REV. FOR CONSTRUCTION													
DMRC APPROVAL				MGR/ARCH				DY CA (UG)-III				CA/ARCH				Architecture Design In-charge/ Coordinator				Structure Design In-charge/ Coordinator				E&M Design In-charge/ Coordinator				DETAIL DESIGN CONSULTANT (DDC) FOR CIVIL, ARCHITECTURAL & BUILDING WORKS OF TWO UNDERGROUND STATION (CHOTI CHOUPAR & BADI CHOUPAR), SHAFT AND TUNNELS OF PHASE 1B OF JAIPUR METRO																																																																																			
DY CST/TELECOM				CST-E-I				DY CE/DESIGN				CE/TECH				 ayesa Engineering, Information, Imagination, 56, Indo-Asia House, Institutional Area, sector-44 Gurgaon - 122002 (Haryana)																																																																																															
DY CST/AFC								ED/S&T				CSO																																																																																																			
DY CST/SIGNALLING				CST-E-III				GM/O				GMM																																																																																																			
DY CE/PLANNING				DY CEE/E&M				DY CEE/ECS				ED/ELEC-I																																																																																																			
DY CEE/(E)UG-TR				CGM/(E)UG-TR				PM				CPM																																																																																																			